

This drawing with all its contents is the sole intellectual property of the Hospital Services Consulting Corporation (HSCC) and shall not be used, copied, or reproduced in any form without the written permission of HSCC. It is prohibited.

NORTH

**LEGEND:**

1	100 Ø CI SOIL & VENT PIPE
2	100Ø CLWASTE & VENT PIPE
3	100Ø CI SOIL PIPE
4	100Ø CI WASTE PIPE
5	50Ø uPVC SOIL PIPE
6	40Ø uPVC WASTE PIPE
7	32Ø uPVC WASTE PIPE
8	TW DN / TAKE
9	UTW DN / TAKE
F.T	150 Ø S.W. PIPE
F.D	FLOOR TRAP 100X100
FD	FLOOR DRAIN 50Ø
FCO	FLOOR CLEAN OUT
X	VALVE
MH	MANHOLE (900X800)mm
GT	GULLY TRAP(300X300)mm

**PROJECT**

**PROPOSED  
100 BEDDED  
HOSPITAL  
PLUMBING  
(UP)**


**TITLE PLUMBING  
TENDER DRAWING**

**FIFTH FLOOR PLAN**

HSCC/D&E/PT/HS/ITD/PL-06  
Drawing No.

Job No.	Scale	Date
App by	Rev. by	Prep. by



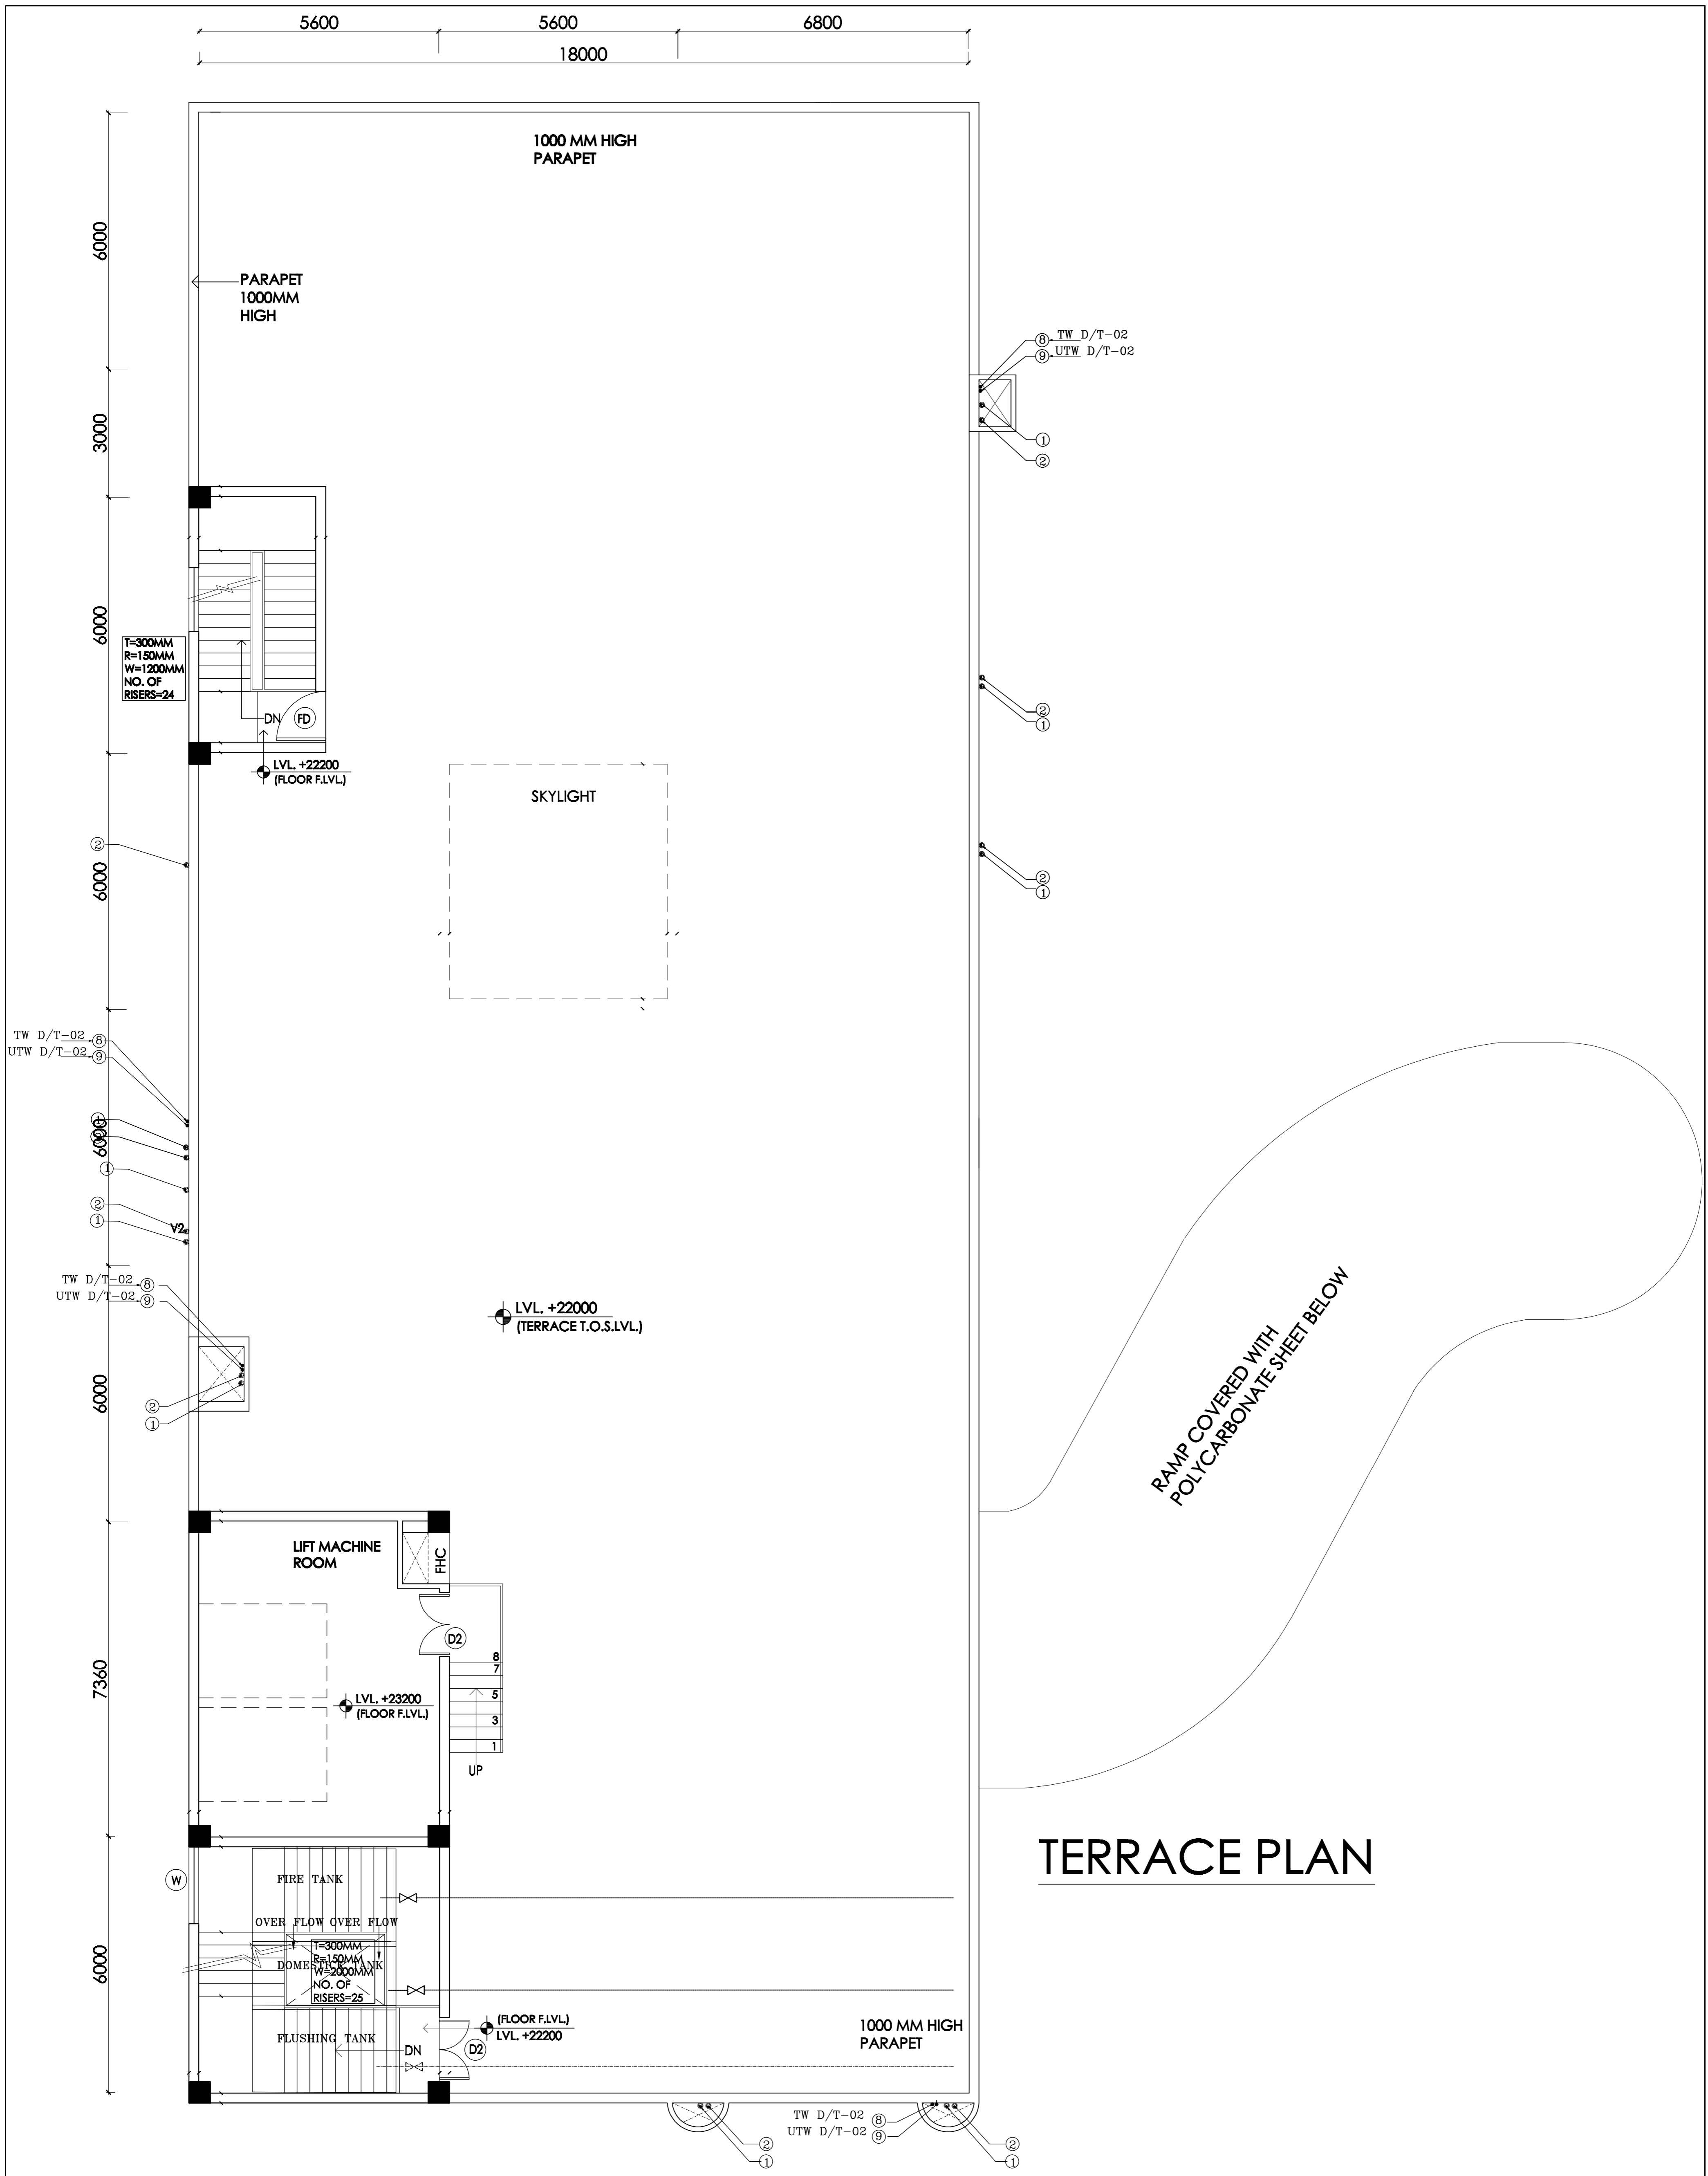

**TERRACE PLAN**

RAMP COVERED WITH POLYCARBONATE SHEET BELOW

**NORTH**

This drawing with all its contents is the sole intellectual property of the Hospital Services Consultancy Corporation (HSCC) and shall remain the property of HSCC. No part of this drawing or part thereof shall be used in any form whatsoever without the written permission of HSCC is prohibited.

**LEGEND:**

1	100 Ø CI SOIL & VENT PIPE
2	100Ø CLWASTE & VENT PIPE
3	100Ø CI SOIL PIPE
4	100Ø CI WASTE PIPE
5	50Ø uPVC SOIL PIPE
6	40Ø uPVC WASTE PIPE
7	32Ø uPVC WASTE PIPE
8	TW DN / TAKE
9	UTW DN / TAKE
F.1	150 Ø S.W. PIPE
F.D	FLOOR TRAP 100X100
F.O	FLOOR DRAIN 50Ø
F.CO	FLOOR CLEAN OUT
V	VALVE
MH	MANHOLE (900X800)mm
GT	GULLY TRAP(300X300)mm

**PROJECT**

**PROPOSED  
100 BEDEDDED  
HOSPITAL  
PLIBHIT  
(UP)**


**TITLE PLUMBING  
TENDER DRAWING**

**TERRACE PLAN**

HSCC/D&E/PT/HS/TD/PL-07			
Drawing No.			
Job No.	Scale	Date	
App by	Rev. by	Prep. by	

**HSCC (INDIA) LIMITED**  
(A GOVERNMENT OF INDIA ENTERPRISE)  
**HSCC**  
NEW DELHI INDIA

**NOTES**  
 1. DRAWINGS TO BE READ NOT MEASURED  
 2. PARTITION WALL IN TOILETS UP TO LINTEL HEIGHT

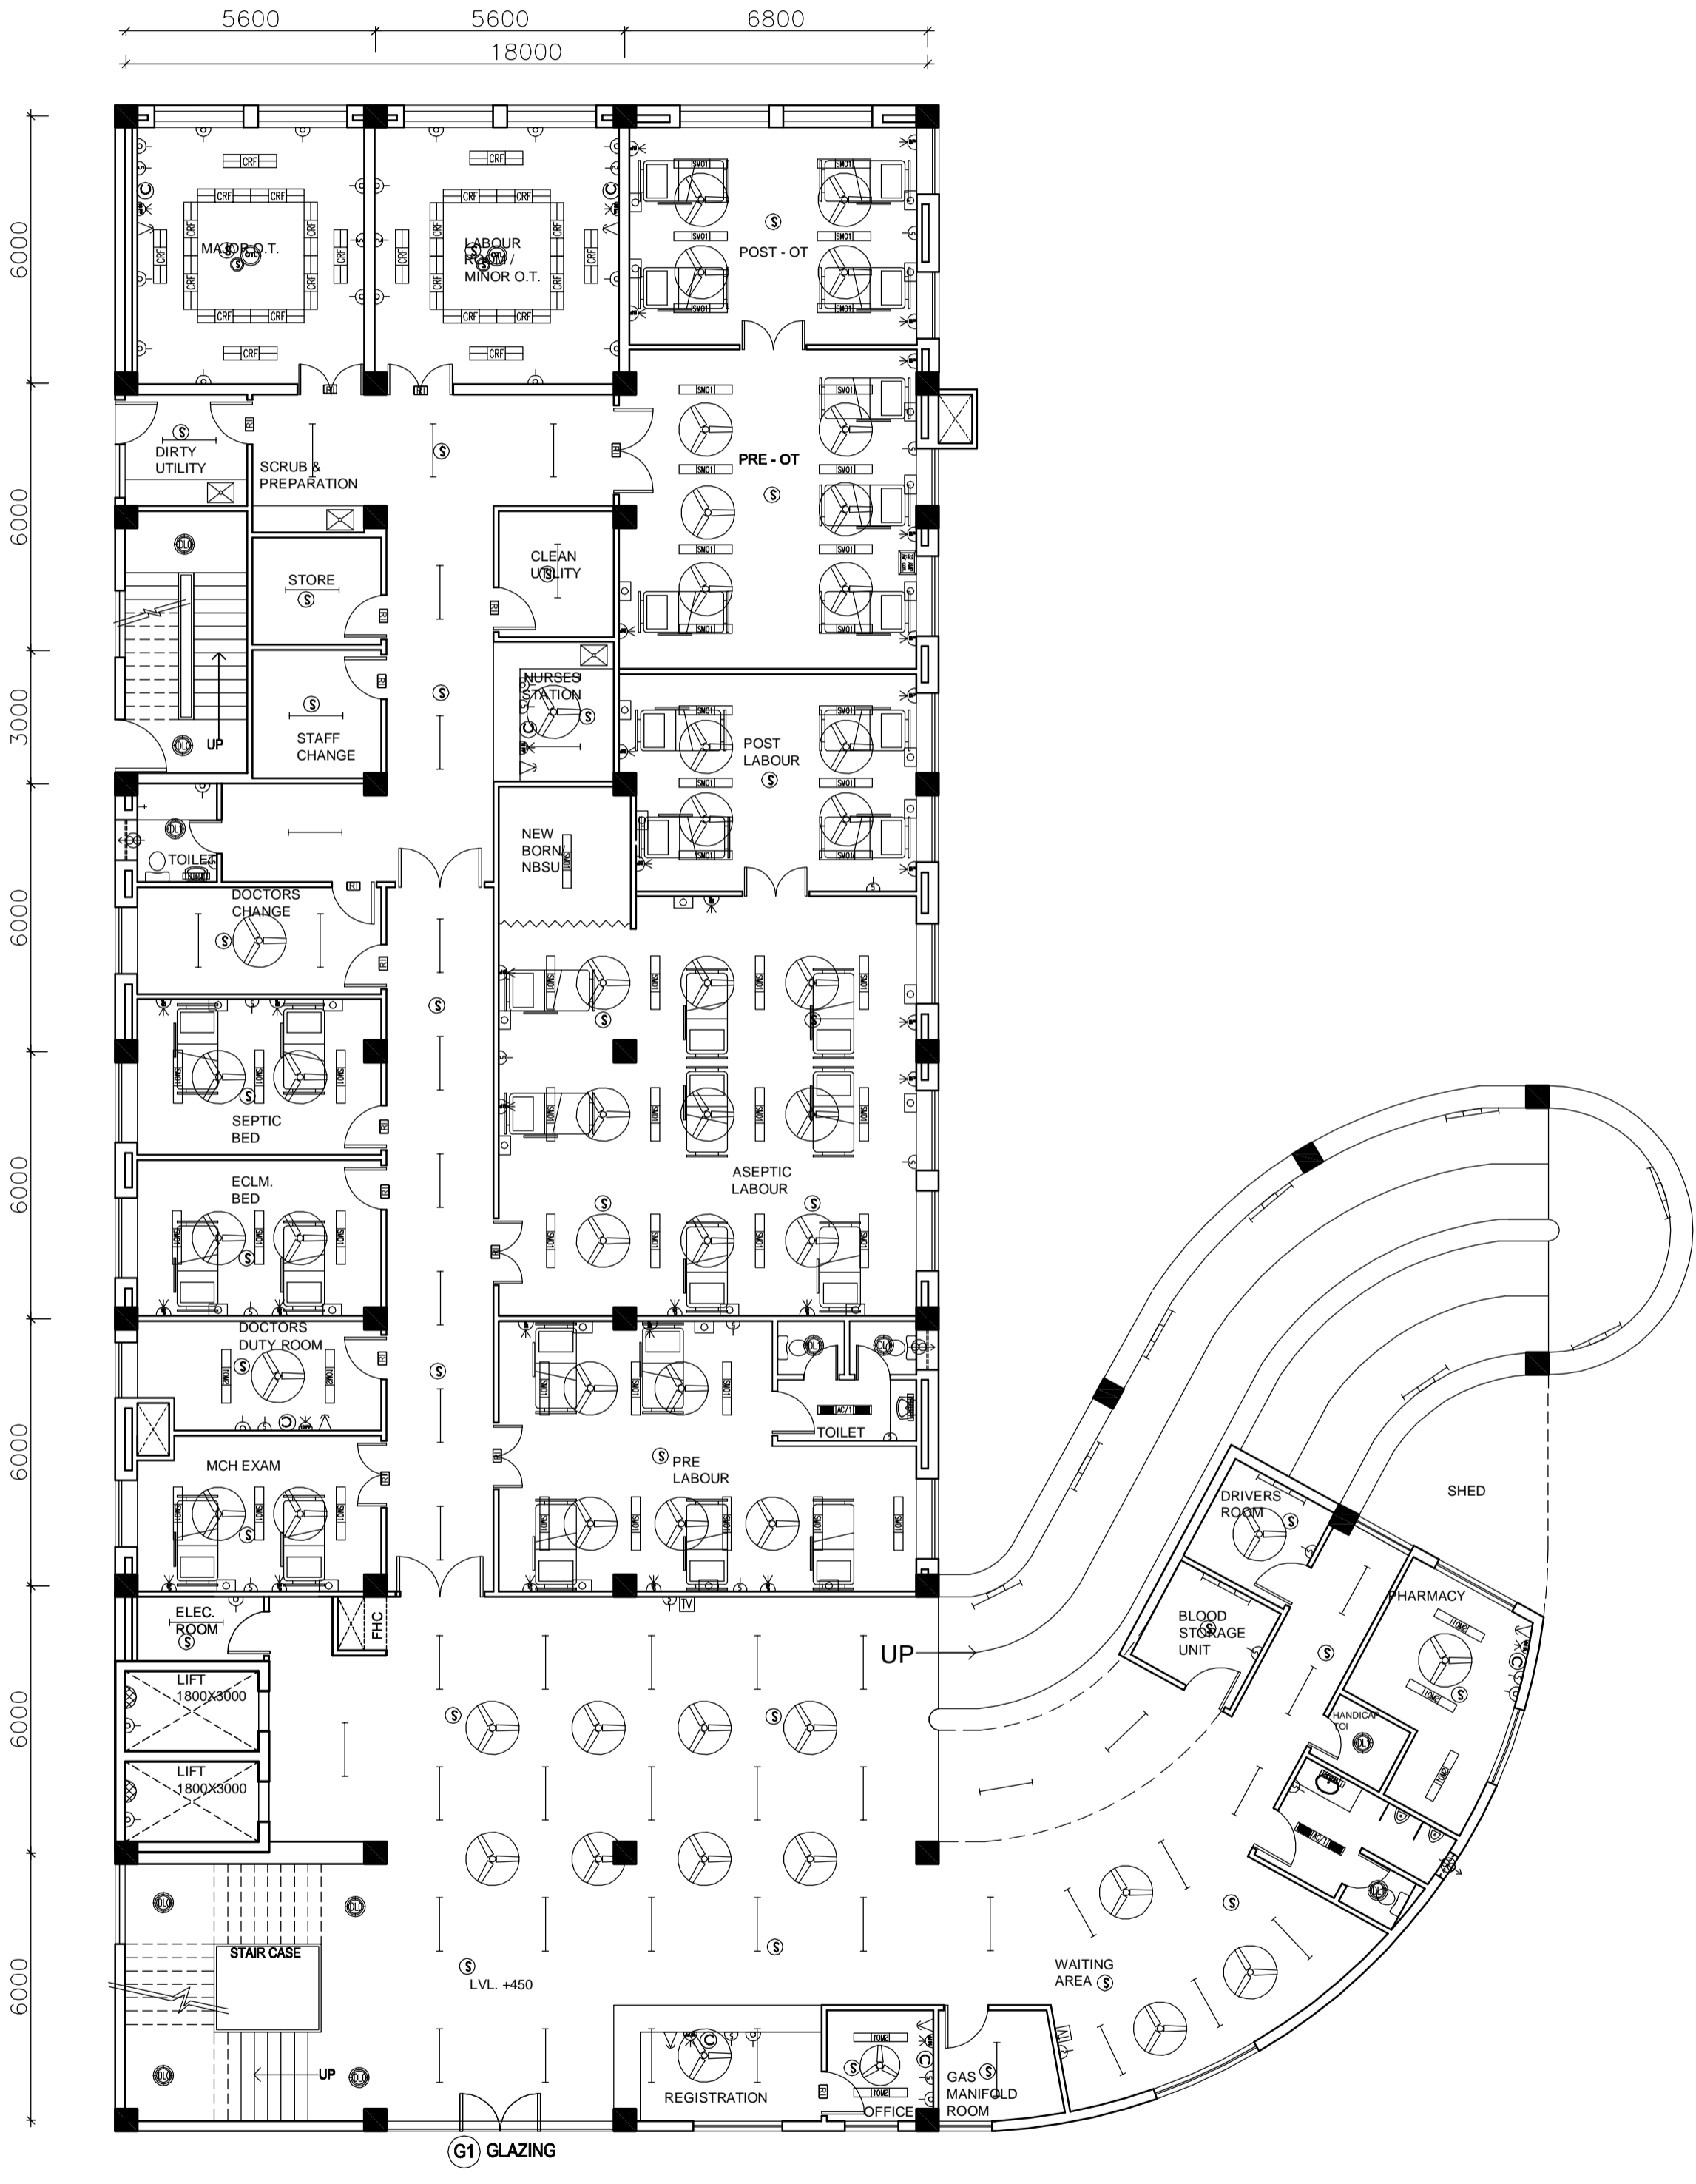

**GROUND FLOOR**

REVISION - 01  
 REVISED AS PER THE GUIDELINES OF VETTING COMMITTEE

**PROJECT**  
 PROPOSED  
 100 BEDDED HOSPITAL  
 PILIBHIT

**TITLE**  
 TENDER DRAWING  
 GROUND FLOOR PLAN  
 AREA - 1089.89 SQM

**ELECTRICAL LAYOUT**

HSCC/TD/PILIBHIT/EL-201  
 Drawing No. Rev. - 01

Job No.	NTS Scale	Date
App by	Rev. by	Prep. by