


- NOTES**
1. DRAWINGS TO BE READ NOT MEASURED
 2. PARTITION WALL IN TOILETS UP TO LINTEL HEIGHT

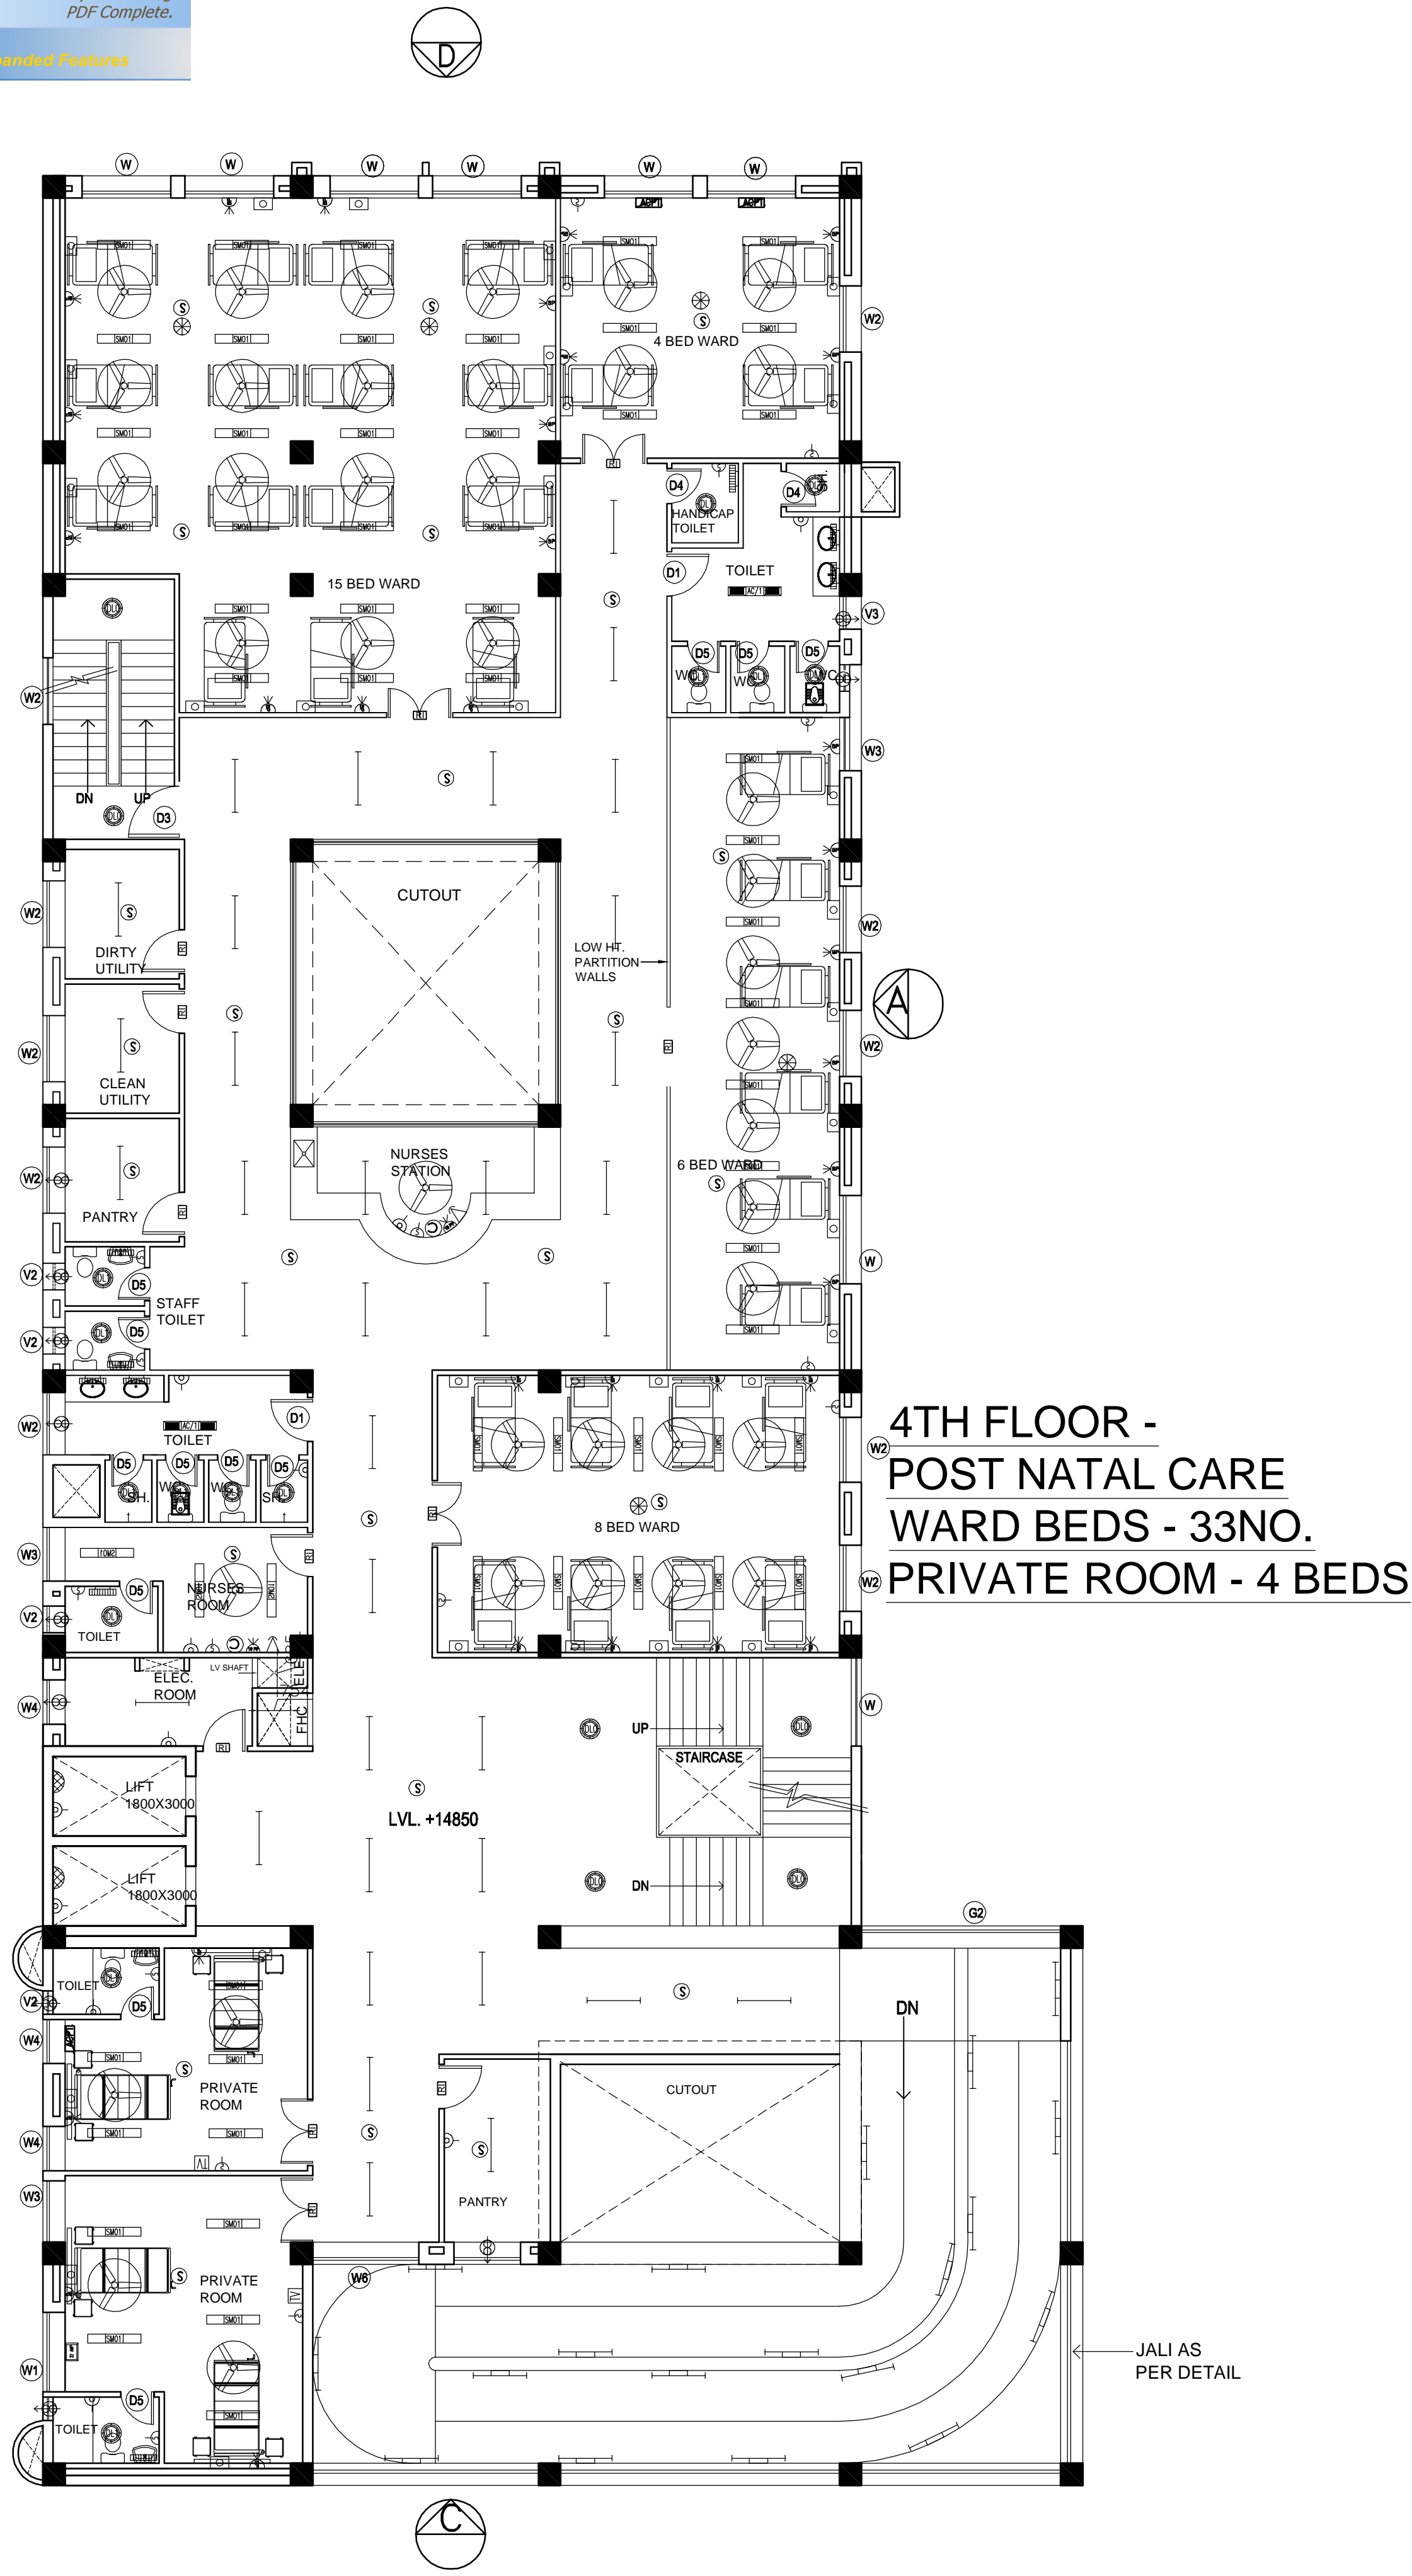

**4TH FLOOR -
 POST NATAL CARE
 WARD BEDS - 33NO.
 PRIVATE ROOM - 4 BEDS**

REVISION - 01
 REVISED AS PER THE GUIDELINES OF VETTING COMMITTEE


PROJECT
 PROPOSED
 100 BEDDED HOSPITAL
 SHAHJAHANPUR

TITLE
 TENDER DRAWING
 FOURTH FLOOR PLAN
 AREA - 903.89 SQM

ELECTRICAL LAYOUT

HSCC/TD/SHAHJAHANPUR/EL-05
 Drawing No. Rev. - 01

Job No.	NTS Scale	Date
App by	Rev. by	Prep. by

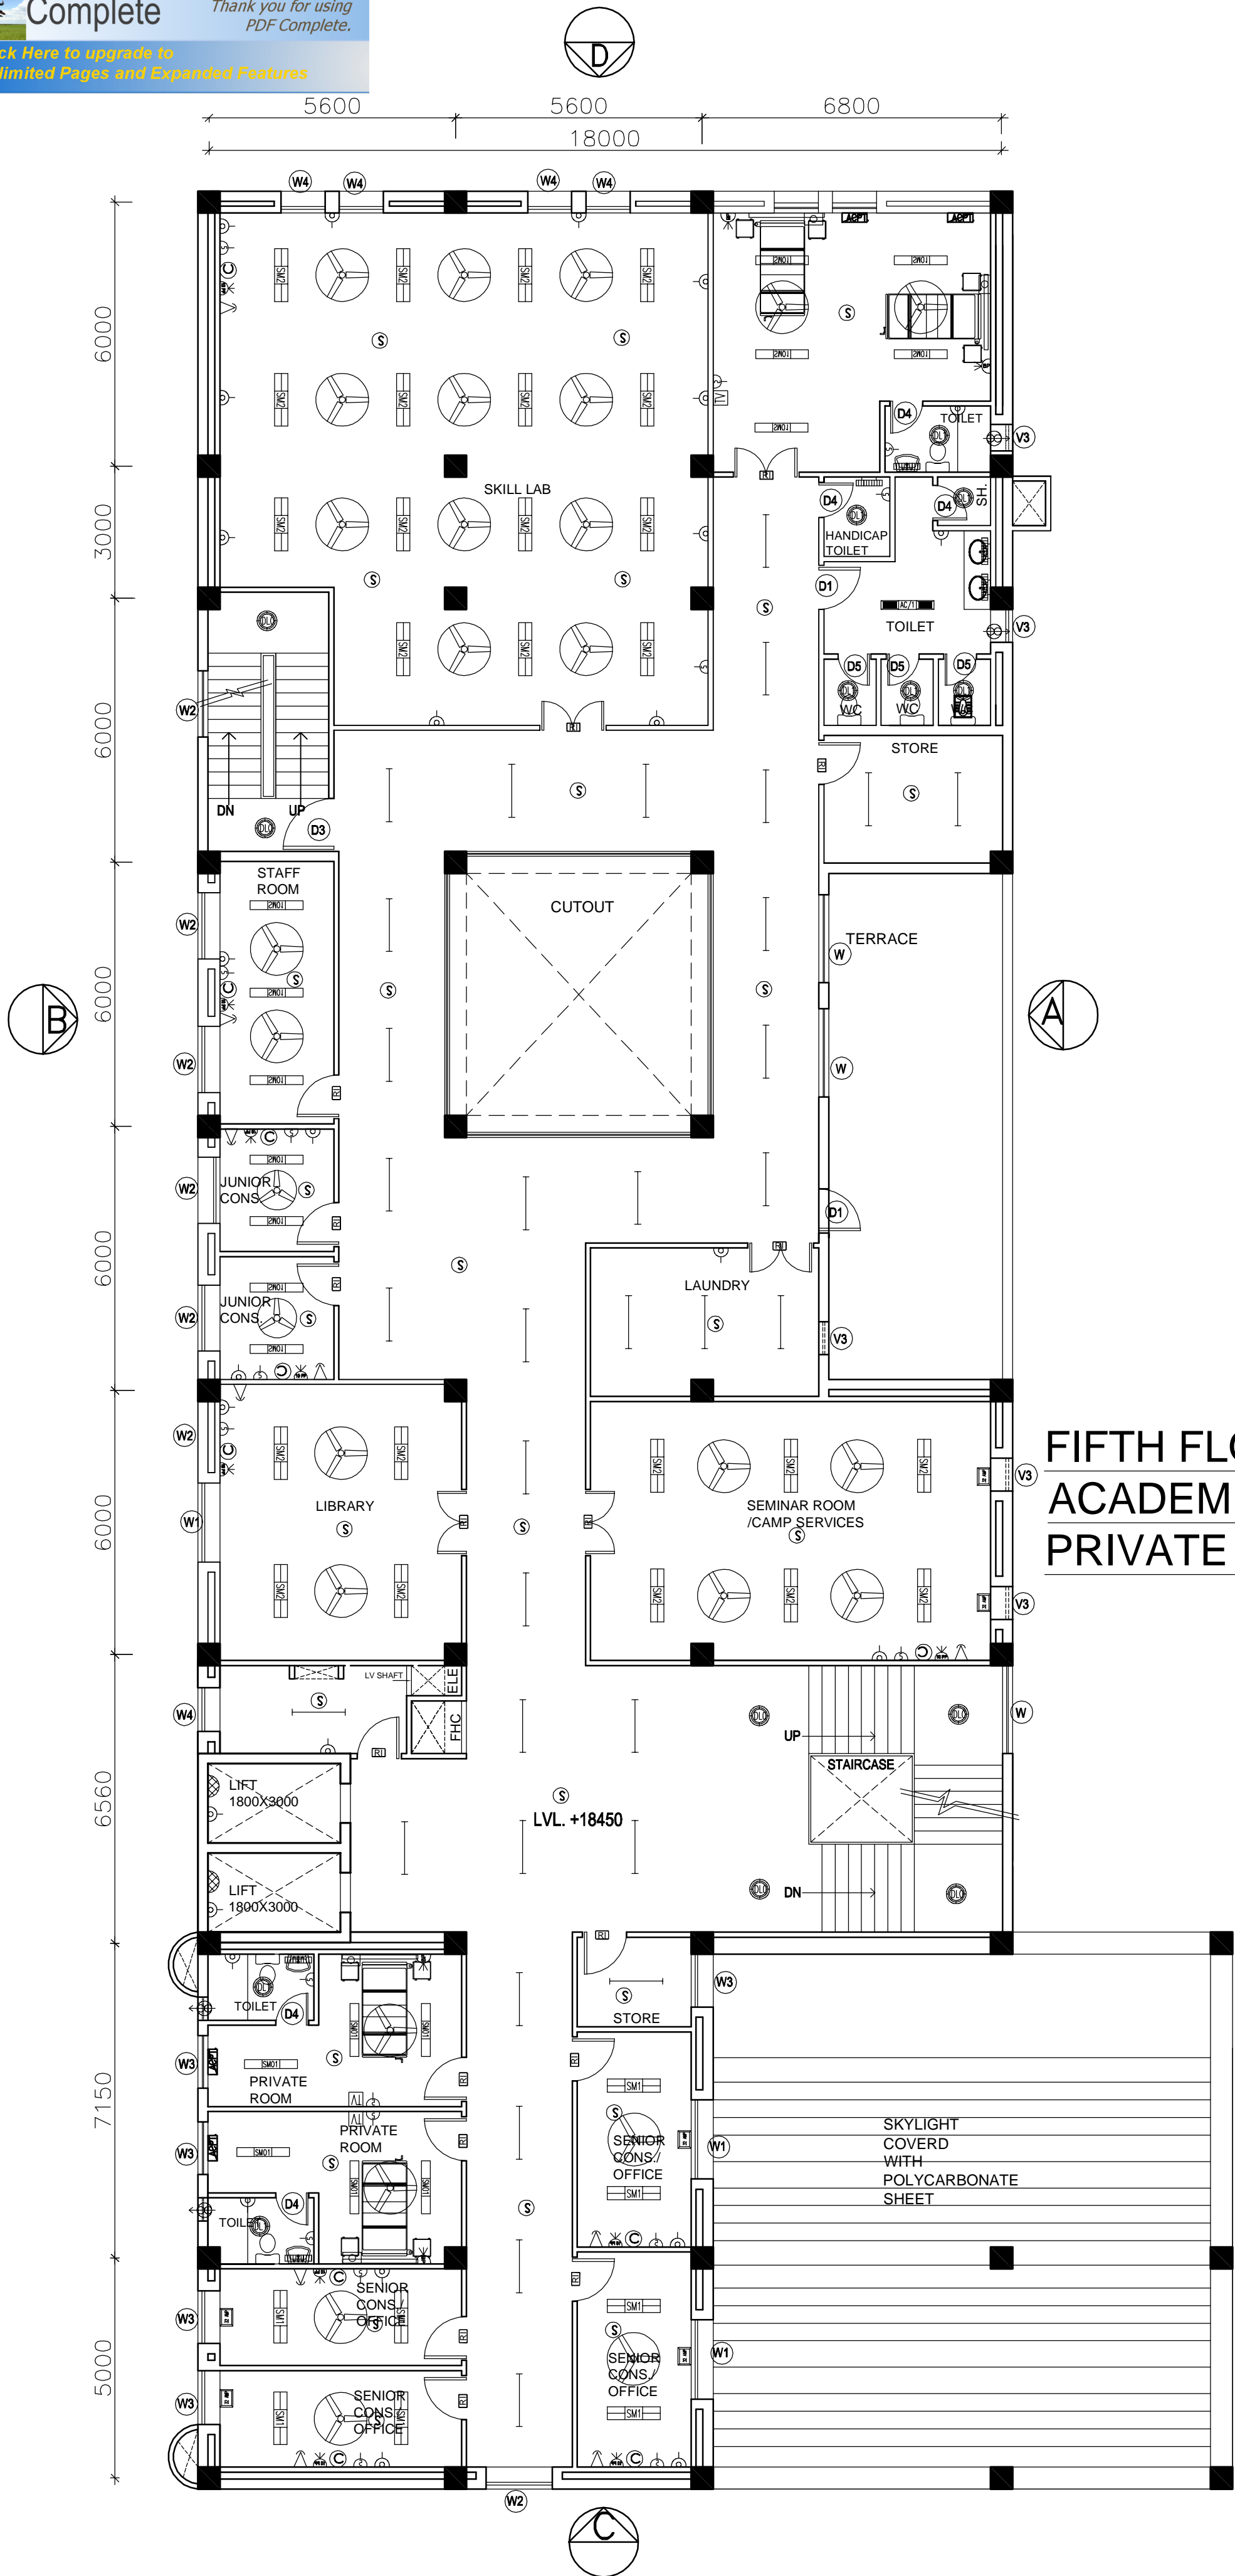

**FIFTH FLOOR
 ACADEMIC SECTION
 PRIVATE ROOM - 4 BEDS**

NOTES
 1. DRAWINGS TO BE READ NOT MEASURED
 2. PARTITION WALL IN TOILETS UP TO LINTEL HEIGHT

REVISION - 01
 REVISED AS PER THE GUIDELINES OF VETTING COMMITTEE


PROJECT
 PROPOSED
 100 BEDDED HOSPITAL
 SHAHJAHANPUR

TITLE
 TENDER DRAWING
 FIFTH FLOOR PLAN
 AREA - 835.64 SQM

ELECTRICAL LAYOUT


HSCC/TD/SHAHJAHANPUR/EL-06
 Drawing No. Rev. - 01

Job No.	NTS Scale	Date
App by	Rev. by	Prep. by

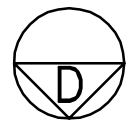

This drawing with all its contents is the sole intellectual property of the Hospital Services Consultancy Corporation (India) Ltd. Copying of this drawing or part thereof, or its use in any form whatsoever without the written permission of HSCC is prohibited.

- NOTES**
1. DRAWINGS TO BE READ NOT MEASURED
 2. PARTITION WALL IN TOILETS UP TO LINTEL HEIGHT

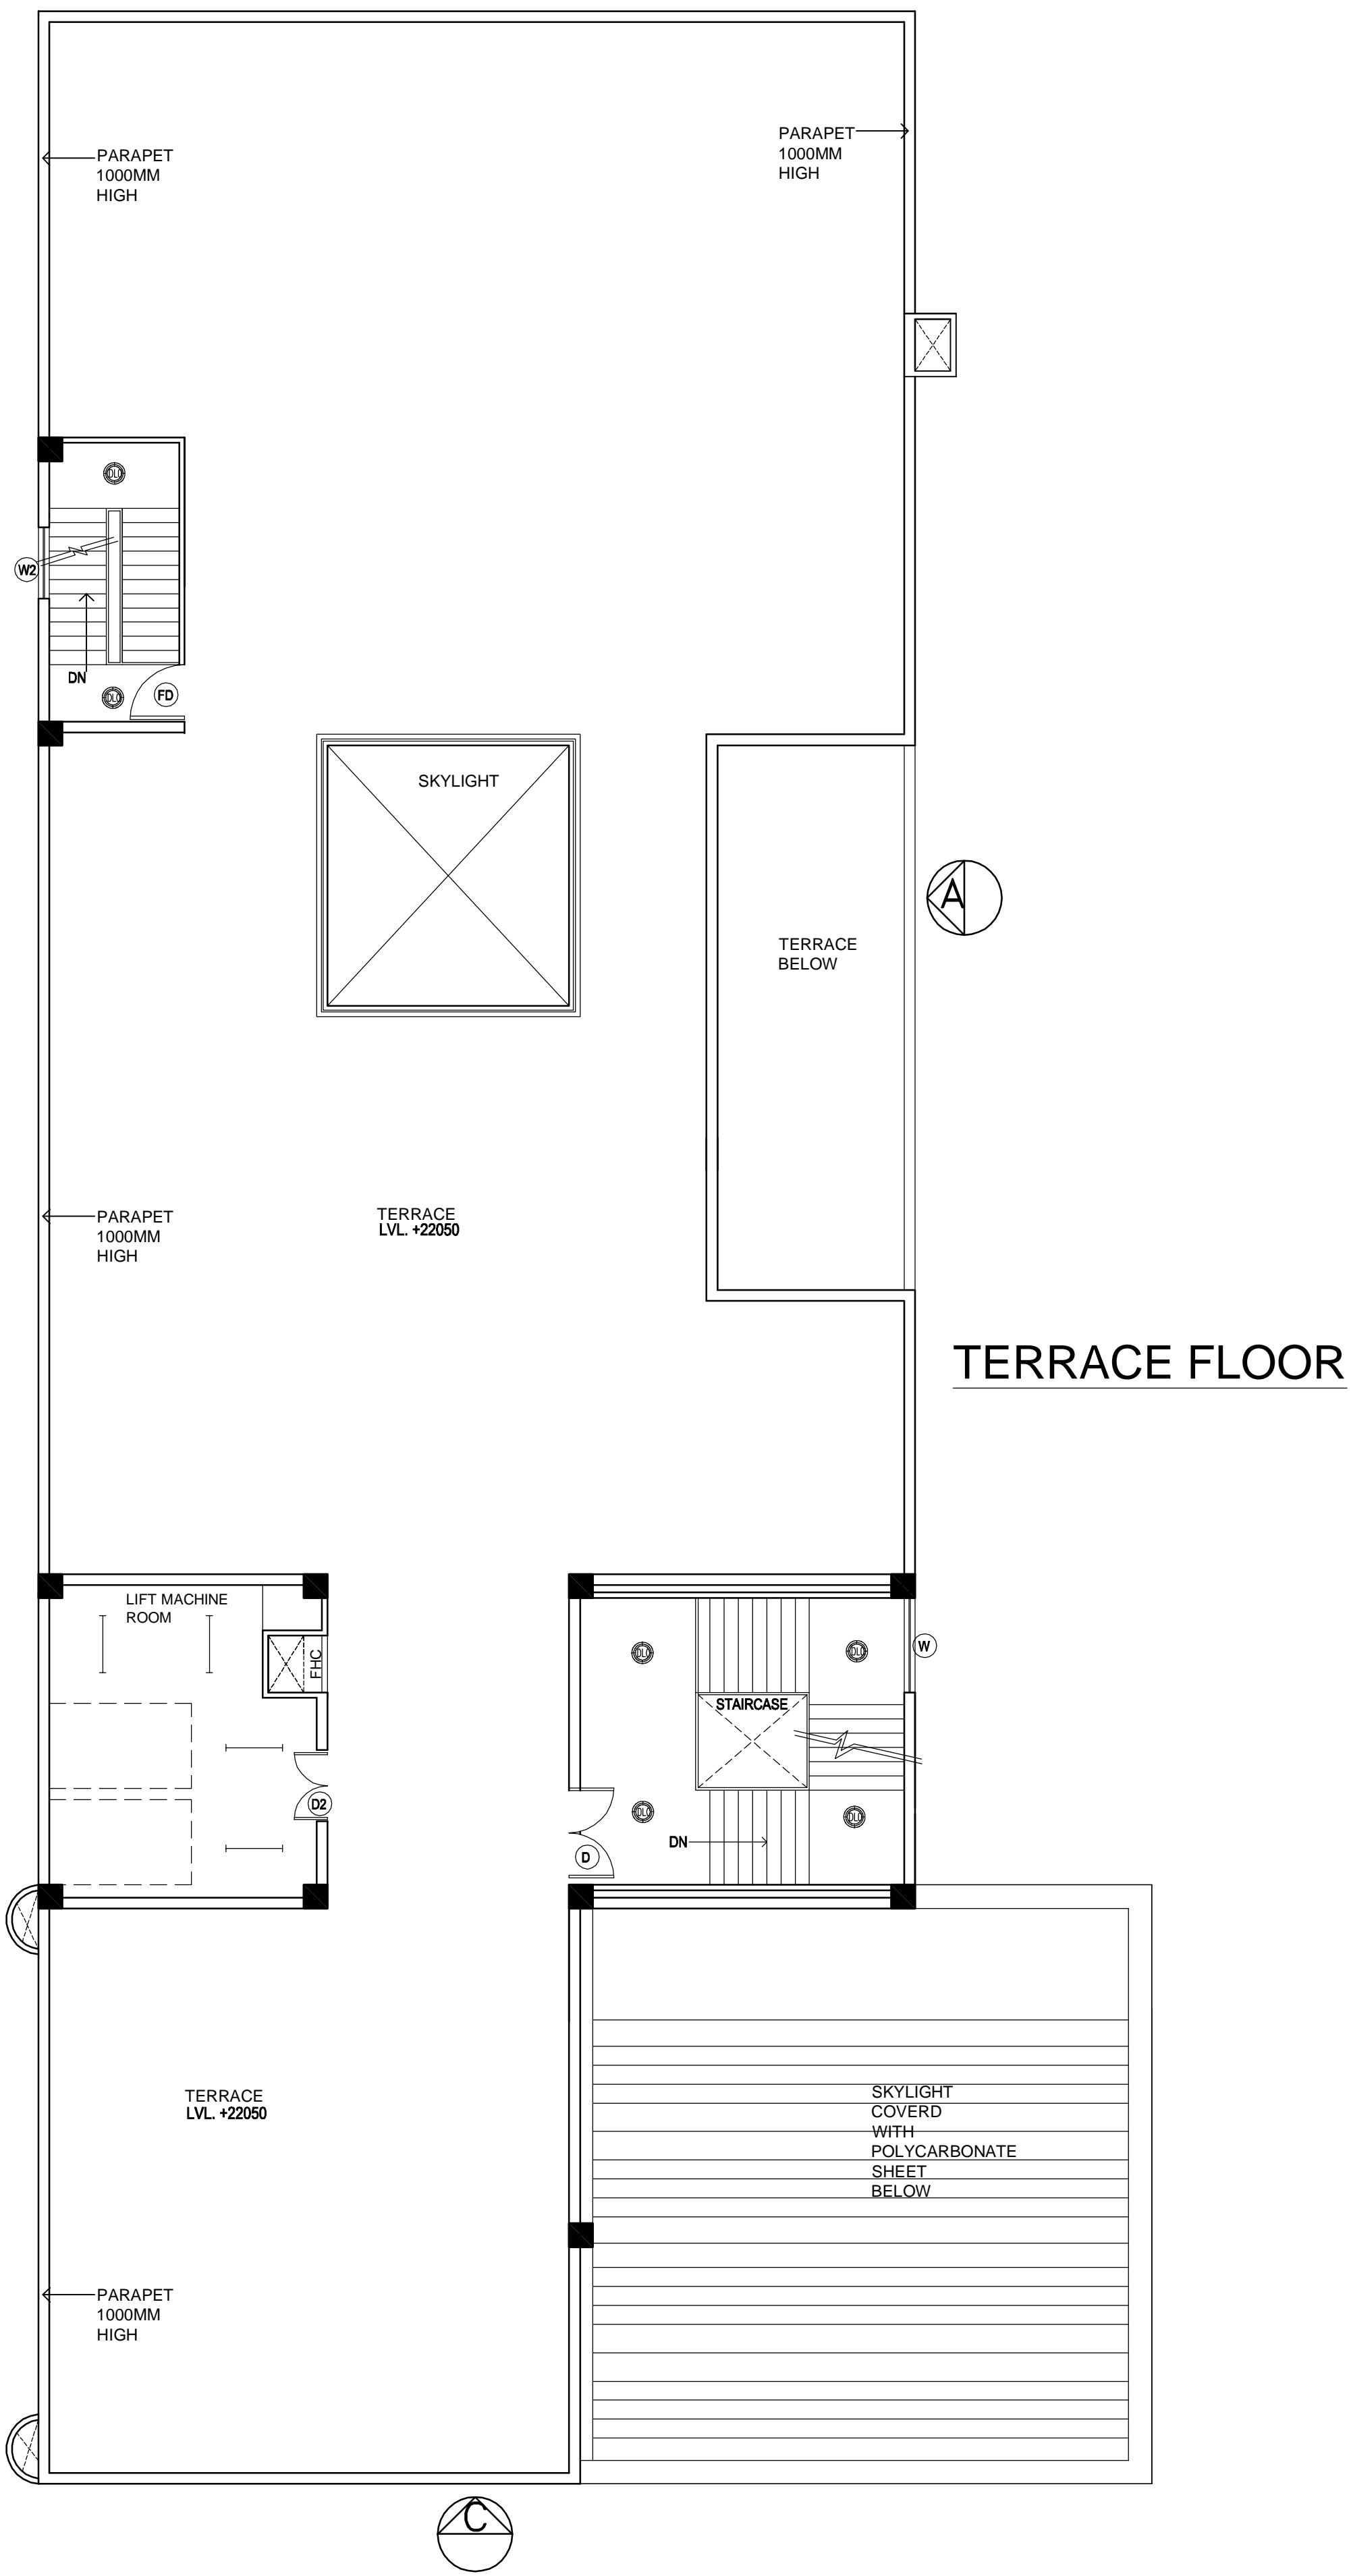

REVISION - 01
 REVISED AS PER THE GUIDELINES OF VETTING COMMITTEE

PROJECT
 PROPOSED
 100 BEDDED HOSPITAL
 SHAHJAHANPUR

TITLE
 TENDER DRAWING
 TERRACE PLAN
 AREA - 113.75 SQM
 ELECTRICAL LAYOUT

HSCC/TD/SHAHJAHANPUR/EL-07
 Drawing No. Rev. - 01

Job No.	Scale	Date
App by	Rev. by	Prep. by


This drawing with all its contents is the sole intellectual property of the Hospital Services Consultancy Corporation (India) Ltd. Copying of this drawing or part thereof or its use in any form whatsoever without the written permission of HSCC is prohibited.

NOTES

1. DRAWINGS TO BE READ NOT MEASURED
2. PARTITION WALL IN TOILETS UP TO LINTEL HEIGHT

DOOR / WINDOW SCHEDULE

S.NO.	TYPE	WIDTH	CILL	LINTEL
1	D	2000	—	2100
2	D1	1000	—	2100
3	D2	1500	—	2100
4	FD3	1200	—	2250
5	D4	800	—	2100
6	D5	750	—	2100
7	DW1	2200	—	2900
8	W	2000	900	2600
9	W1	1800	900	2600
10	W2	1500	900	2600
11	W3	1200	900	2600
12	W4	1000	900	2600
13	W5	830	900	2600
14	W6	2400	900	2600
15	V1	900	1700	2600
16	V2	600	1700	2600
17	V3	750	1700	2600

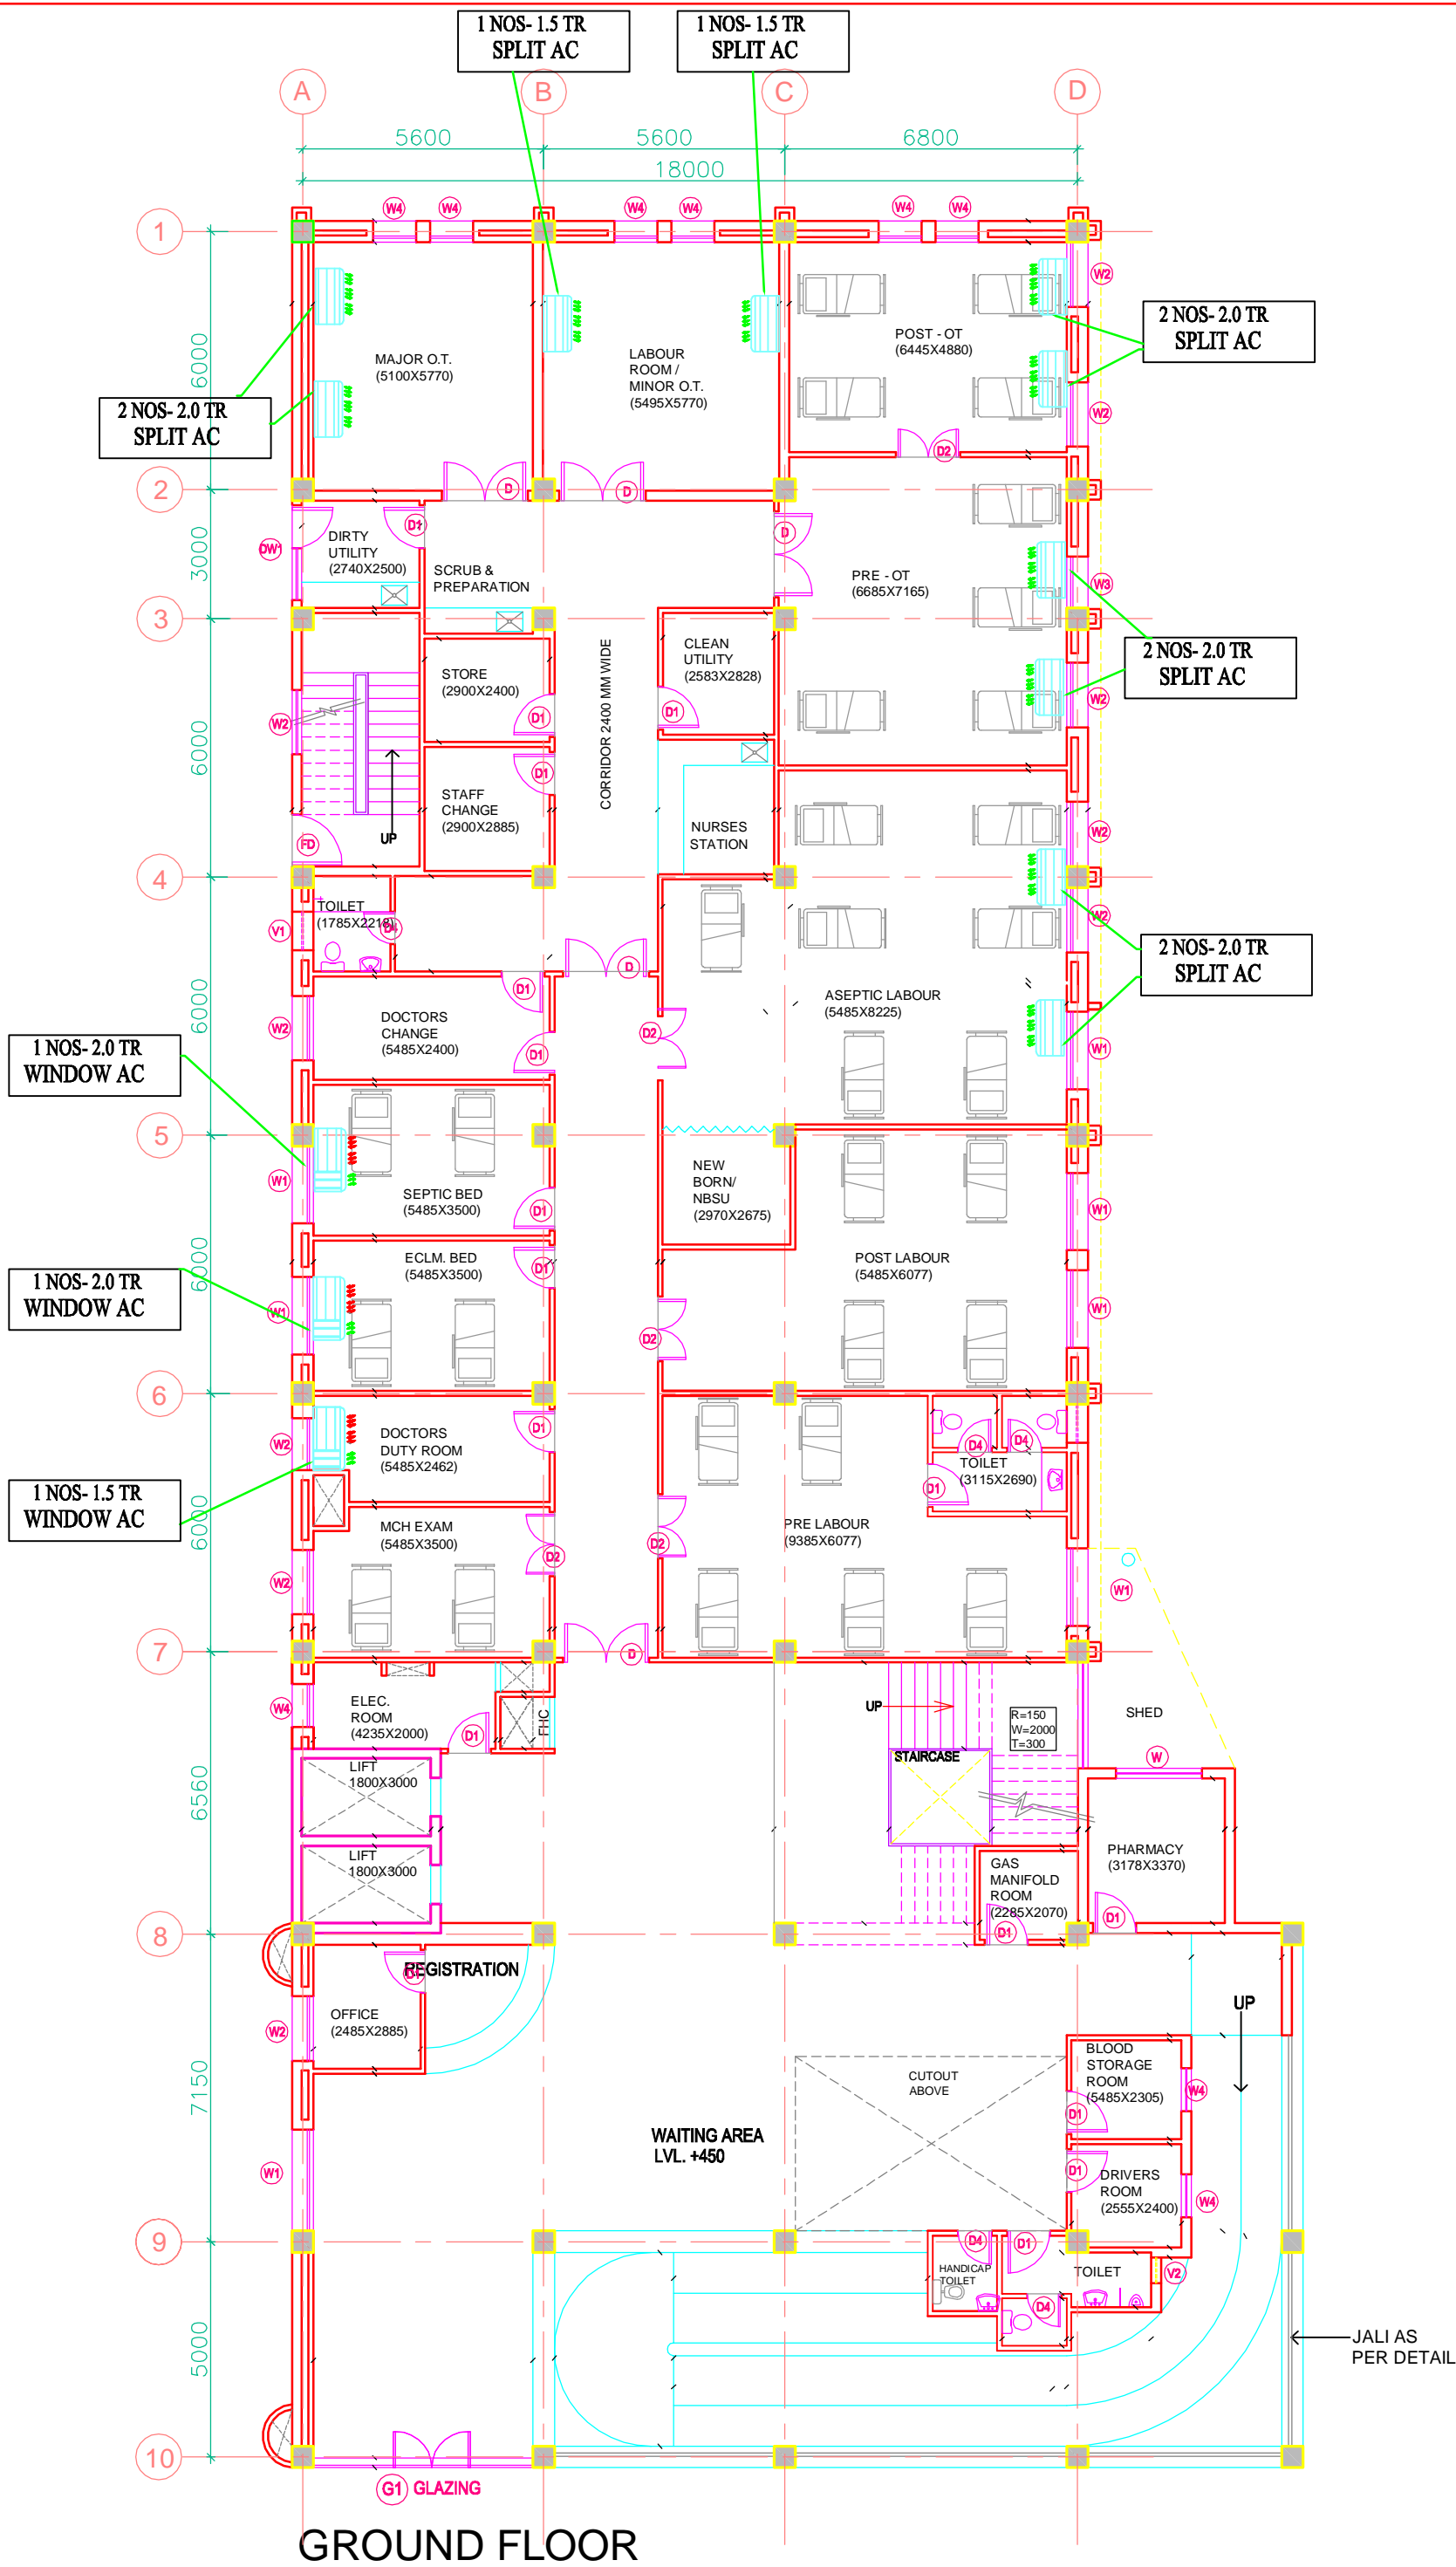

GROUND FLOOR

REVISION - 01
REVISED AS PER THE GUIDELINES OF VETTING COMMITTEE

PROJECT
PROPOSED
100 BEDDED HOSPITAL
SHAHJAHANPUR

TITLE
TENDER DRAWING
HVAC LAYOUT
GROUND FLOOR PLAN

HSCC/D&E/HVAC/UP-SHAHJAHANPUR/AC-01
Rev. - 01

Job No. 1:150 Scale JUNE 12,2013 Date

App by Rev. by Prep. by

JALI AS PER DETAIL

HSCC (INDIA) LIMITED
(A GOVERNMENT OF INDIA ENTERPRISES)
HSCC
NEW DELHI INDIA


This drawing with all its contents is the sole intellectual property of the Hospital Services Consultancy Corporation (India) Ltd. Copying of this drawing or part thereof or its use in any form whatsoever without the written permission of HSCC is prohibited.

NOTES

1. DRAWINGS TO BE READ NOT MEASURED
2. PARTITION WALL IN TOILETS UP TO LINTEL HEIGHT

DOOR / WINDOW SCHEDULE

S.NO.	TYPE	WIDTH	CILL	LINTEL
1	D	2000	—	2100
2	D1	1000	—	2100
3	D2	1500	—	2100
4	FD3	1200	—	2250
5	D4	800	—	2100
6	D5	750	—	2100
7	DW1	2200	—	2900
8	W	2000	900	2600
9	W1	1800	900	2600
10	W2	1500	900	2600
11	W3	1200	900	2600
12	W4	1000	900	2600
13	W5	830	900	2600
14	W6	2400	900	2600
15	V1	900	1700	2600
16	V2	600	1700	2600
17	V3	750	1700	2600

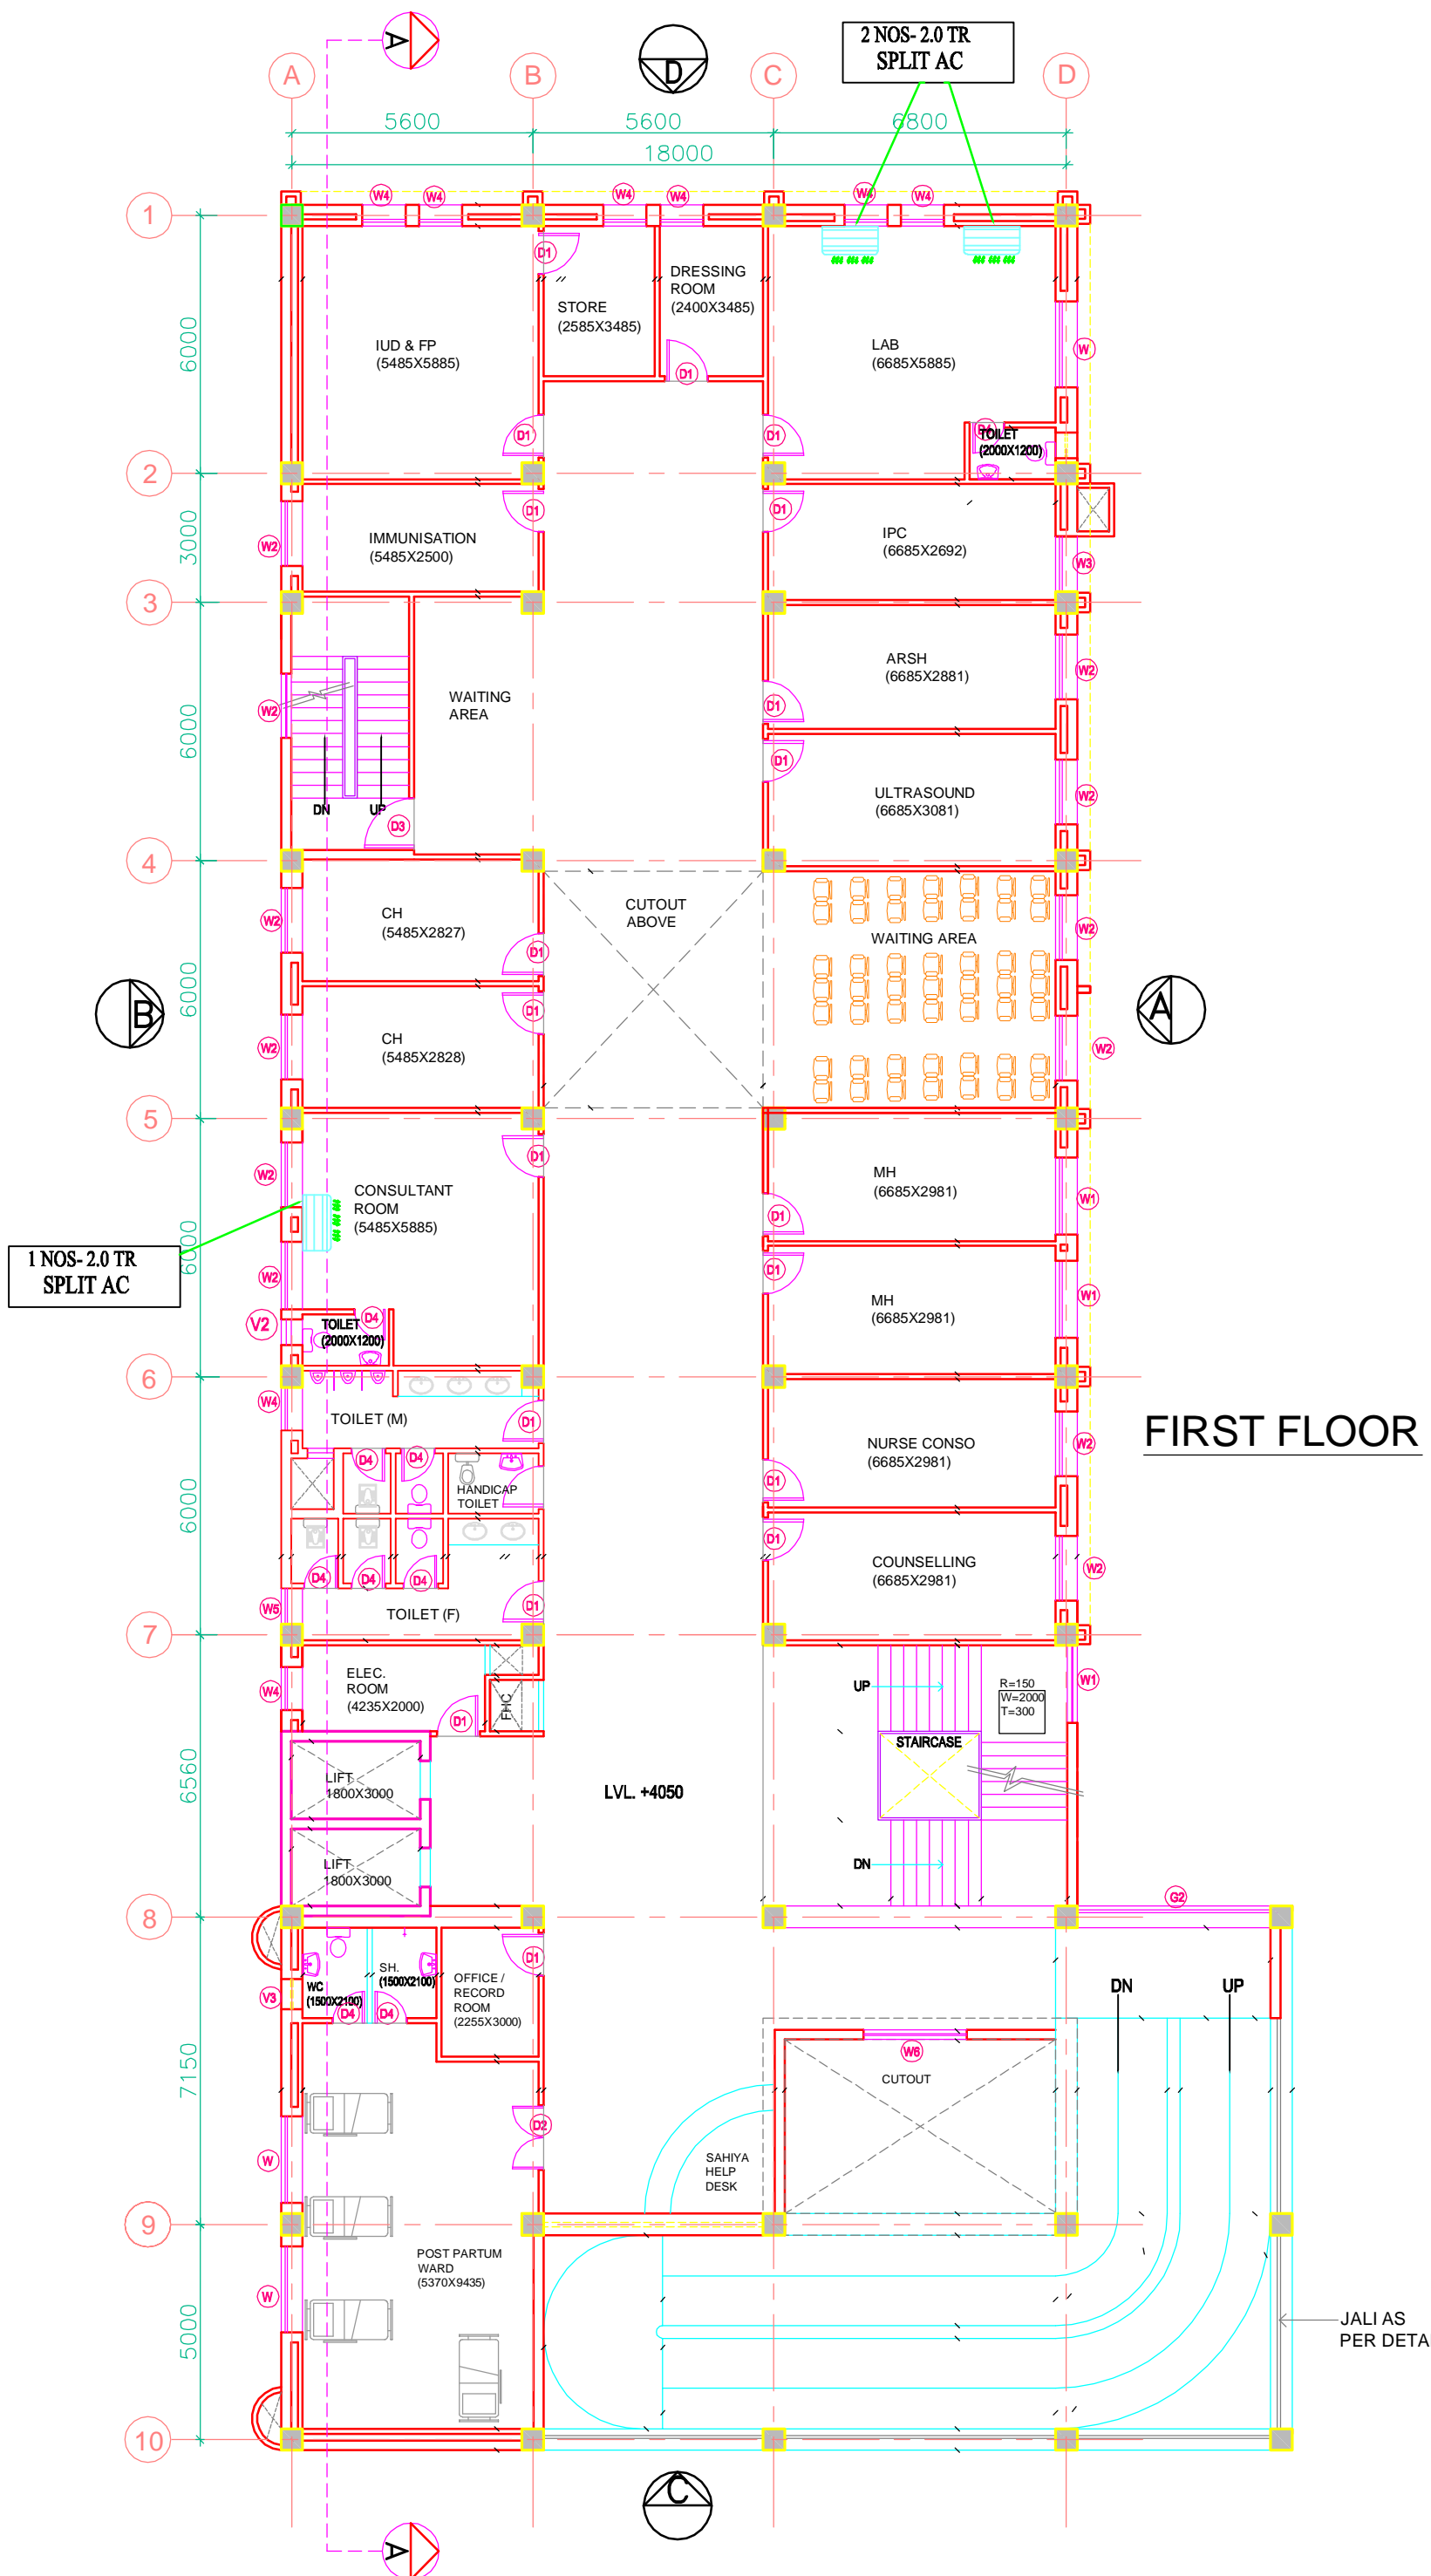

FIRST FLOOR

REVISION - 01
REVISED AS PER THE GUIDELINES OF VETTING COMMITTEE

PROJECT
PROPOSED
100 BEDDED HOSPITAL
SHAHJAHANPUR

TITLE
TENDER DRAWING
HVAC LAYOUT
FIRST FLOOR PLAN

HSCC/D&E/HVAC/UP-SHAHJAHANPUR/AC-02
Rev. - 01

Job No.	1:150 Scale	JUNE 12, 2013 Date
---------	----------------	-----------------------

App by	Rev. by	Prep. by
--------	---------	----------

HSCC (INDIA) LIMITED
(A GOVERNMENT OF INDIA ENTERPRISES)
HSCC
NEW DELHI INDIA

PRODUCED BY AN AUTODESK EDUCATIONAL PRODUCT


This drawing with all its contents is the sole intellectual property of the Hospital Services Consultancy Corporation (India) Ltd. Copying of this drawing or part thereof or its use in any form whatsoever without the written permission of HSCC is prohibited.

NOTES

1. DRAWINGS TO BE READ NOT MEASURED
2. PARTITION WALL IN TOILETS UP TO LINTEL HEIGHT

DOOR / WINDOW SCHEDULE

S.NO.	TYPE	WIDTH	CILL	LINTEL
1	D	2000	—	2100
2	D1	1000	—	2100
3	D2	1500	—	2100
4	FD3	1200	—	2250
5	D4	800	—	2100
6	D5	750	—	2100
7	DW1	2200	—	2900
8	W	2000	900	2600
9	W1	1800	900	2600
10	W2	1500	900	2600
11	W3	1200	900	2600
12	W4	1000	900	2600
13	W5	830	900	2600
14	W6	2400	900	2600
15	V1	900	1700	2600
16	V2	600	1700	2600
17	V3	750	1700	2600

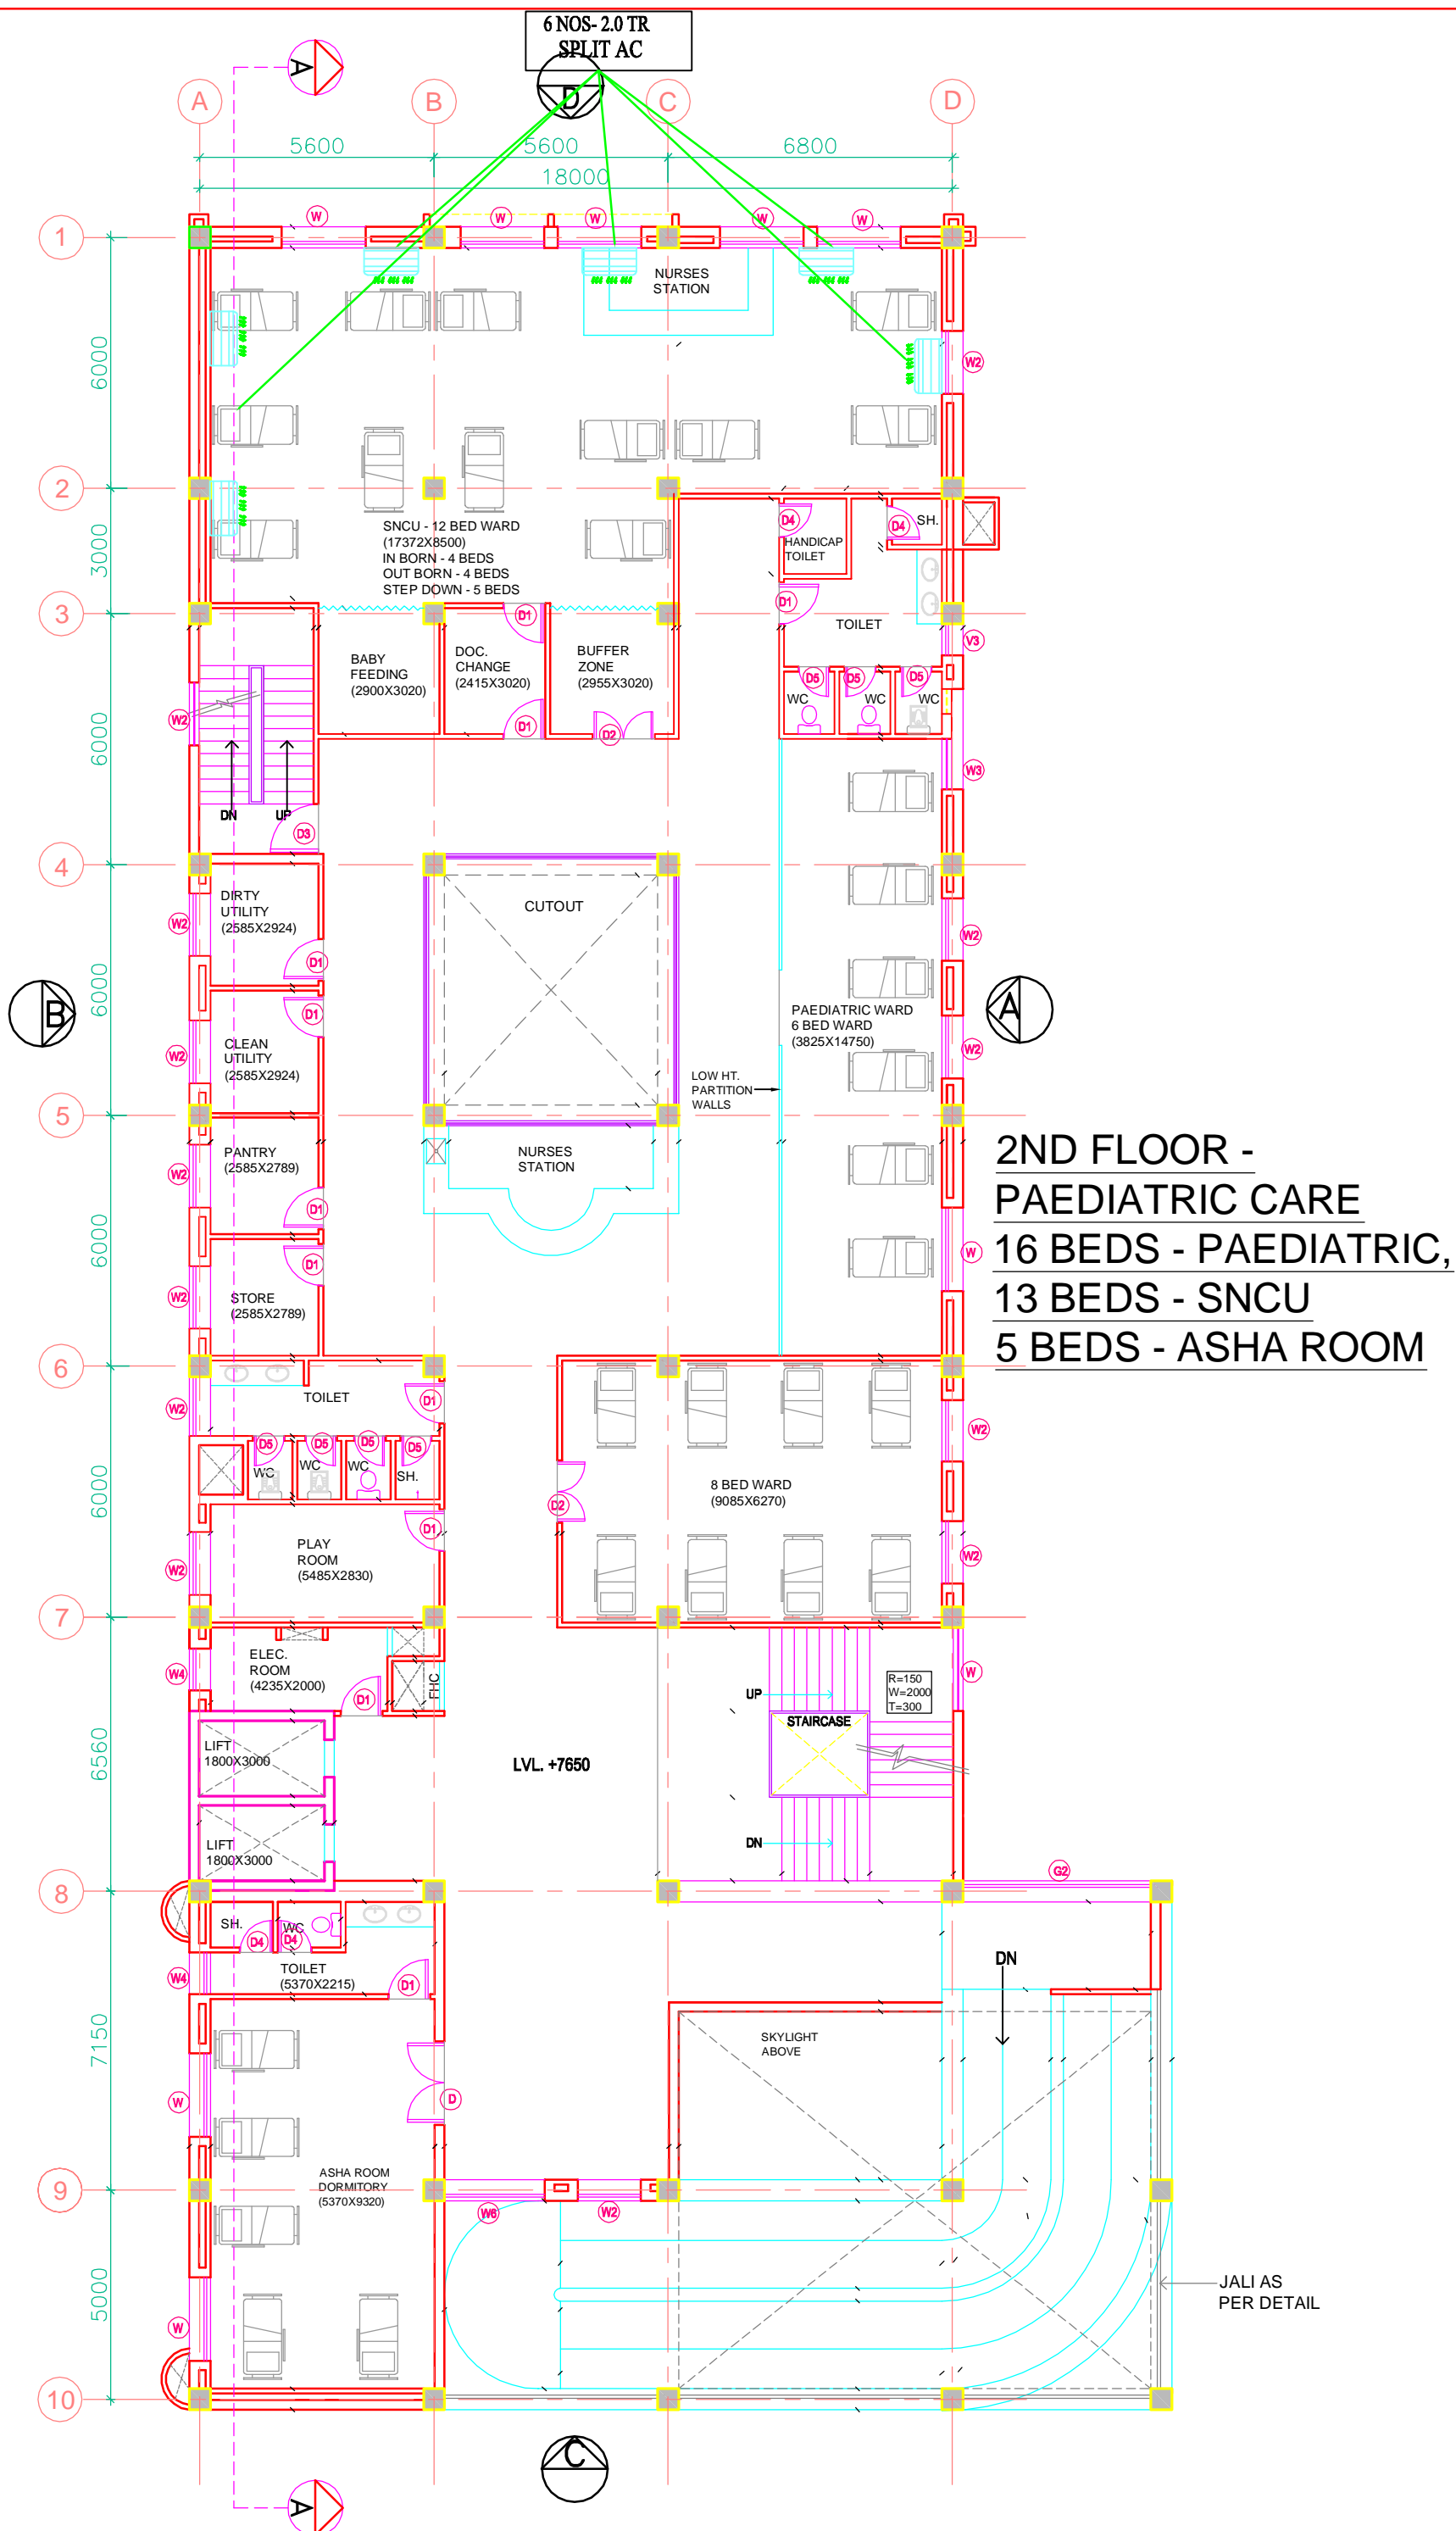

**2ND FLOOR -
PAEDIATRIC CARE**
16 BEDS - PAEDIATRIC,
13 BEDS - SNCU
5 BEDS - ASHA ROOM

REVISION - 01
REVISED AS PER THE GUIDELINES OF VETTING COMMITTEE

PROJECT
PROPOSED
100 BEDDED HOSPITAL
SHAHJAHANPUR

TITLE
TENDER DRAWING
HVAC LAYOUT
SECOND FLOOR PLAN

HSCC/D&E/HVAC/UP-SHAHJAHANPUR/AC-03
Rev. - 01

Job No.	1:150 Scale	JUNE 12, 2013 Date
---------	----------------	-----------------------

App by	Rev. by	Prep. by
--------	---------	----------

HSCC (INDIA) LIMITED
(A GOVERNMENT OF INDIA ENTERPRISES)
HSCC
NEW DELHI INDIA

PRODUCED BY AN AUTODESK EDUCATIONAL PRODUCT


This drawing with all its contents is the sole intellectual property of the Hospital Services Consultancy Corporation (India) Ltd. Copying of this drawing or part thereof or its use in any form whatsoever without the written permission of HSCC is prohibited.

NOTES

1. DRAWINGS TO BE READ NOT MEASURED
2. PARTITION WALL IN TOILETS UP TO LINTEL HEIGHT

DOOR / WINDOW SCHEDULE

S.NO.	TYPE	WIDTH	CILL	LINTEL
1	D	2000	—	2100
2	D1	1000	—	2100
3	D2	1500	—	2100
4	FD3	1200	—	2250
5	D4	800	—	2100
6	D5	750	—	2100
7	DW1	2200	—	2900
8	W	2000	900	2600
9	W1	1800	900	2600
10	W2	1500	900	2600
11	W3	1200	900	2600
12	W4	1000	900	2600
13	W5	830	900	2600
14	W6	2400	900	2600
15	V1	900	1700	2600
16	V2	600	1700	2600
17	V3	750	1700	2600

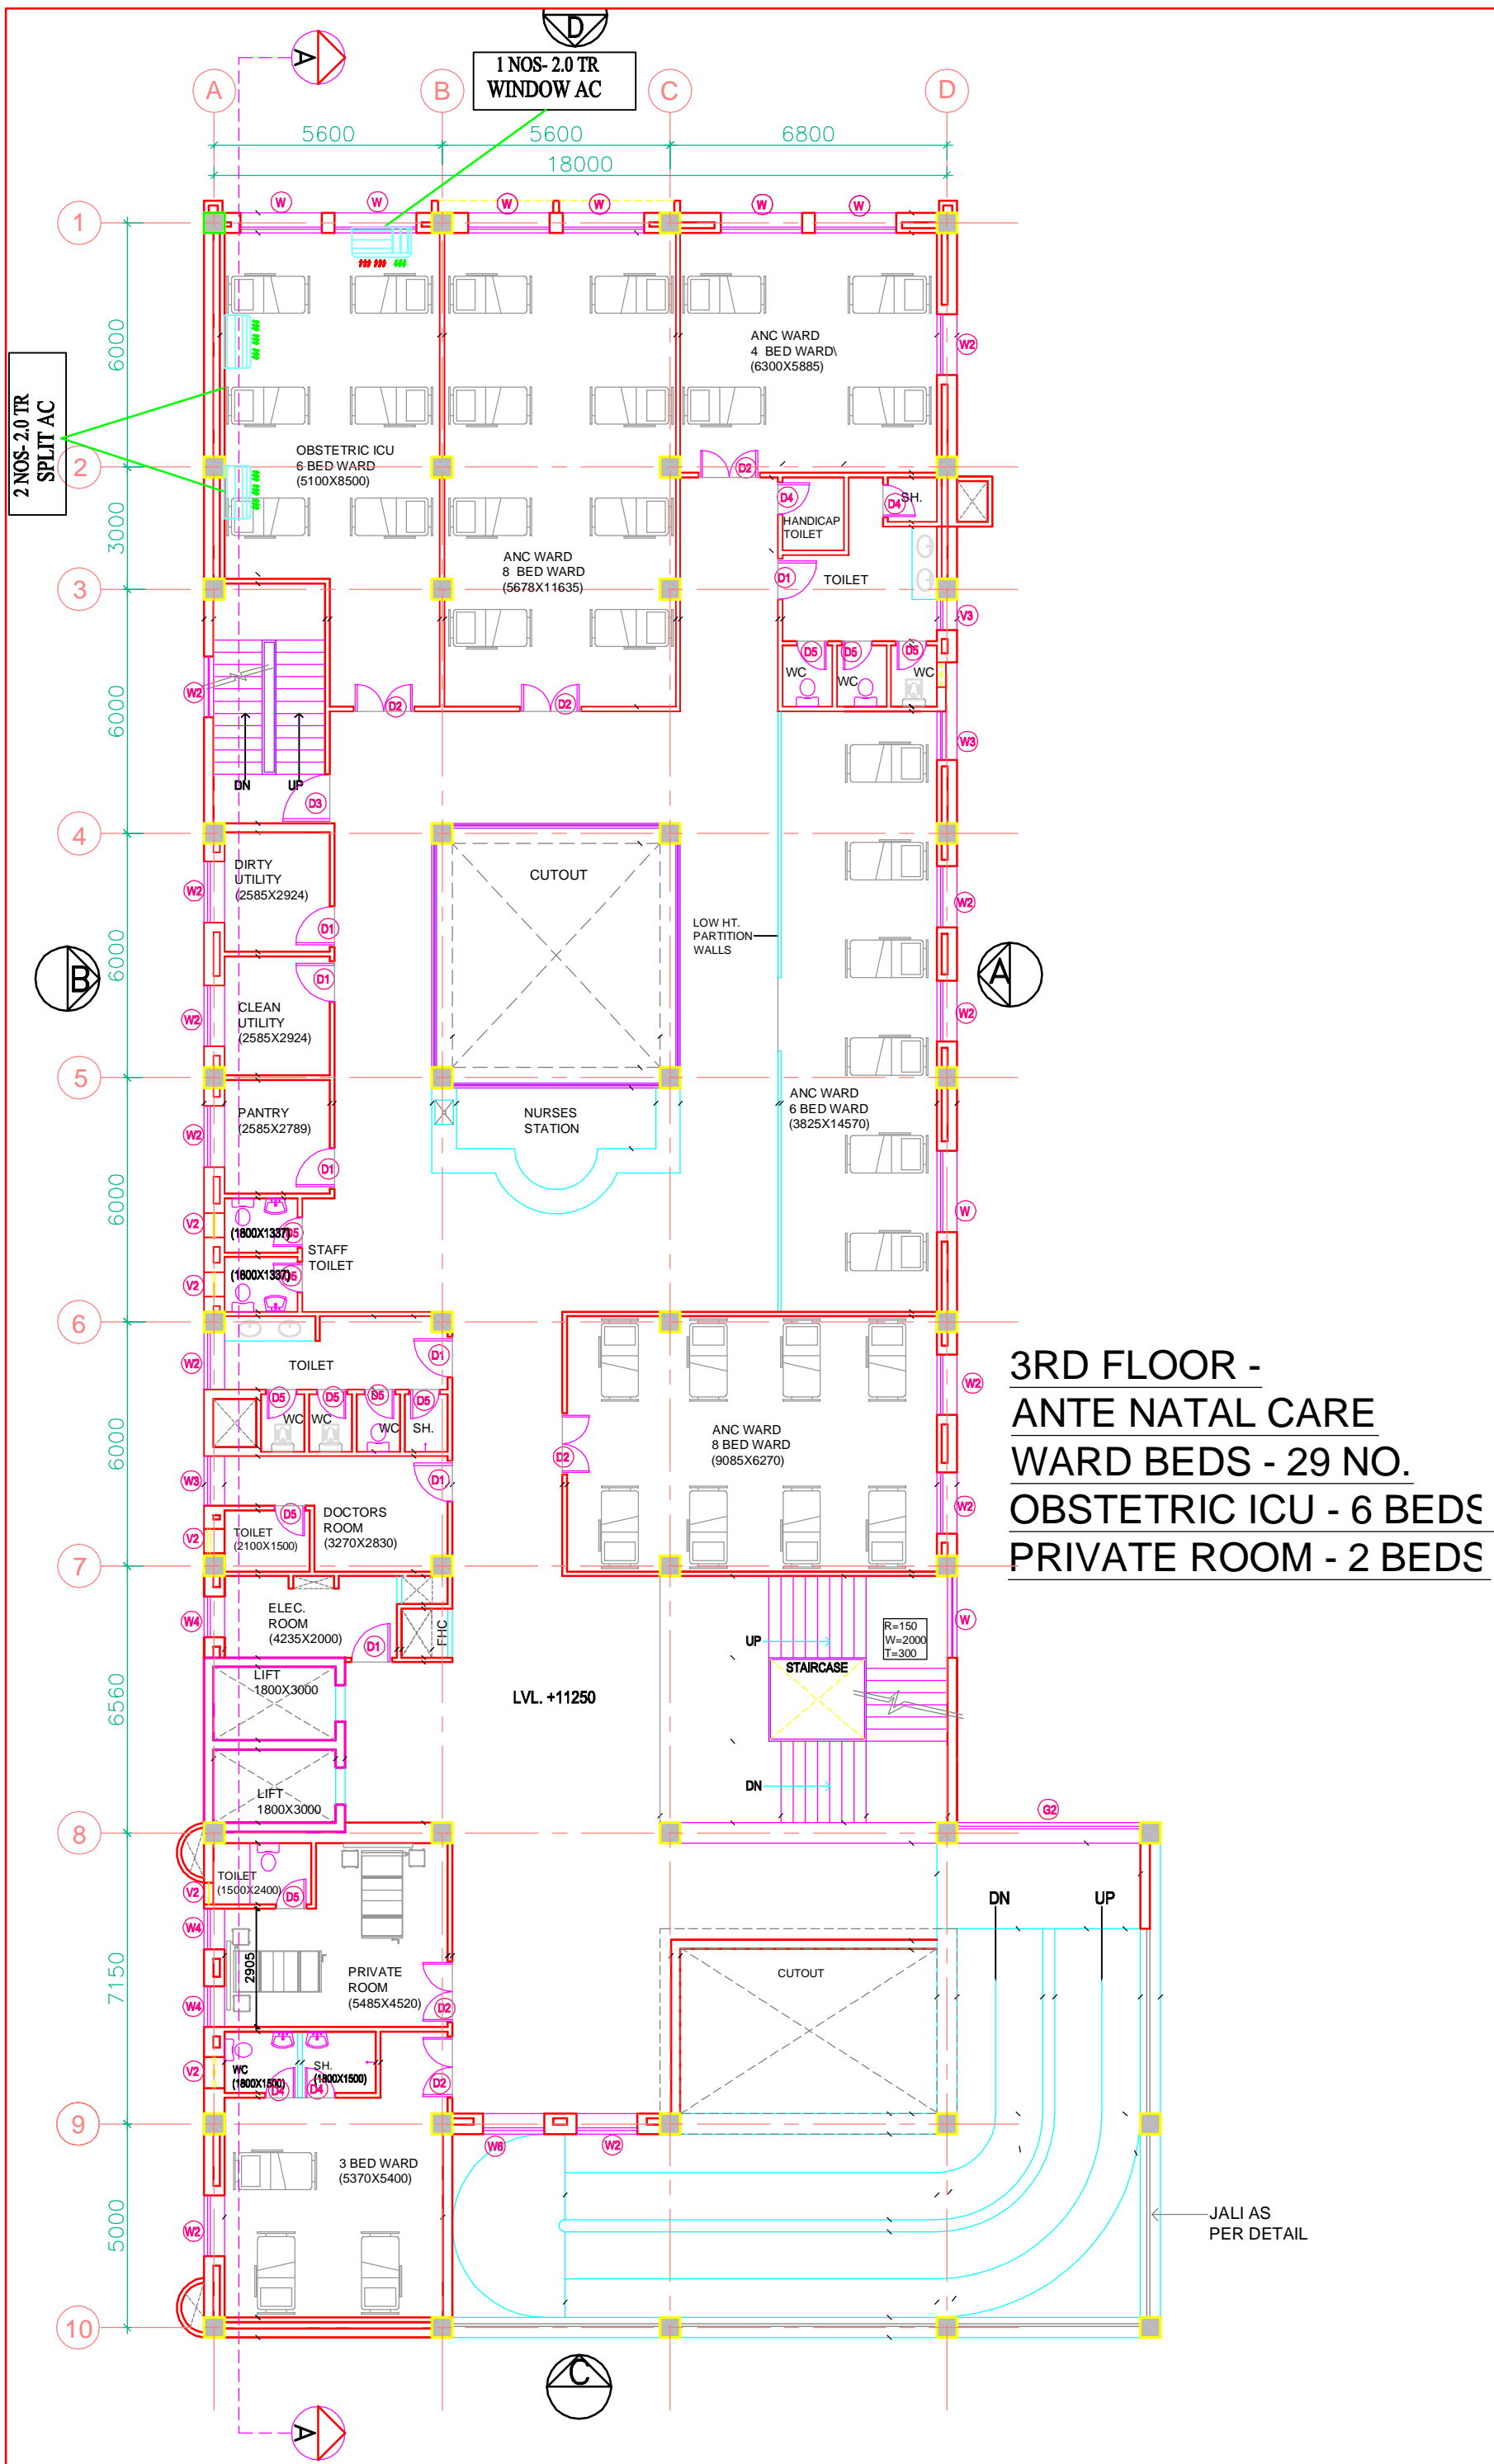

3RD FLOOR - ANTE NATAL CARE
WARD BEDS - 29 NO.
OBSTETRIC ICU - 6 BEDS
PRIVATE ROOM - 2 BEDS

REVISION - 01
 REVISED AS PER THE GUIDELINES OF VETTING COMMITTEE

PROJECT
 PROPOSED 100 BEDDED HOSPITAL
 SHAHJAHANPUR

TITLE
 TENDER DRAWING
 HVAC LAYOUT
 THIRD FLOOR PLAN

HSCC/D&E/HVAC/UP-SHAHJAHANPUR/AC-04
 Rev. - 01

Job No.	1:150 Scale	JUNE 12, 2013 Date
---------	----------------	-----------------------

App by	Rev. by	Prep. by
--------	---------	----------

HSCC (INDIA) LIMITED
 (A GOVERNMENT OF INDIA ENTERPRISES)
HSCC
 NEW DELHI INDIA

PRODUCED BY AN AUTODESK EDUCATIONAL PRODUCT


This drawing with all its contents is the sole intellectual property of the Hospital Services Consultancy Corporation (India) Ltd. Copying of this drawing or part thereof or its use in any form whatsoever without the written permission of HSCC is prohibited.

NOTES

1. DRAWINGS TO BE READ NOT MEASURED
2. PARTITION WALL IN TOILETS UP TO LINTEL HEIGHT

DOOR / WINDOW SCHEDULE

S.NO.	TYPE	WIDTH	CILL	LINTEL
1	D	2000	—	2100
2	D1	1000	—	2100
3	D2	1500	—	2100
4	FD3	1200	—	2250
5	D4	800	—	2100
6	D5	750	—	2100
7	DW1	2200	—	2900
8	W	2000	900	2600
9	W1	1800	900	2600
10	W2	1500	900	2600
11	W3	1200	900	2600
12	W4	1000	900	2600
13	W5	830	900	2600
14	W6	2400	900	2600
15	V1	900	1700	2600
16	V2	600	1700	2600
17	V3	750	1700	2600

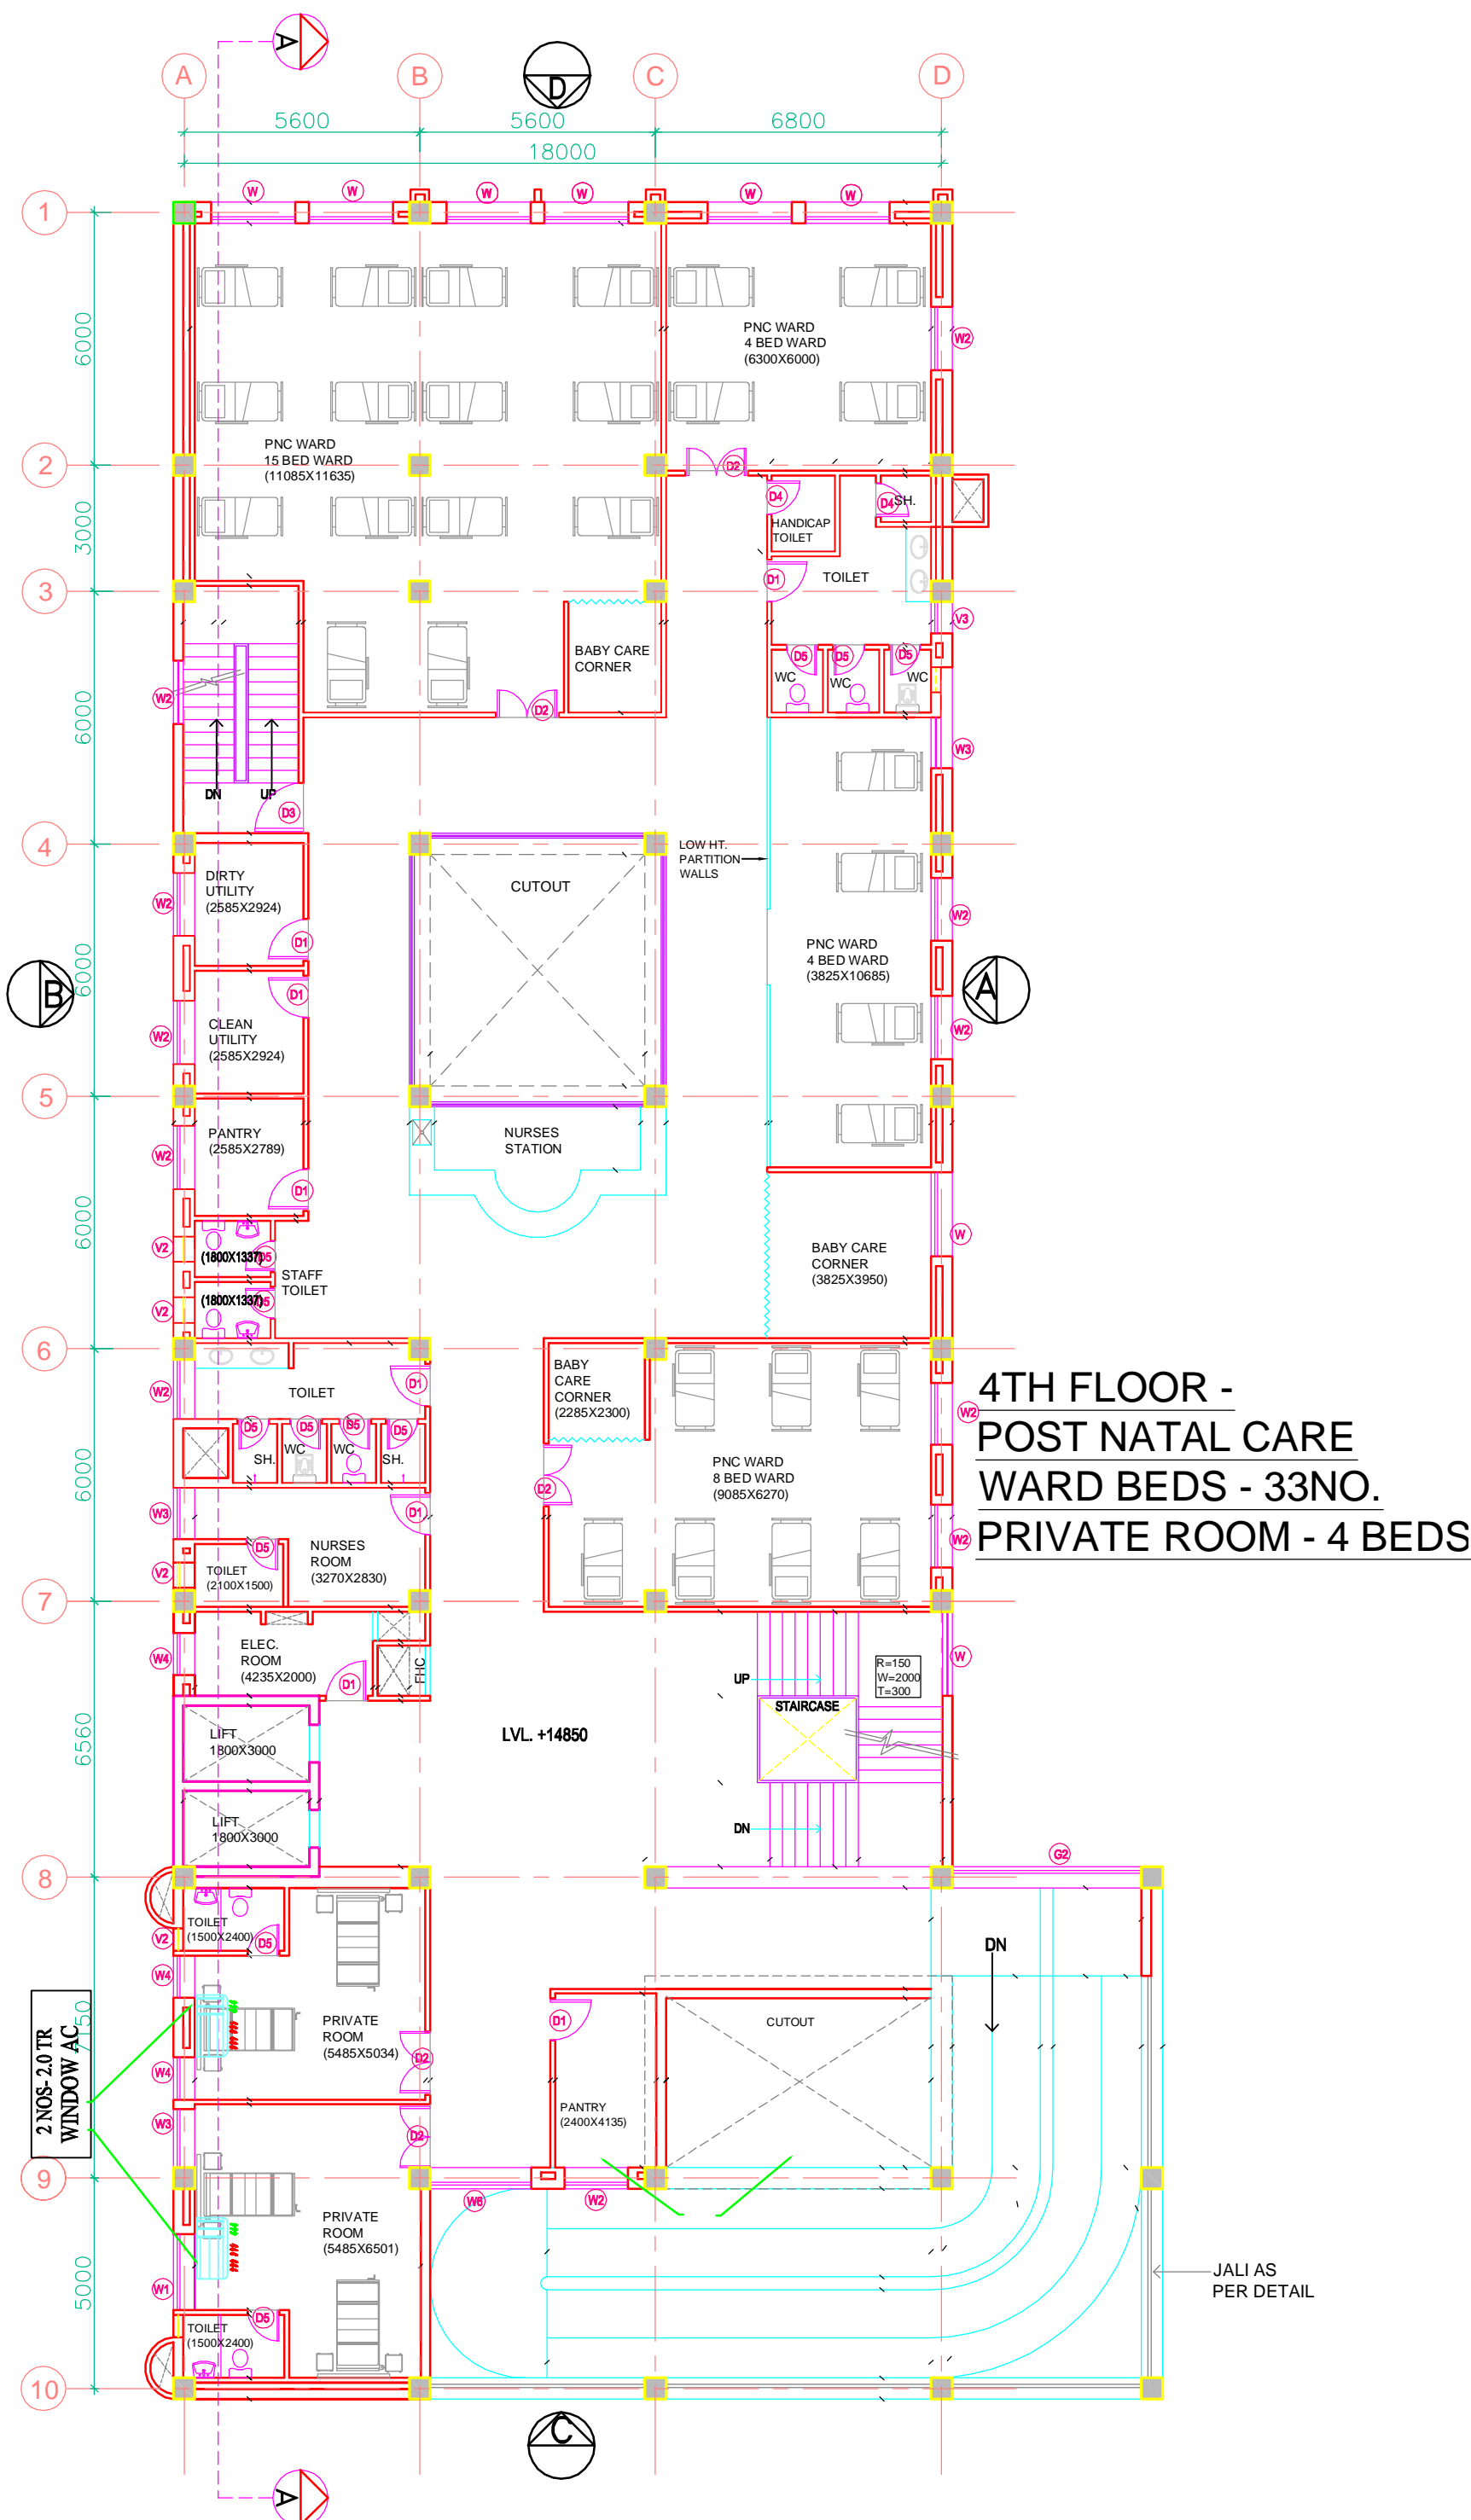

**4TH FLOOR -
POST NATAL CARE
WARD BEDS - 33NO.
PRIVATE ROOM - 4 BEDS**

REVISION - 01
REVISED AS PER THE GUIDELINES OF VETTING COMMITTEE

PROJECT
PROPOSED
100 BEDDED HOSPITAL
SHAHJAHANPUR

TITLE
TENDER DRAWING
HVAC LAYOUT
FOURTH FLOOR PLAN

HSCC/D&E/HVAC/UP-SHAHJAHANPUR/AC-0-5
Rev. - 01

Job No.	1:150 Scale	JUNE 12,2013 Date
---------	----------------	----------------------

App by	Rev. by	Prep. by
--------	---------	----------

HSCC (INDIA) LIMITED
(A GOVERNMENT OF INDIA ENTERPRISES)
HSCC
NEW DELHI INDIA

PRODUCED BY AN AUTODESK EDUCATIONAL PRODUCT


This drawing with all its contents is the sole intellectual property of the Hospital Services Consultancy Corporation (India) Ltd. Copying of this drawing or part thereof or its use in any form whatsoever without the written permission of HSCC is prohibited.

NOTES

1. DRAWINGS TO BE READ NOT MEASURED
2. PARTITION WALL IN TOILETS UP TO LINTEL HEIGHT

DOOR / WINDOW SCHEDULE

S.NO.	TYPE	WIDTH	CILL	LINTEL
1	D	2000	—	2100
2	D1	1000	—	2100
3	D2	1500	—	2100
4	FD3	1200	—	2250
5	D4	800	—	2100
6	D5	750	—	2100
7	DW1	2200	—	2900
8	W	2000	900	2600
9	W1	1800	900	2600
10	W2	1500	900	2600
11	W3	1200	900	2600
12	W4	1000	900	2600
13	W5	830	900	2600
14	W6	2400	900	2600
15	V1	900	1700	2600
16	V2	600	1700	2600
17	V3	750	1700	2600

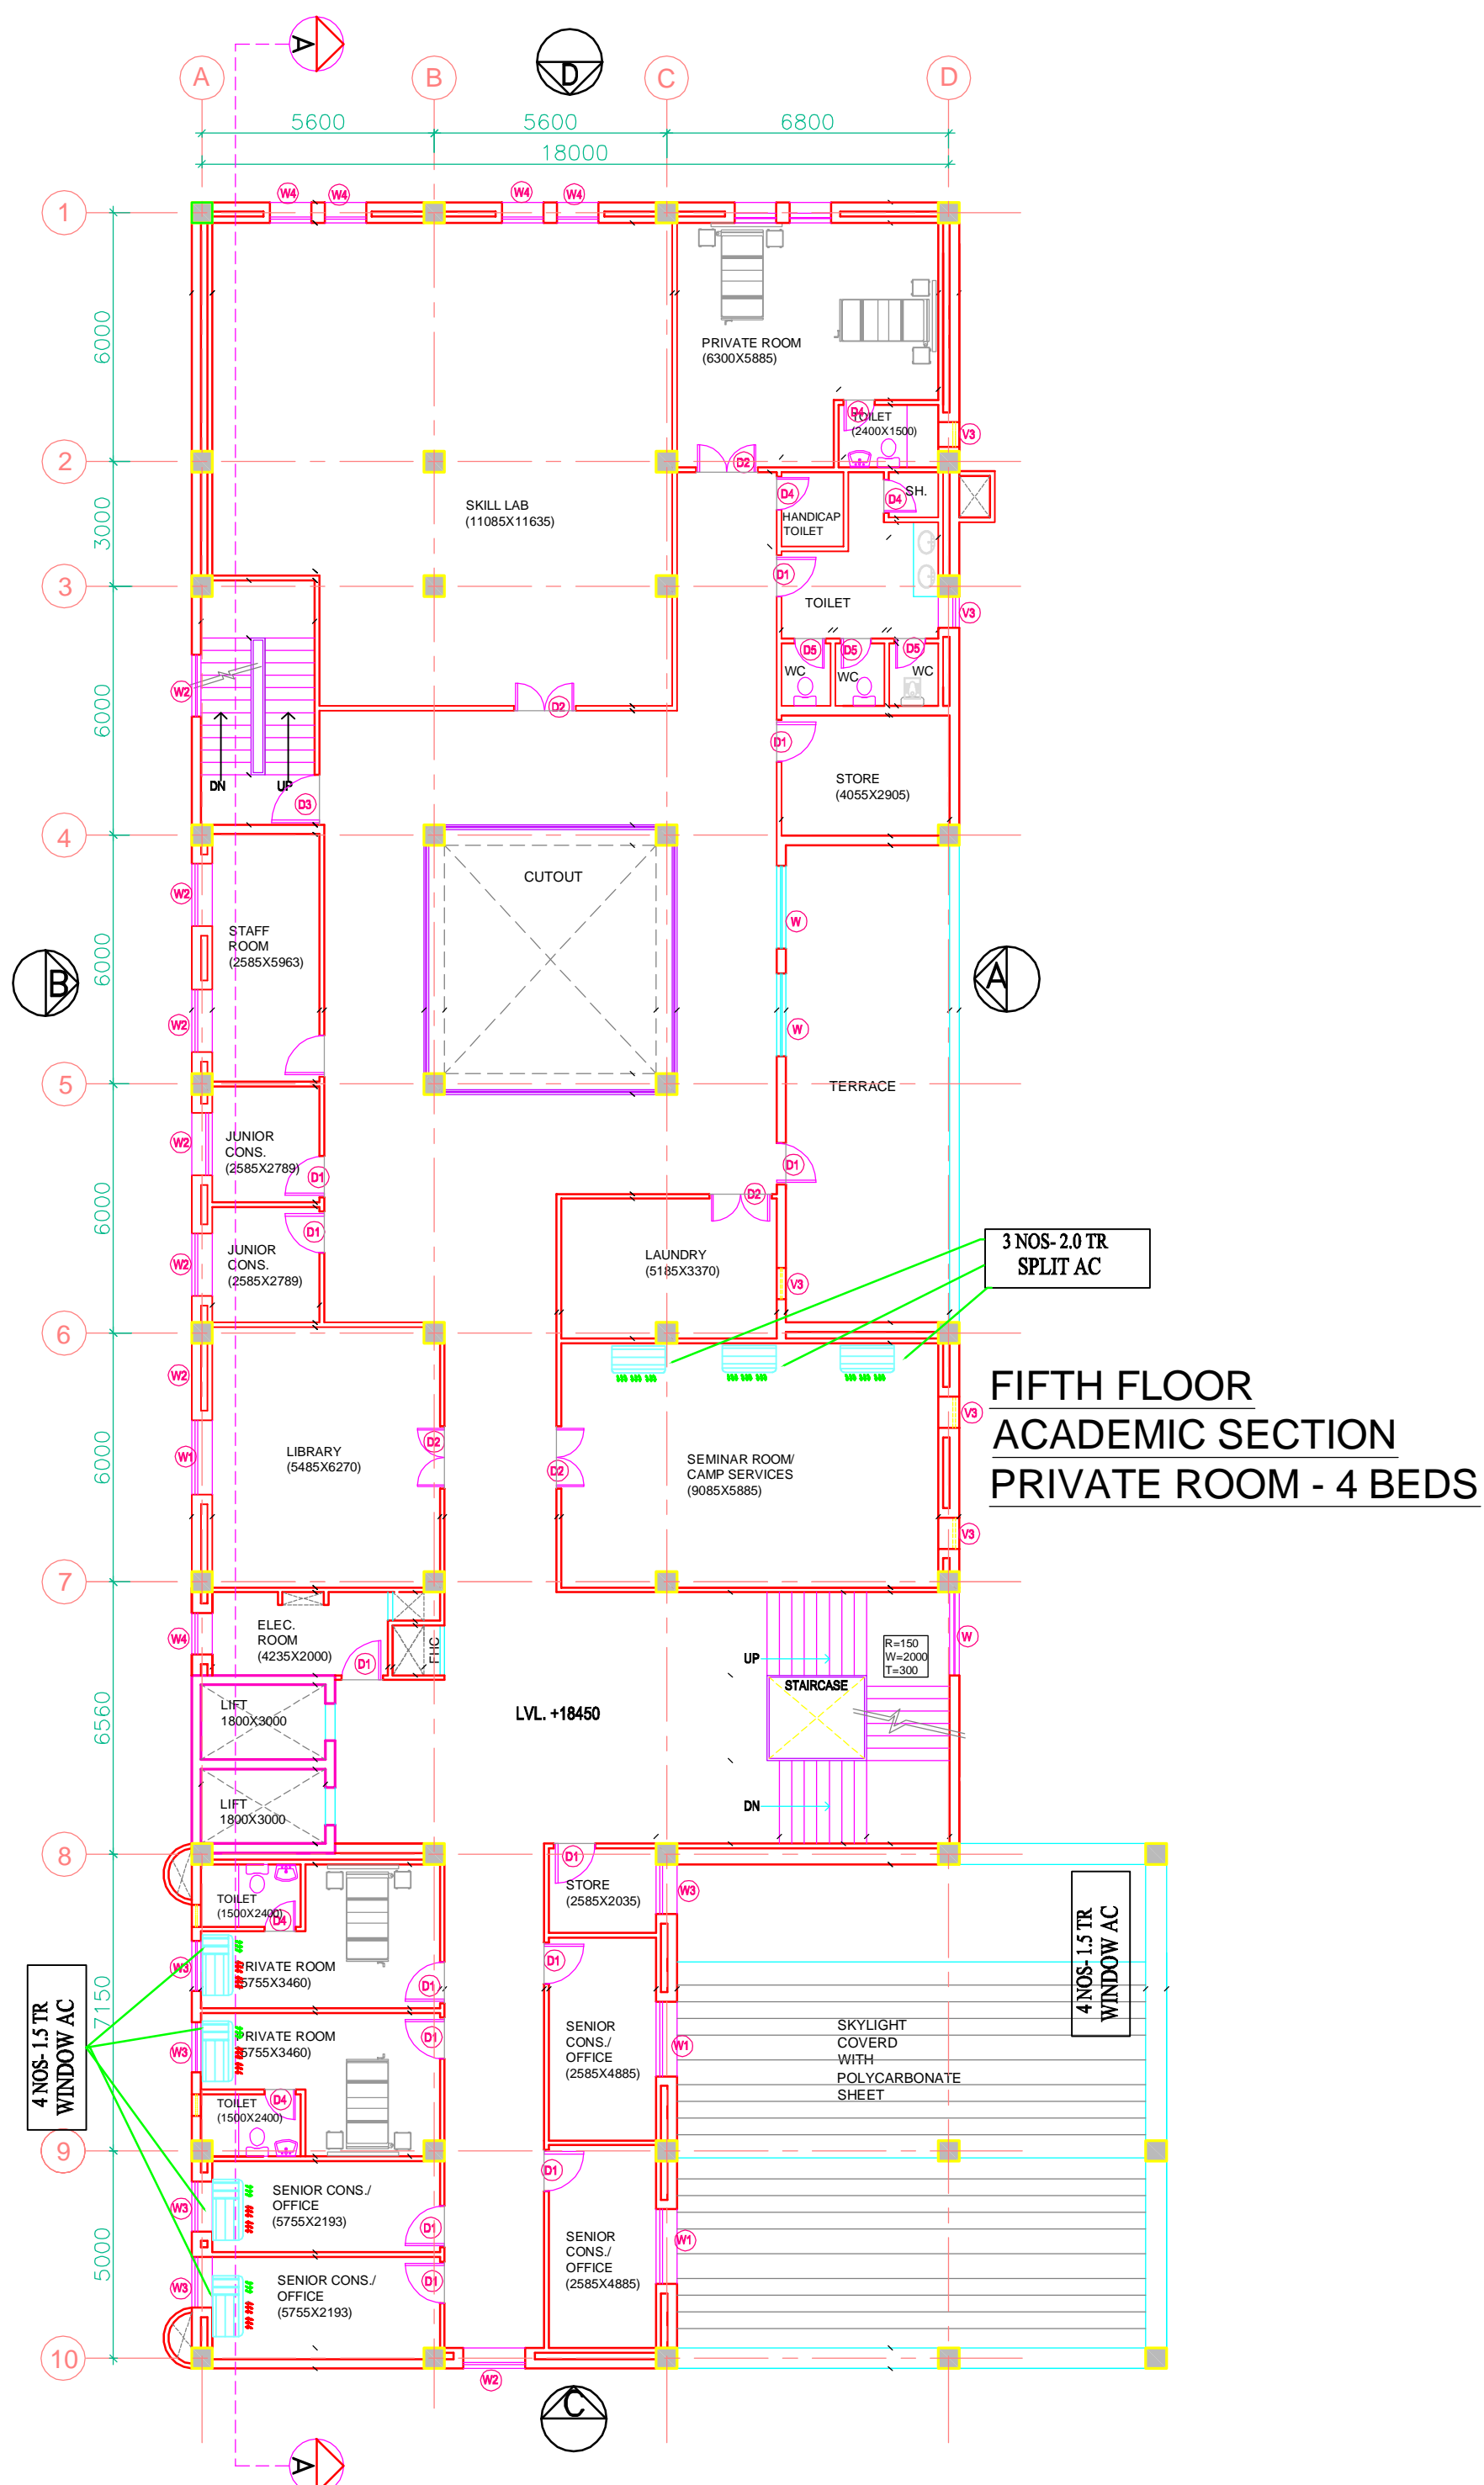

**FIFTH FLOOR
ACADEMIC SECTION
PRIVATE ROOM - 4 BEDS**

REVISION - 01
REVISED AS PER THE GUIDELINES OF VETTING COMMITTEE

PROJECT
PROPOSED
100 BEDDED HOSPITAL
SHAHJAHANPUR

TITLE
TENDER DRAWING
HVAC LAYOUT
FIFTH FLOOR PLAN

HSCC/D&E/HVAC/UP-SHAHJAHANPUR/AC-06
Rev. - 01

Job No. 1:150 Scale JUNE 12, 2013 Date

App by Rev. by Prep. by

PRODUCED BY AN AUTODESK EDUCATIONAL PRODUCT