


ELECTRICAL

DRAWINGS

This drawing with all its contents is the sole intellectual property of the HSCC (INDIA) LIMITED (a Government of India Enterprise) and no part hereof shall be reproduced or transmitted in any form or by any means, without the written permission of HSCC is prohibited.

NOTES

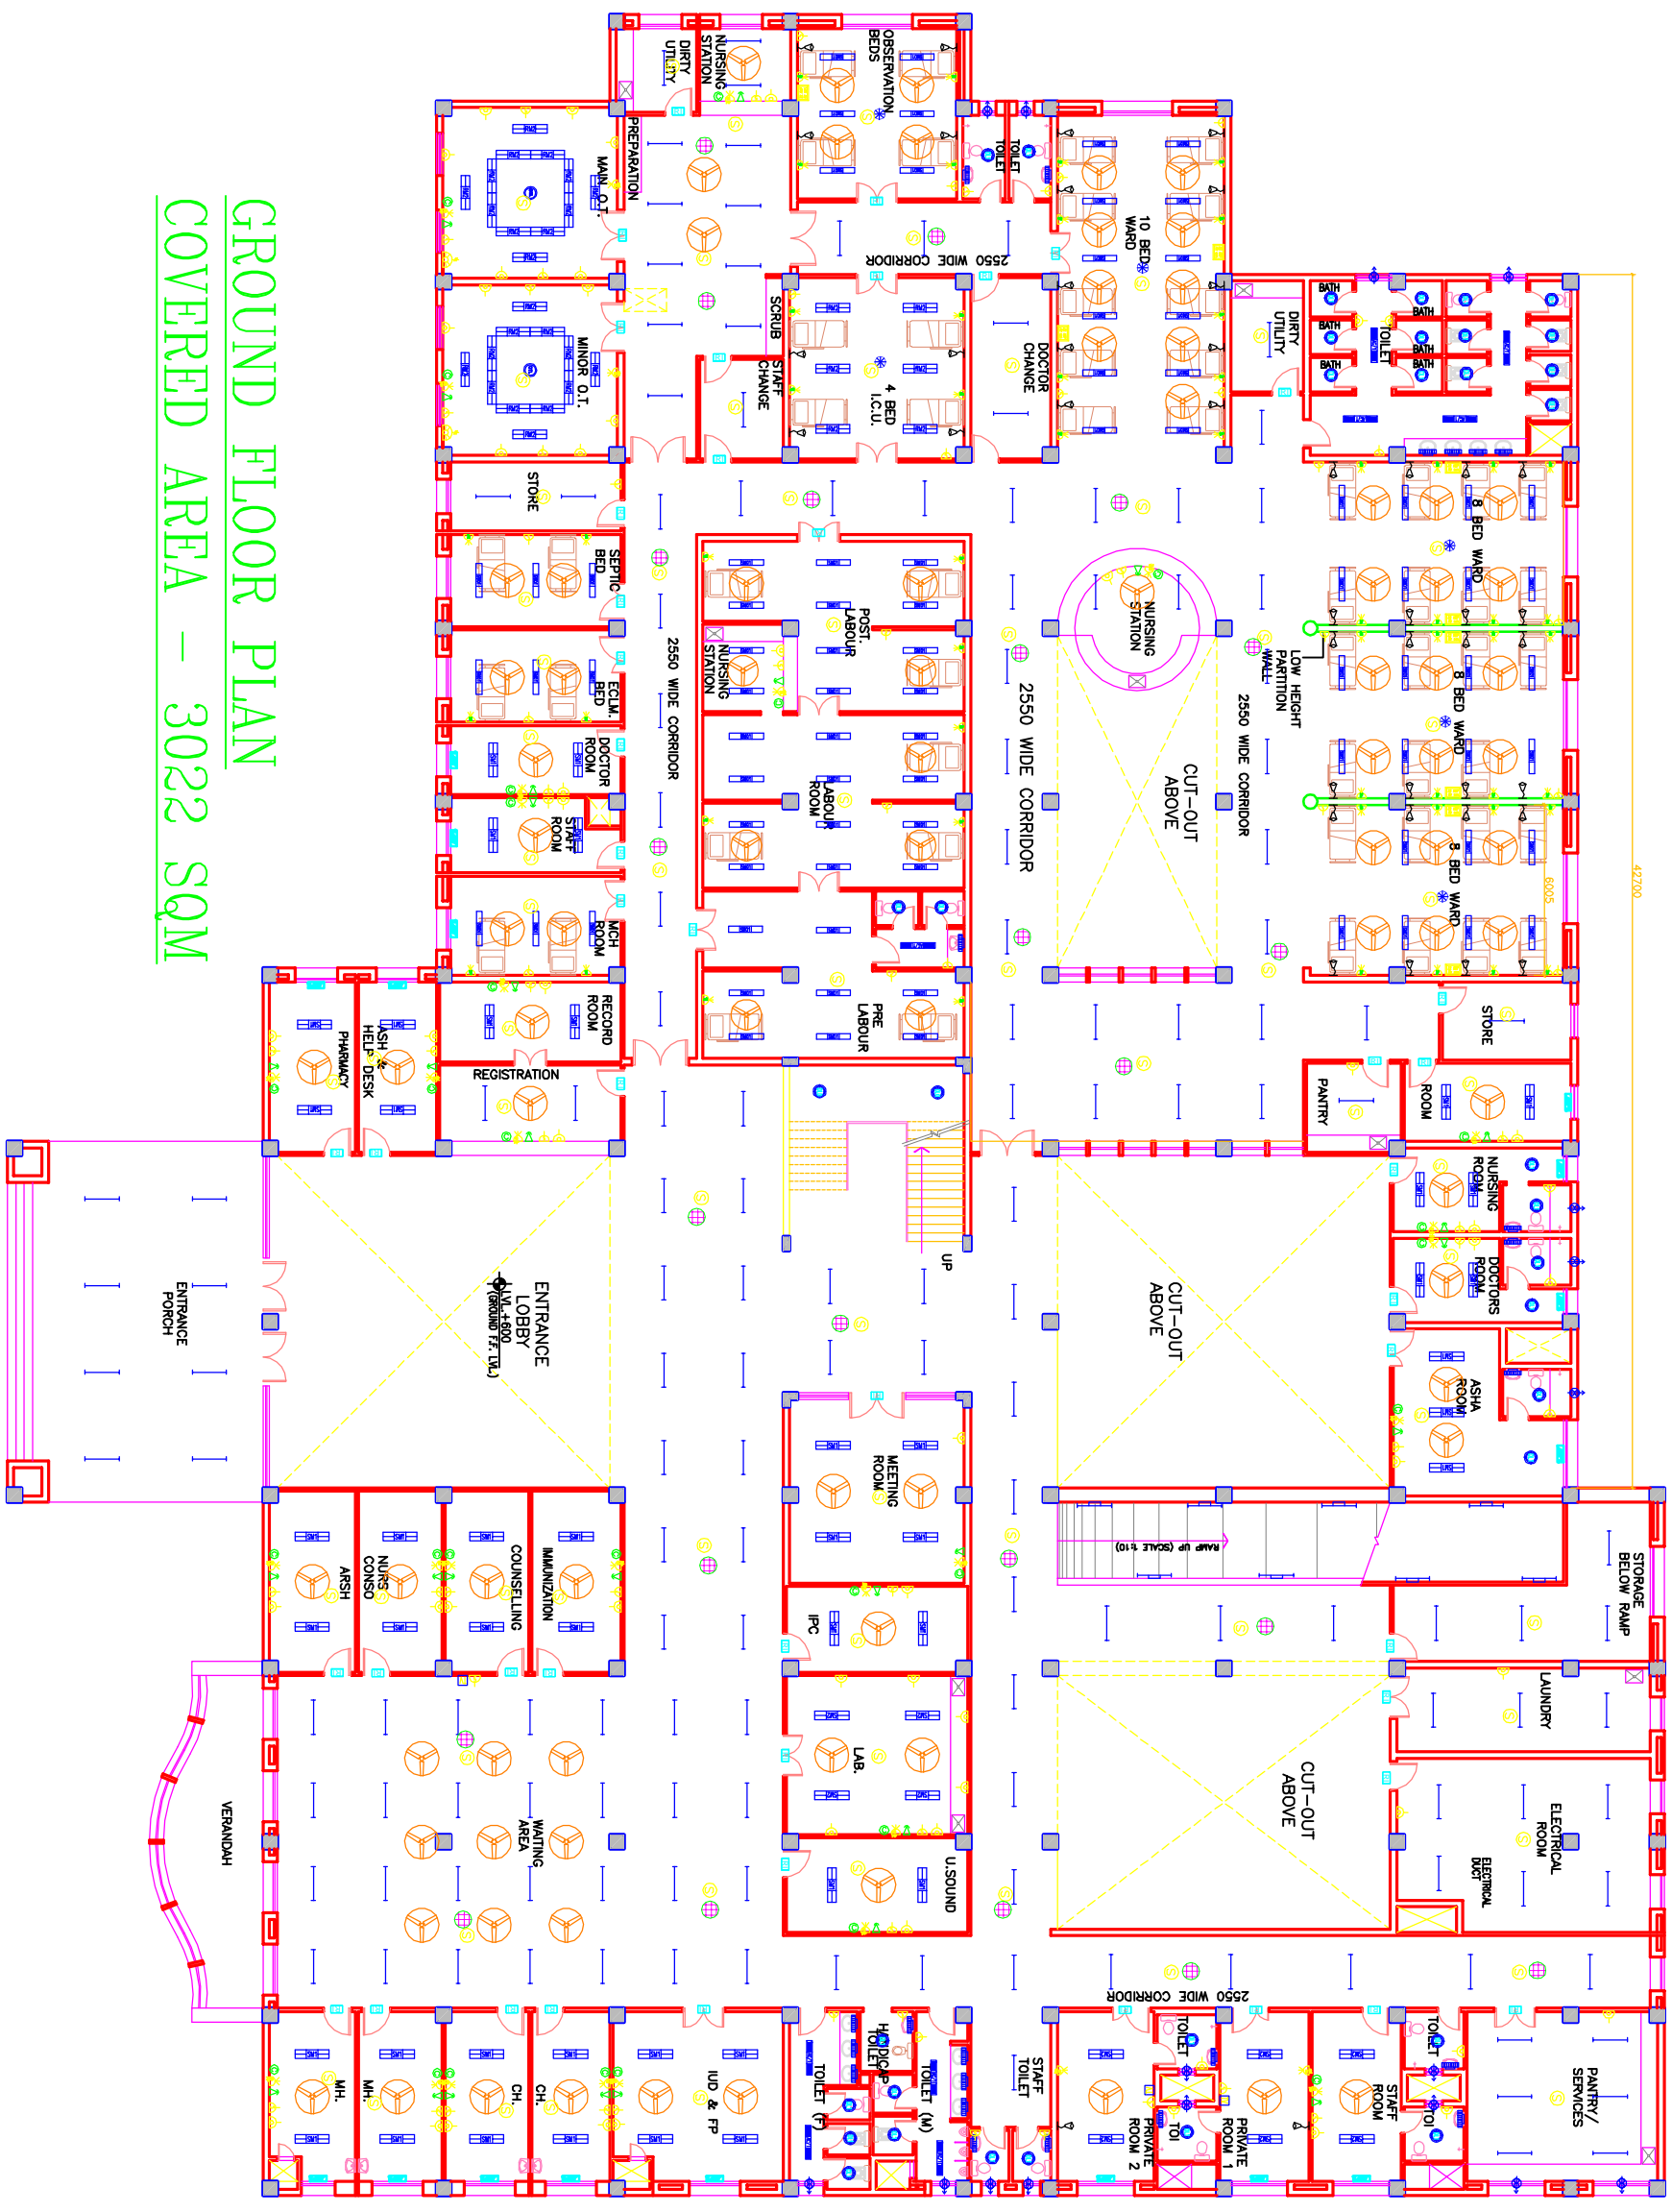


GROUND FLOOR PLAN
COVERED AREA - 3022 SQM

PROJECT		RMNCH PROJECT	
		Proposed 100 Bedded Hospital AT CHATTISGARH	
REV. DATE	DESCRIPTION		
TITLE			
MODEL PLANS			
GROUND FLOOR PLAN			
ELECTRICAL LAYOUT			
(COVERED AREA=3022 SQ. MT.)			
HSCC/EA&T/DEL-101			R-0
Drawing No.			Rev.
HSCC/-	NTS		
Job No.	Scale		Date
App by	Rev. by		Prep. by

This drawing with all its contents is the sole intellectual property of the HSCC (INDIA) LIMITED (A GOVERNMENT OF INDIA ENTERPRISE). Any use or part thereof for any purpose without the written permission of HSCC is prohibited.

NOTES

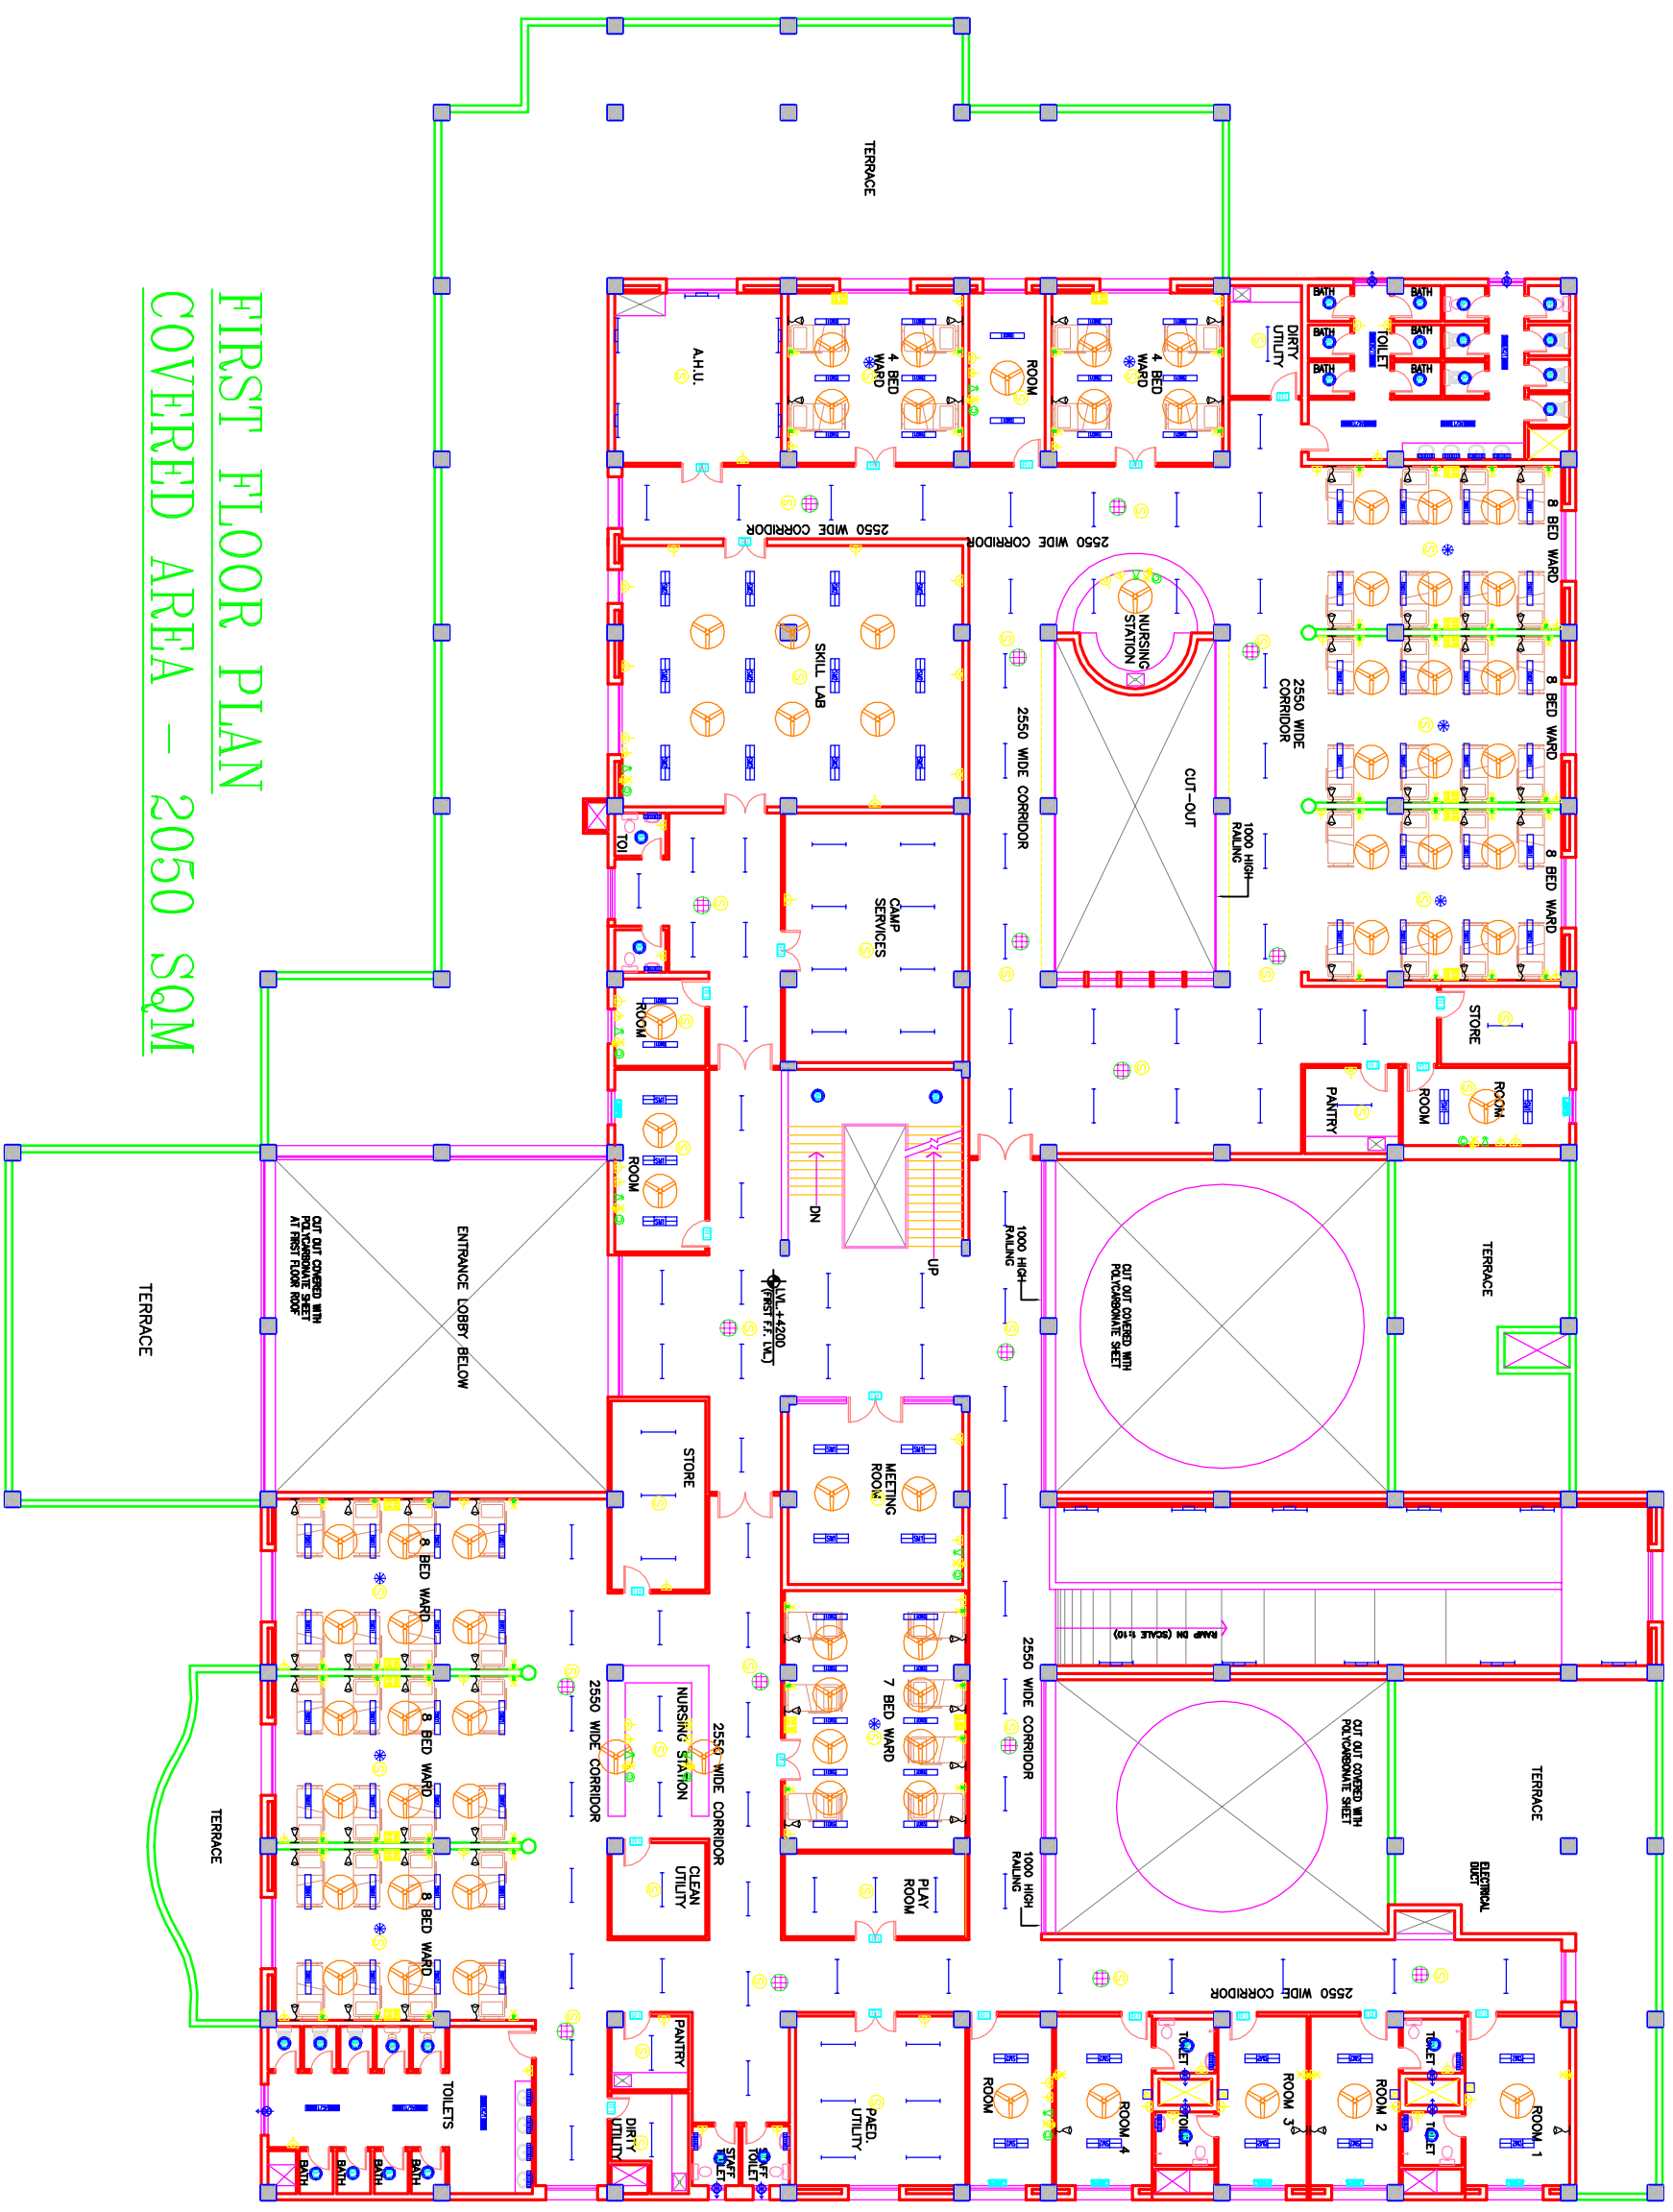


FIRST FLOOR PLAN
COVERED AREA – 2050 SQM

PROJECT		RMNCH PROJECT	
Proposed 100 Bedded Hospital AT CHATTISGARH			
TITLE		MODEL PLANS	
FIRST FLOOR PLAN		ELECTRICAL LAYOUT	
(COVERED AREA=2050 SQ. MT.)		HSCC/D&E/TD/DEL-102	
Drawing No.		R-0	
HSCC/—		N/S	
Job No.		Scale	
App by		Date	
Rev. by		Prep. by	

This drawing with all its contents is the sole Intellectual Property of the HSCC (INDIA) LIMITED (a Government of India Enterprise). Any use or part thereof without the written permission of HSCC is prohibited.

NOTES

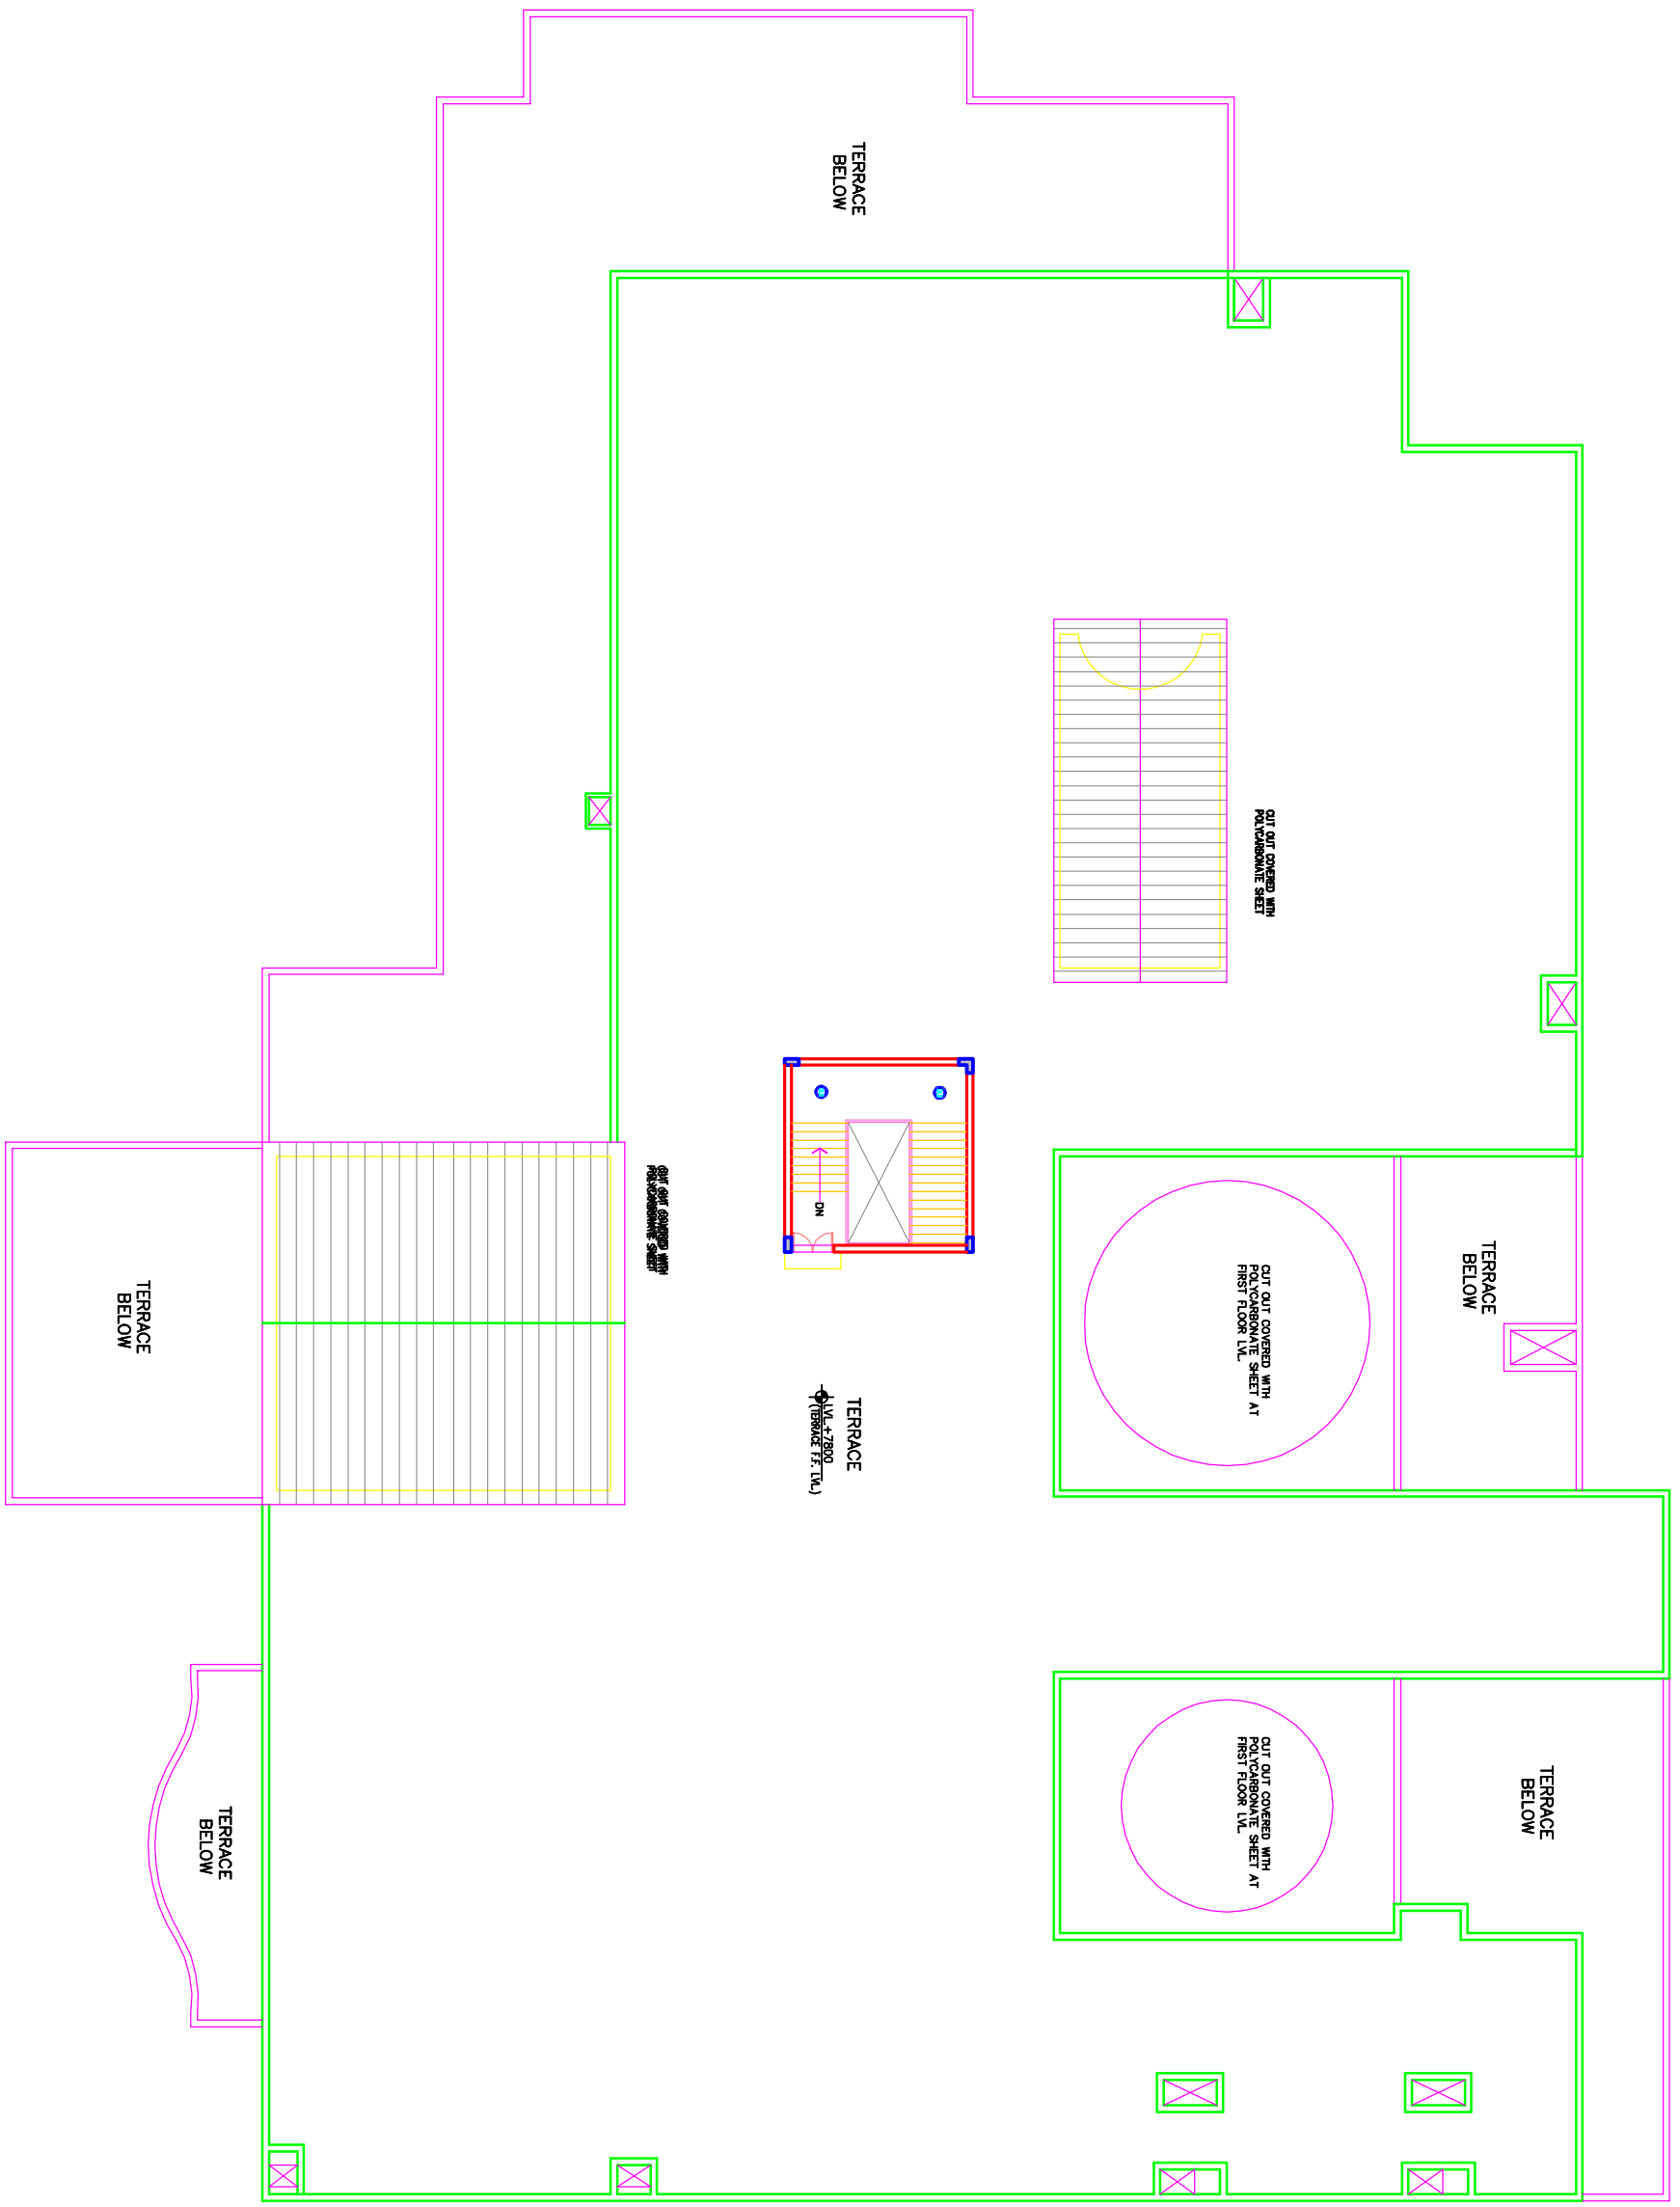

REV	DATE	DESCRIPTION

PROJECT

RMNCH PROJECT
Proposed
100 Bedded Hospital
AT
CHATTISGARH

TITLE

MODEL PLANS
TERRACE
PLAN
ELECTRICAL LAYOUT

HSCC/D&E/TD/DEL-103 R-0
Drawing No. Rev.

ISSC/- NTS
Job No. Scale Date

App by Rev. by Prep. by

HVAC
DRAWINGS



NOTES

The drawing with all its contents is the sole intellectual property of the Institute of Health Care Consultants (India) Ltd. Copying of this drawing or part thereof in any form or by any means without the written permission of IHC is prohibited.

REV	DATE	DESCRIPTION


PROJECT

Proposed
100 Bedded Hospital
At CHHATTISGARH

TITLE

TENDER DRAWING
GROUND FLOOR PLAN
HVAC LAYOUT
(COVERED AREA=3022 SQ. MT.)

ESCCDAEHTYAONRBNACQAC-01	R-0
Drawing No.	
BSQC/-	1:125
Job No.	Scale
	25-03-2013
Date	
App by	Rev. by
	Prep. by

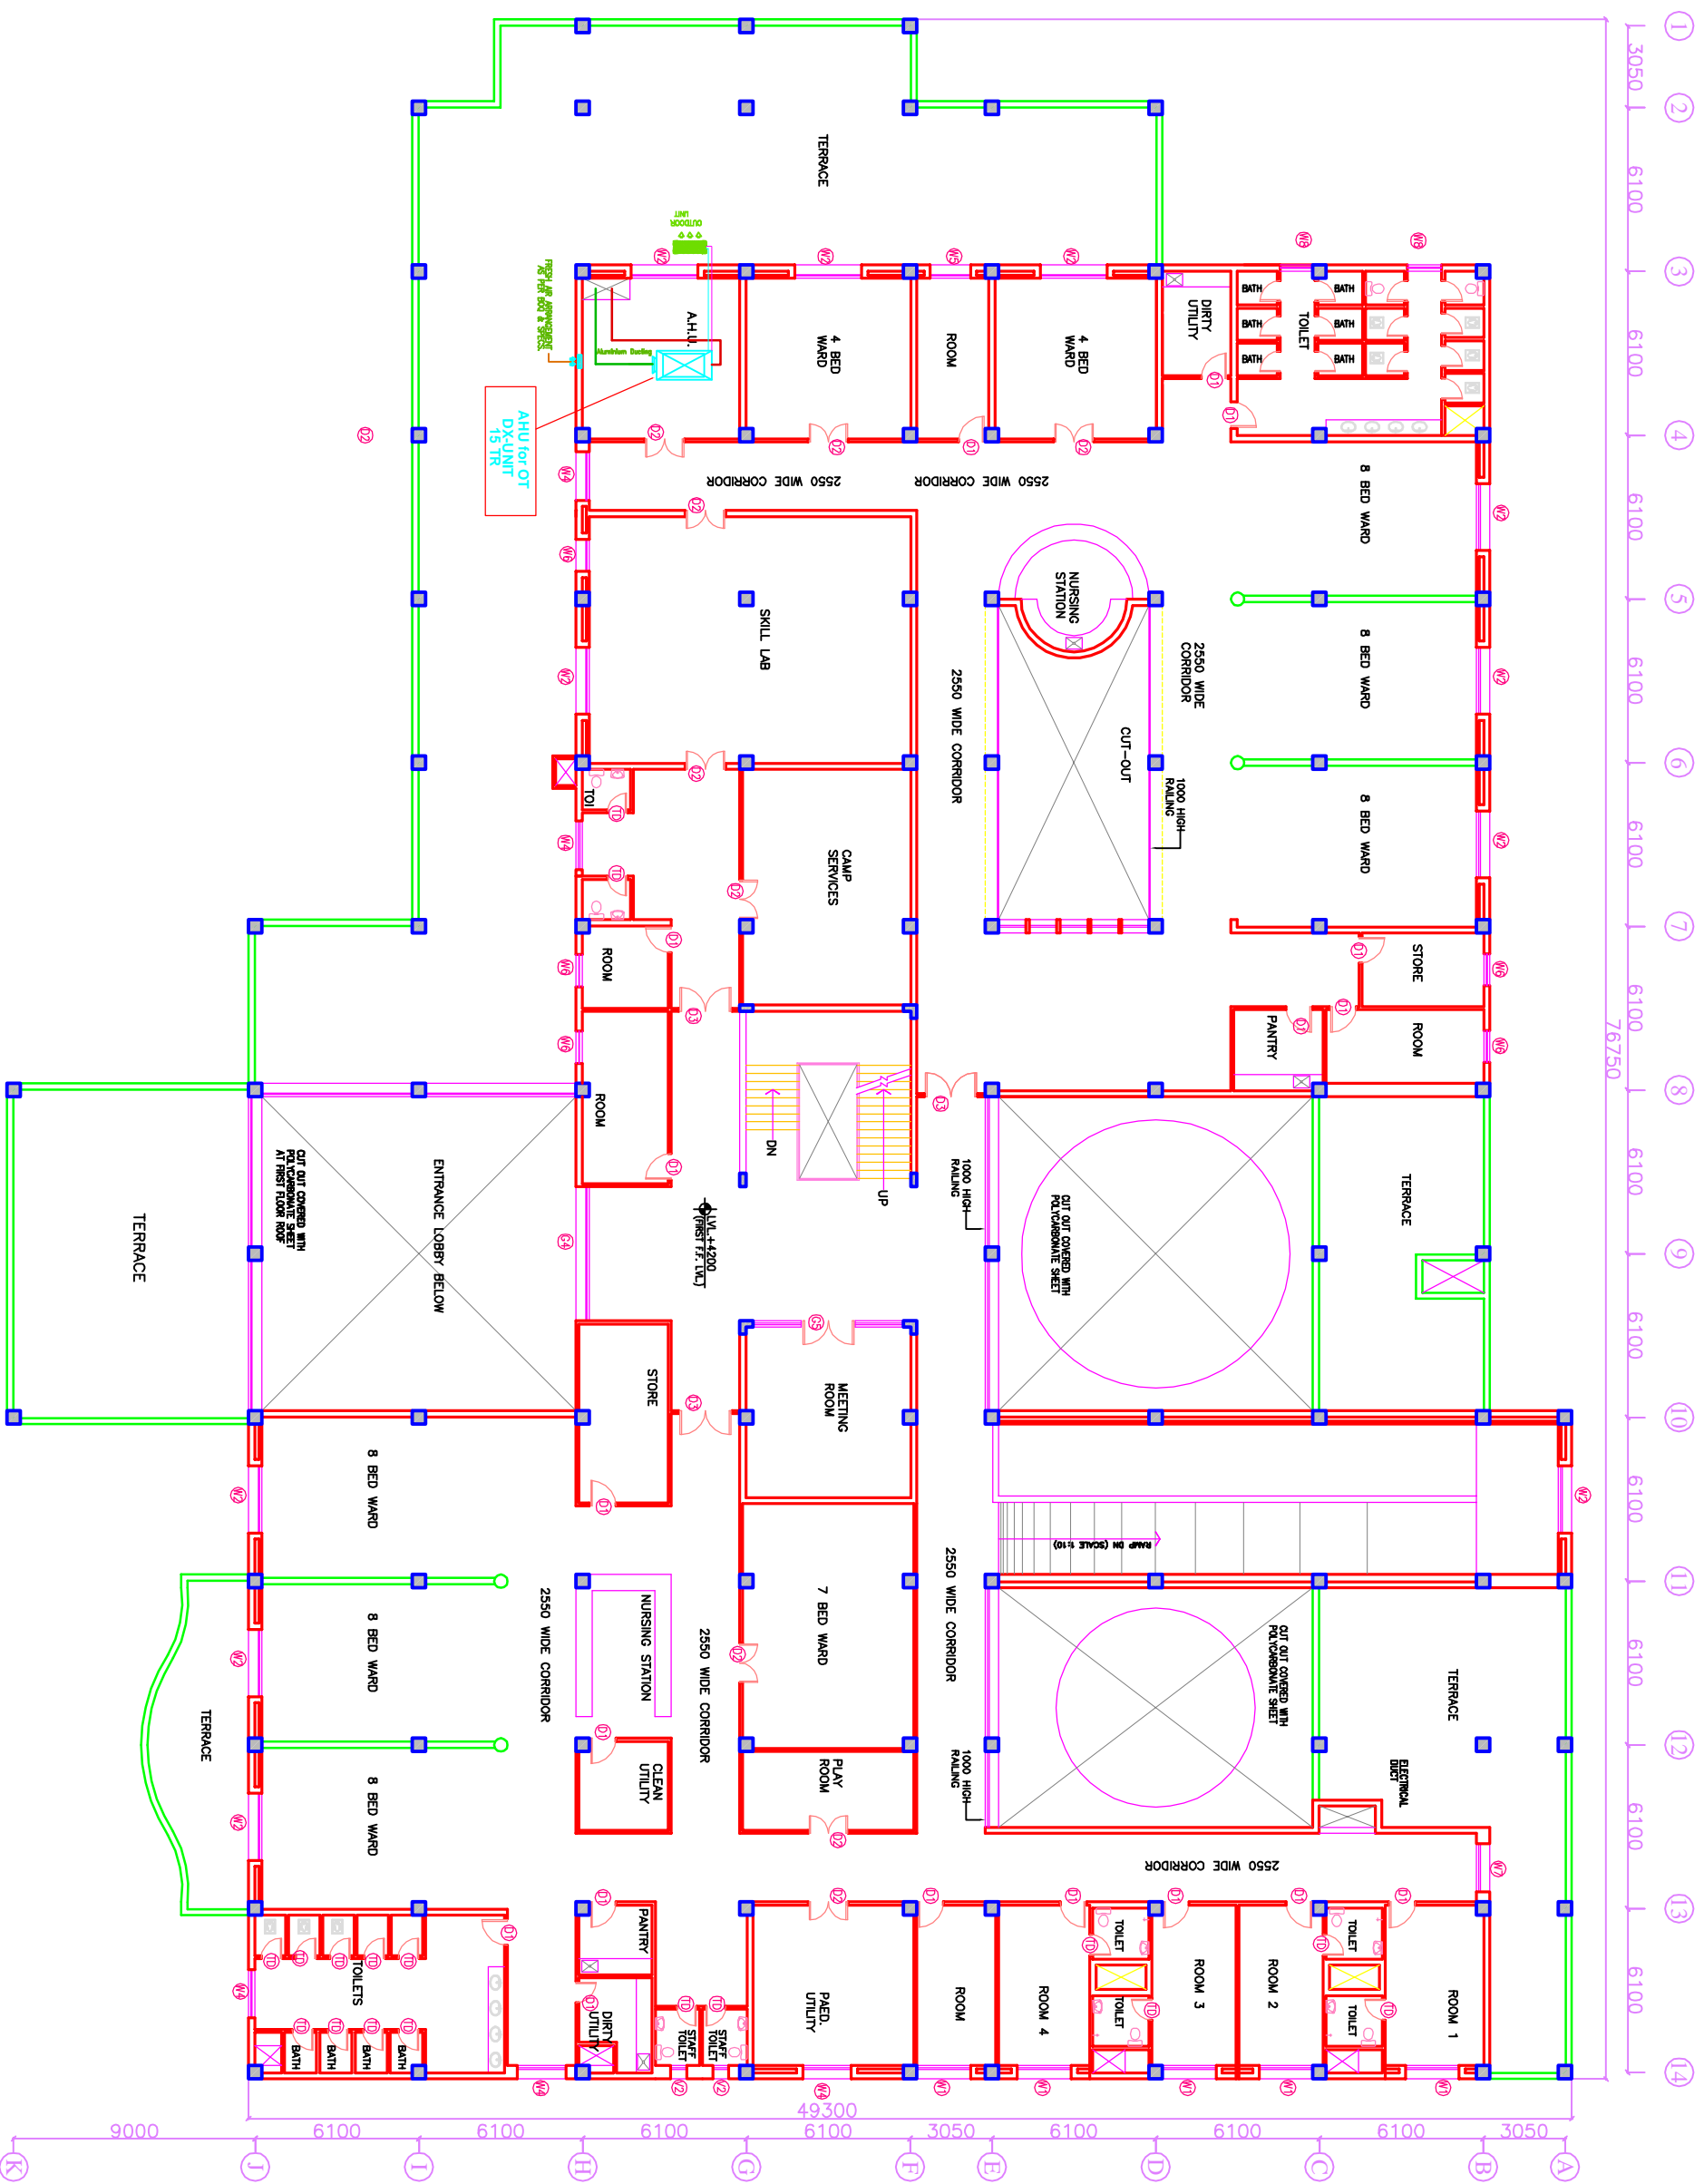

1 3050 2 6100 3 6100 4 6100 5 6100 6 6100 7 6100 8 6100 9 6100 10 6100 11 6100 12 6100 13 6100 14 6100

76750

9000 6100 6100 6100 6100 49300 6100 3050 6100 6100 6100 6100 3050

A B C D E F G H I J K

NOTES

The drawing with all its contents is the sole intellectual property of the Institute of Engineers (India) Ltd. Copying of this drawing or part thereof in whole or in part without the written permission of IESCI is prohibited.

REV	DATE	DESCRIPTION

PROJECT

Proposed
100 Bedded Hospital
At CHHATISGARH

TITLE

TENDER DRAWING
FIRST FLOOR PLAN
HVAC LAYOUT
(COVERED AREA=2050 SQ. MT.)

ESCCD&E/HT/AC/ENR/HA/CG/AC-02	R-0
Drawing No.	
BS/CC/-	1:125
Job No.	Scale
	19-03-2013
	Date
App by	Rev. by
	Prep. by