


PHE & FIRE

DRAWINGS

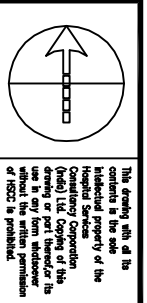

This drawing with all the contents in the same shall be the intellectual property of the HSCC (INDIA) LIMITED. Any use or part thereof without the written permission of HSCC is prohibited.

- NOTES**
1. DRAWINGS TO BE READ NOT MEASURED
 2. PARTITION WALL IN TOILETS UP TO LINTEL HEIGHT

LEGEND:

1	100 Ø CI SOIL & VENT PIPE
2	100Ø CI WASTE & VENT PIPE
3	100Ø CI SOIL PIPE
4	100Ø CI WASTE PIPE
5	50Ø GI/CPVC SOIL PIPE
6	40Ø GI/CPVC WASTE PIPE for lab, Urinal
7	32Ø GI/CPVC WASTE PIPE FOR W.B.
8	Ø CPVC UTW/DN TAKE
9	Ø CPVC TW/DN TAKE
10	100 Ø S.W. PIPE
11	100 Ø R.W. PIPE
12	100 Ø HDPE/LAB WASTE PIPE
13	50 Ø HDPE/LAB WASTE PIPE
FT	FLOOR TRAP-100x100
FD	FLOOR DRAIN 50Ø
FO	FLOOR CLEAN OUT
COF	CLEAN OUT PLUG
⊗	VALVE
MH	MANHOLE (900x900)mm
GT	GULLY TRAP(300x300)mm

REVISION	DESCRIPTION

PROJECT
PROPOSED
100 BEDDED HOSPITAL

**RMNCH PROJECT,
CHATTISGARH**

**TITLE PLUMBING
TENDER DRAWING**


**GROUND
FLOOR PLAN**

HSCC/D&E/TD/RMNCHE/PL-01	Rev.
Drawing No.	
Job No.	1-300
	Scale
	06-04-2013
	Date


RITAGI	R.SUR	S.BHAI
App By	Rev. by	Prep. by

HSCC (INDIA) LIMITED
(A GOVERNMENT OF INDIA ENTERPRISE)
HSCC
INDIA

- NOTES**
1. BASED ON THIS DRAWING EXECUTING AGENCY WILL PREPARE SHOP DRAWING AFTER INCORPORATING THE CHANGES AS PER SITE CONDITION FOR THE APPROVAL OF HSCC BEFORE START OF WORK.
 2. THE NUMBER & LOCATION OF FIXTURES & WET POINT TO BE FINALIZED BEFORE EXECUTION WITH CLINT OFFICER'S INCHARGE..

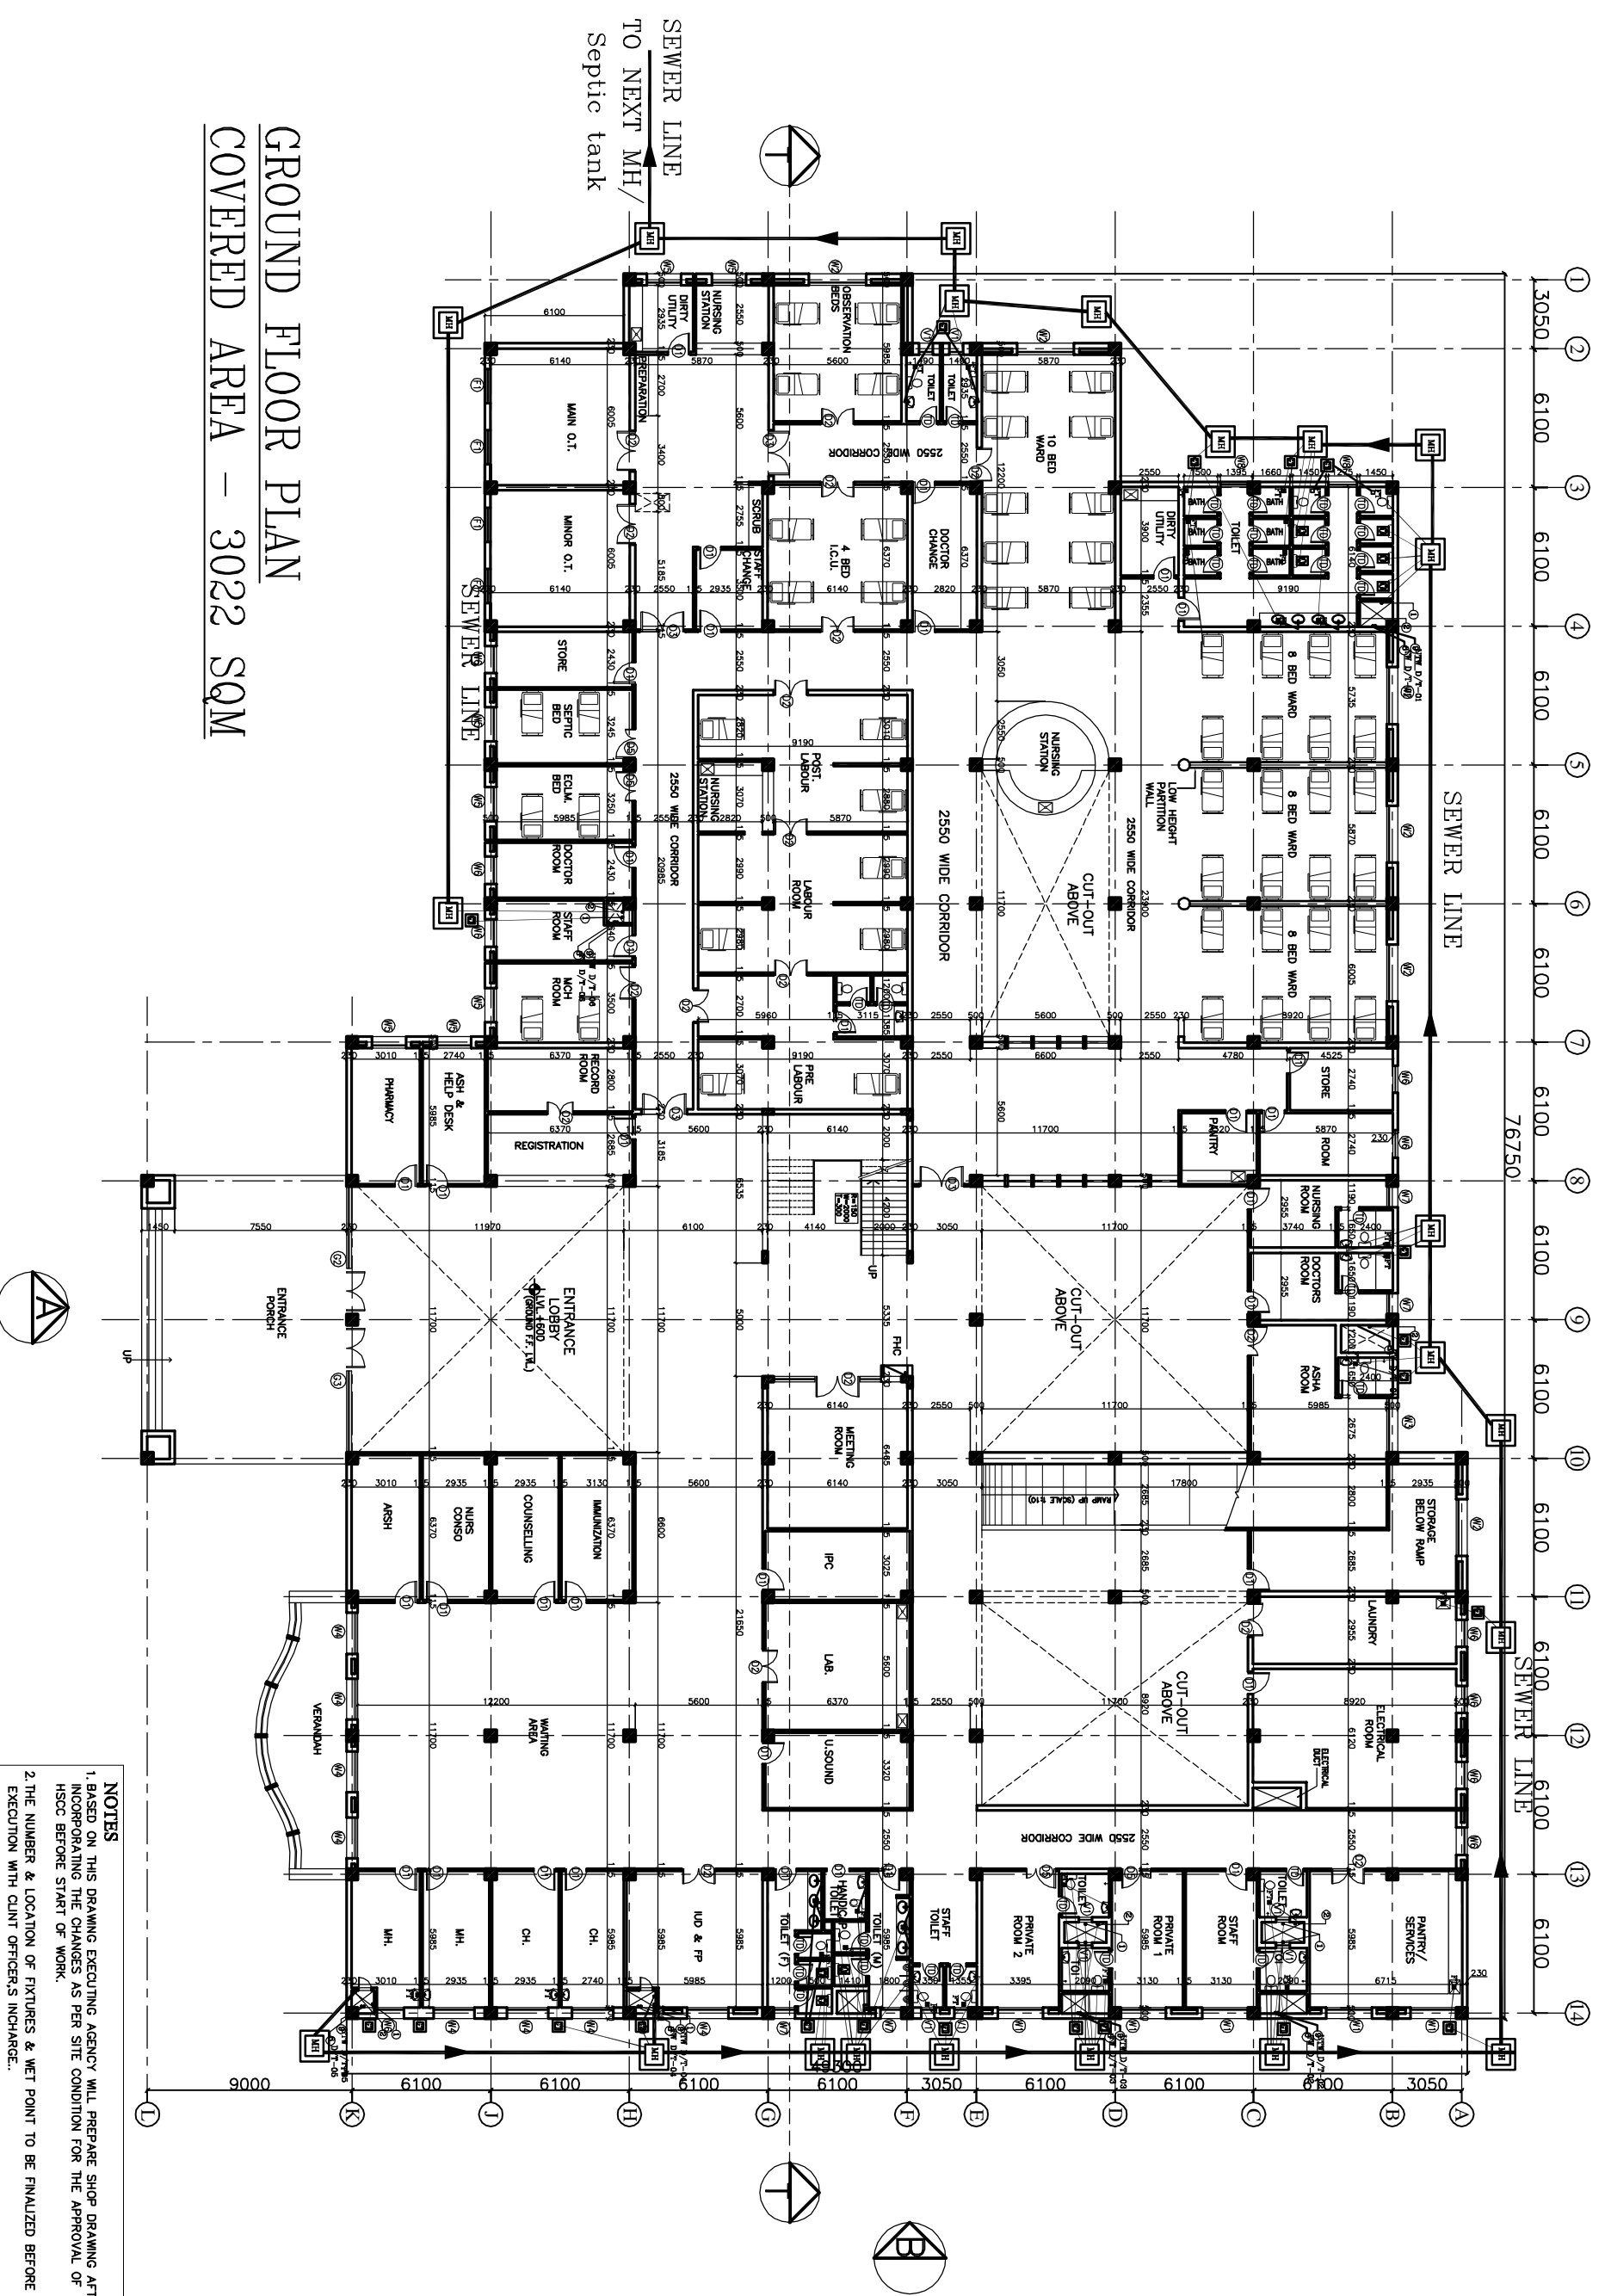

**GROUND FLOOR PLAN
COVERED AREA - 3022 SQM**

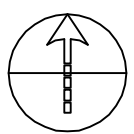

This drawing with all its contents is the sole intellectual property of the Consulting Engineer (India) Ltd. Copying of this drawing or part thereof in any form or by any means without the written permission of HSCC is prohibited.

- NOTES**
1. DRAWINGS TO BE READ NOT MEASURED
 2. PARTITION WALL IN TOILETS UP TO UNTEL HEIGHT

LEGEND:

1	100 Ø CI SOIL & VENT PIPE
2	100Ø CI WASTE & VENT PIPE
3	100Ø CI SOIL PIPE
4	100Ø CI WASTE PIPE
5	50Ø GI/CPVC SOIL PIPE
6	40Ø GI/CPVC WASTE PIPE for Sk.Utlia
7	32Ø GI/CPVC WASTE PIPE FOR W.A.
8	Ø CPVC UTW/DN.7/4K
9	Ø CPVC TW/DN.7/4K
10	100 Ø S.W. PIPE
11	100 Ø R.W. PIPE
12	100 Ø HDPE/LAB WASTE PIPE
13	50 Ø HDPE/LAB WASTE PIPE
FD	FLOOR DRAIN 50Ø
FT	FLOOR TRAP 100x100
FCO	FLOOR CLEAN OUT
CP	CLEAN OUT PLUG
∇	VALVE
MH	MANHOLE (900x900)mm
GT	GULLY TRAP(300x300)mm


REVISION	DESCRIPTION

PROJECT
 PROPOSED
 100 BEDDED HOSPITAL
 RMNCH PROJECT,
 CHATTISGARH

TITLE PLUMBING
 TENDER DRAWING
 FIRST
 FLOOR PLAN

HSCC/D&E/TD/RMNC/PL-02	Rev
Drawing No.	
Job No.	1:300
Scale	05-04-2013
Date	
App by	R.TAGI
Rev. by	R.SUR
Prep. by	S.BHATT


HSCC (INDIA) LIMITED
 (A GOVERNMENT OF INDIA ENTERPRISE)
HSCC
 NEW DELHI INDIA

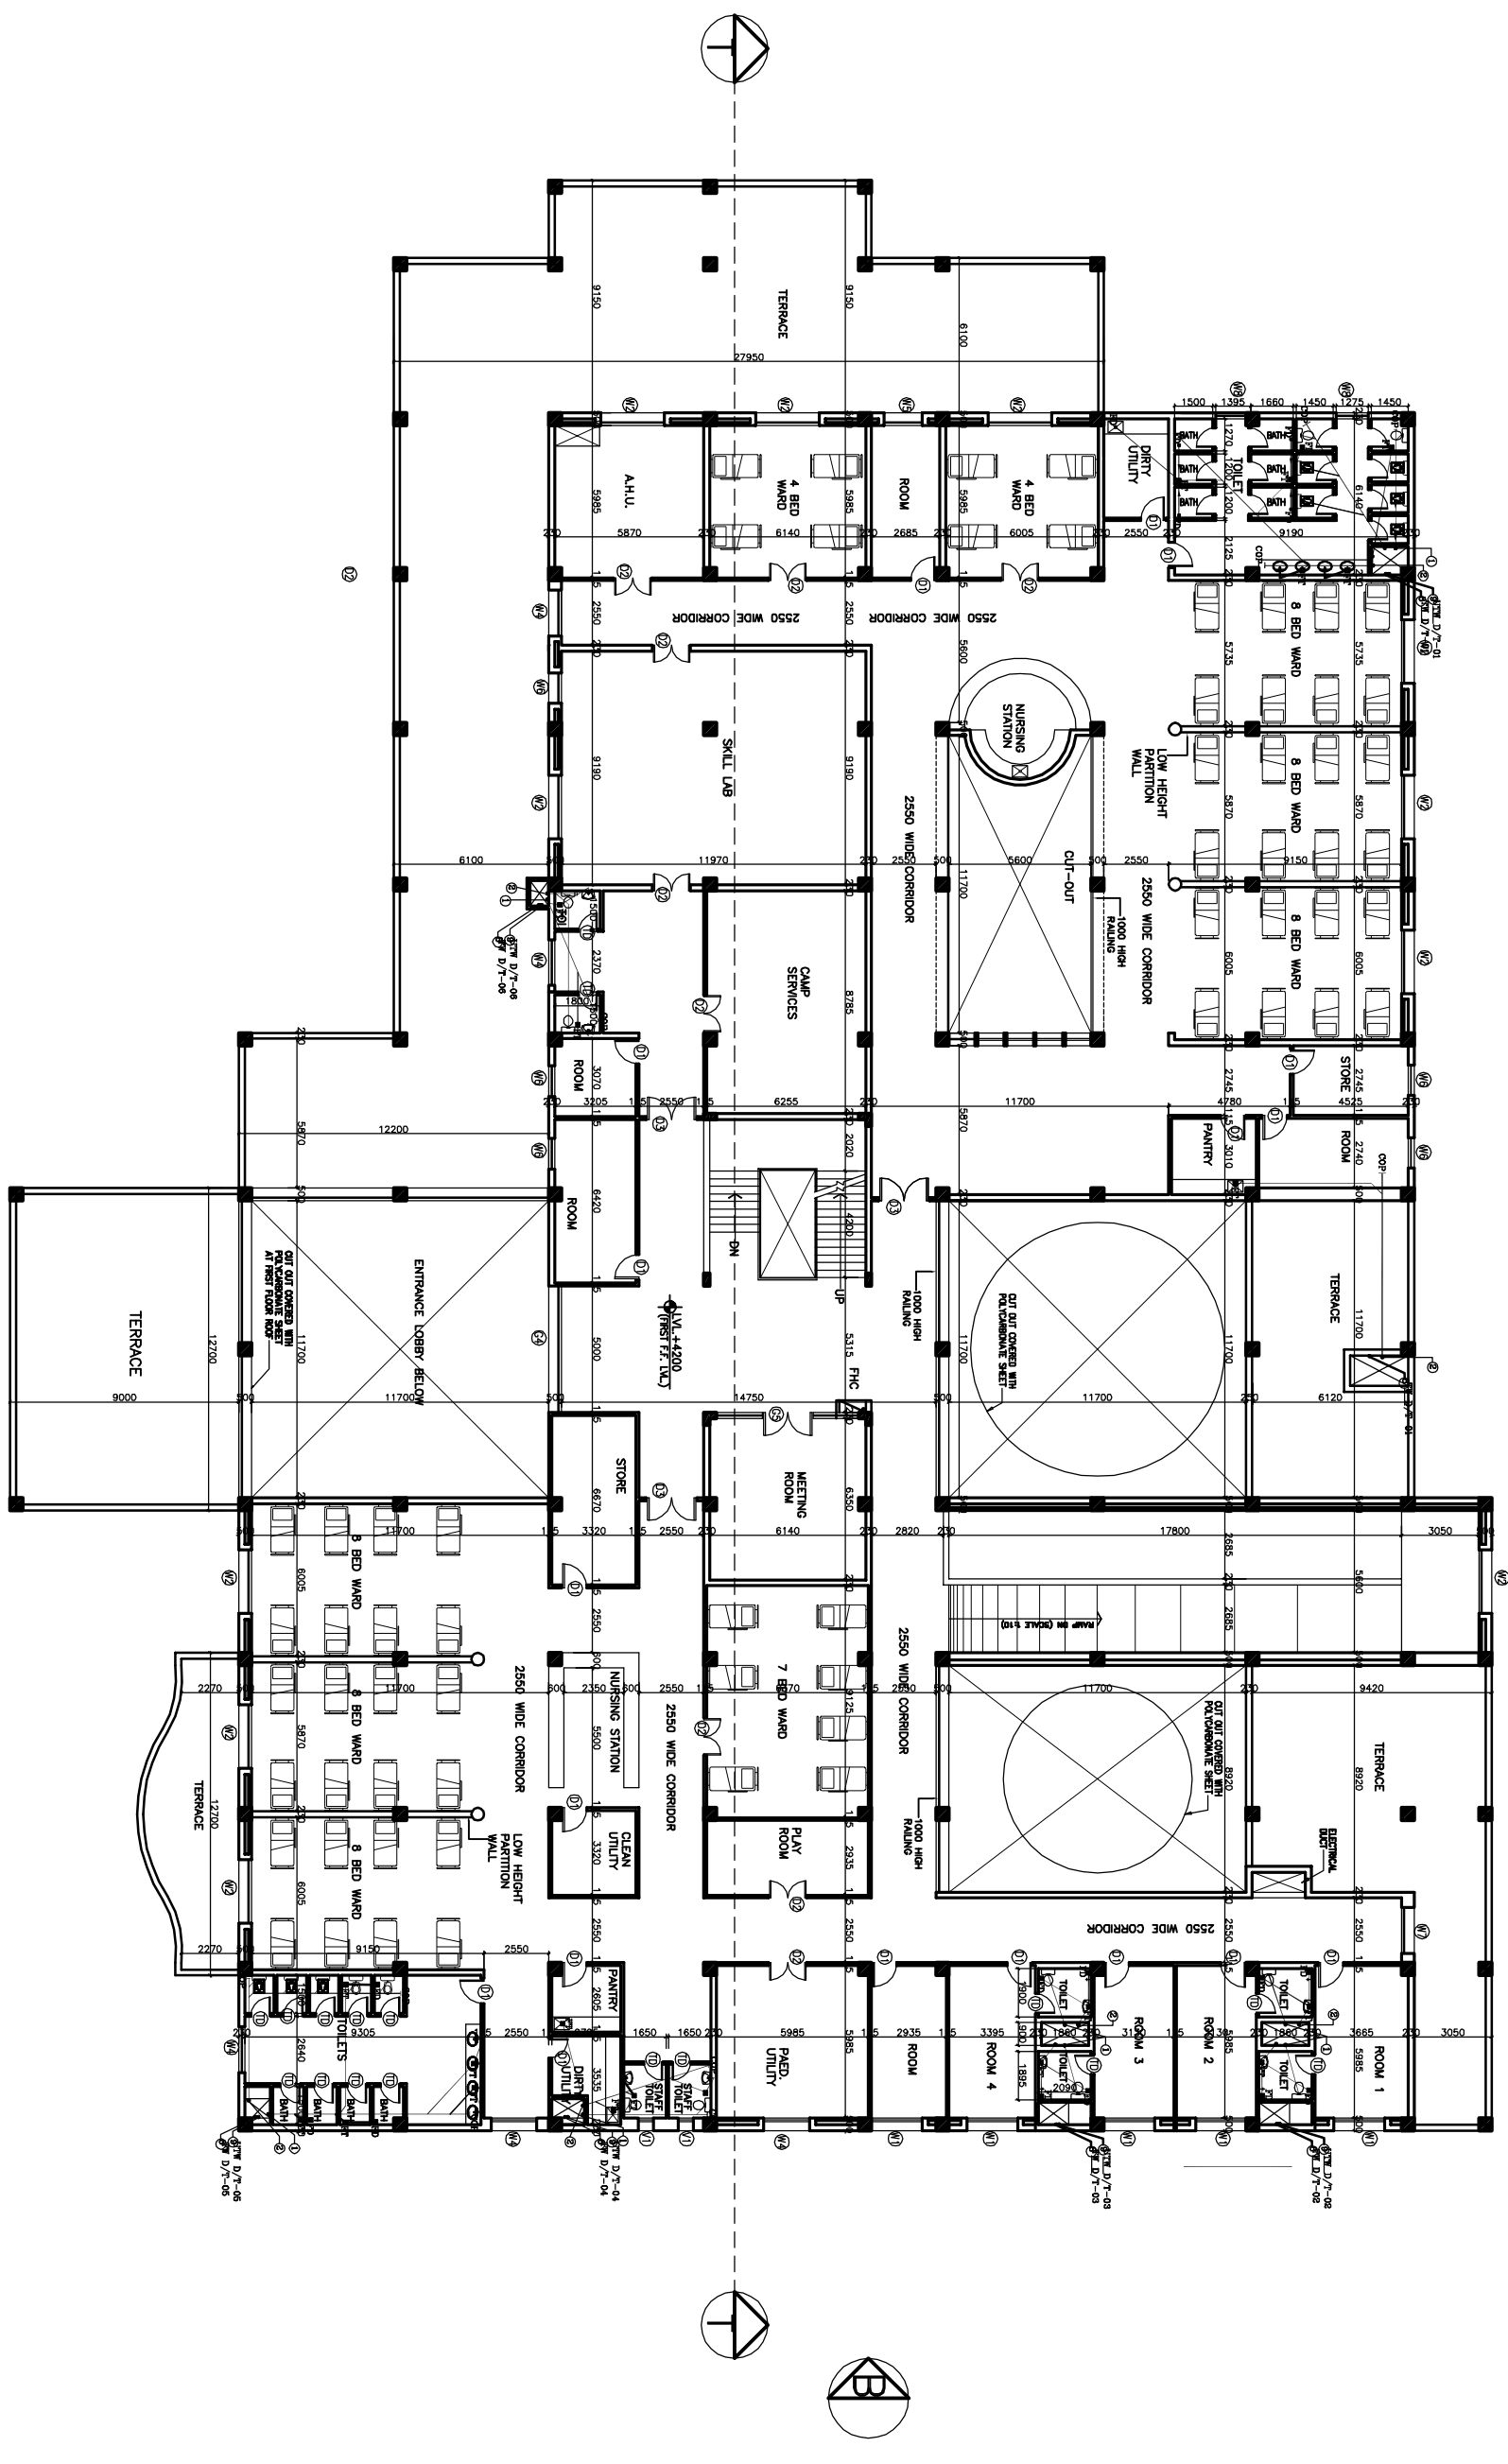

FIRST FLOOR PLAN
COVERED AREA – 2050 SQM



- NOTES**
1. BASED ON THIS DRAWING EXECUTING AGENCY WILL PREPARE SHOP DRAWING AFTER INCORPORATING THE CHANGES AS PER SITE CONDITION FOR THE APPROVAL OF HSCC BEFORE START OF WORK.
 2. THE NUMBER & LOCATION OF FIXTURES & WET POINT TO BE FINALIZED BEFORE EXECUTION WITH CLINT OFFICER'S INCHARGE..

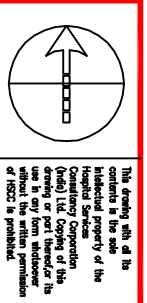

This drawing, with all the contents in the same, is the intellectual property of the Consulting Corporation (India) Ltd. Copying of this drawing or part thereof for any purpose without the written permission of HSCC is prohibited.

- NOTES**
1. DRAWINGS TO BE READ NOT MEASURED
 2. PARTITION WALL IN TOILETS UP TO LINTEL HEIGHT

LEGEND:

1	100 Ø CI SOIL & VENT PIPE
2	100Ø CI WASTE & VENT PIPE
3	100Ø CI SOIL PIPE
4	100Ø CI WASTE PIPE
5	50Ø ØI/CPVC SOIL PIPE
6	40Ø ØI/CPVC WASTE PIPE FOR URINAL LAB/SINK
7	32Ø ØI/CPVC WASTE PIPE FOR W.B.
8	Ø CPVC UTW/DN TAKE
9	Ø CPVC TW/DN TAKE
10	100 Ø S.W. PIPE
11	100 Ø R.W. PIPE
12	100 Ø HDPE LAB WASTE PIPE
13	50 Ø HDPE LAB WASTE PIPE
FT	FLOOR TRAP-100x100
FD	FLOOR DRAIN 50Ø
FO	FLOOR CLEAN OUT
COF	CLEAN OUT FLUG
✕	VALVE
MH	MANHOLE (900x900)mm
GT	GULLY TRAP(300x300)mm

REVISION	DESCRIPTION

PROJECT
PROPOSED
100 BEDDED HOSPITAL



**RMNCH PROJECT,
CHATTISGARH**

**TITLE PLUMBING
TENDER DRAWING**

**TERRACE
FLOOR PLAN**

HSCC/D&E/TD/RMNCHE/PL-03 Rev.

Drawing No.	1:300	Date
Job No.	Scale	06-04-2013
App. by	Rev. by	Prep. by
R.TYAGI	R.SUR	S.BHAI

 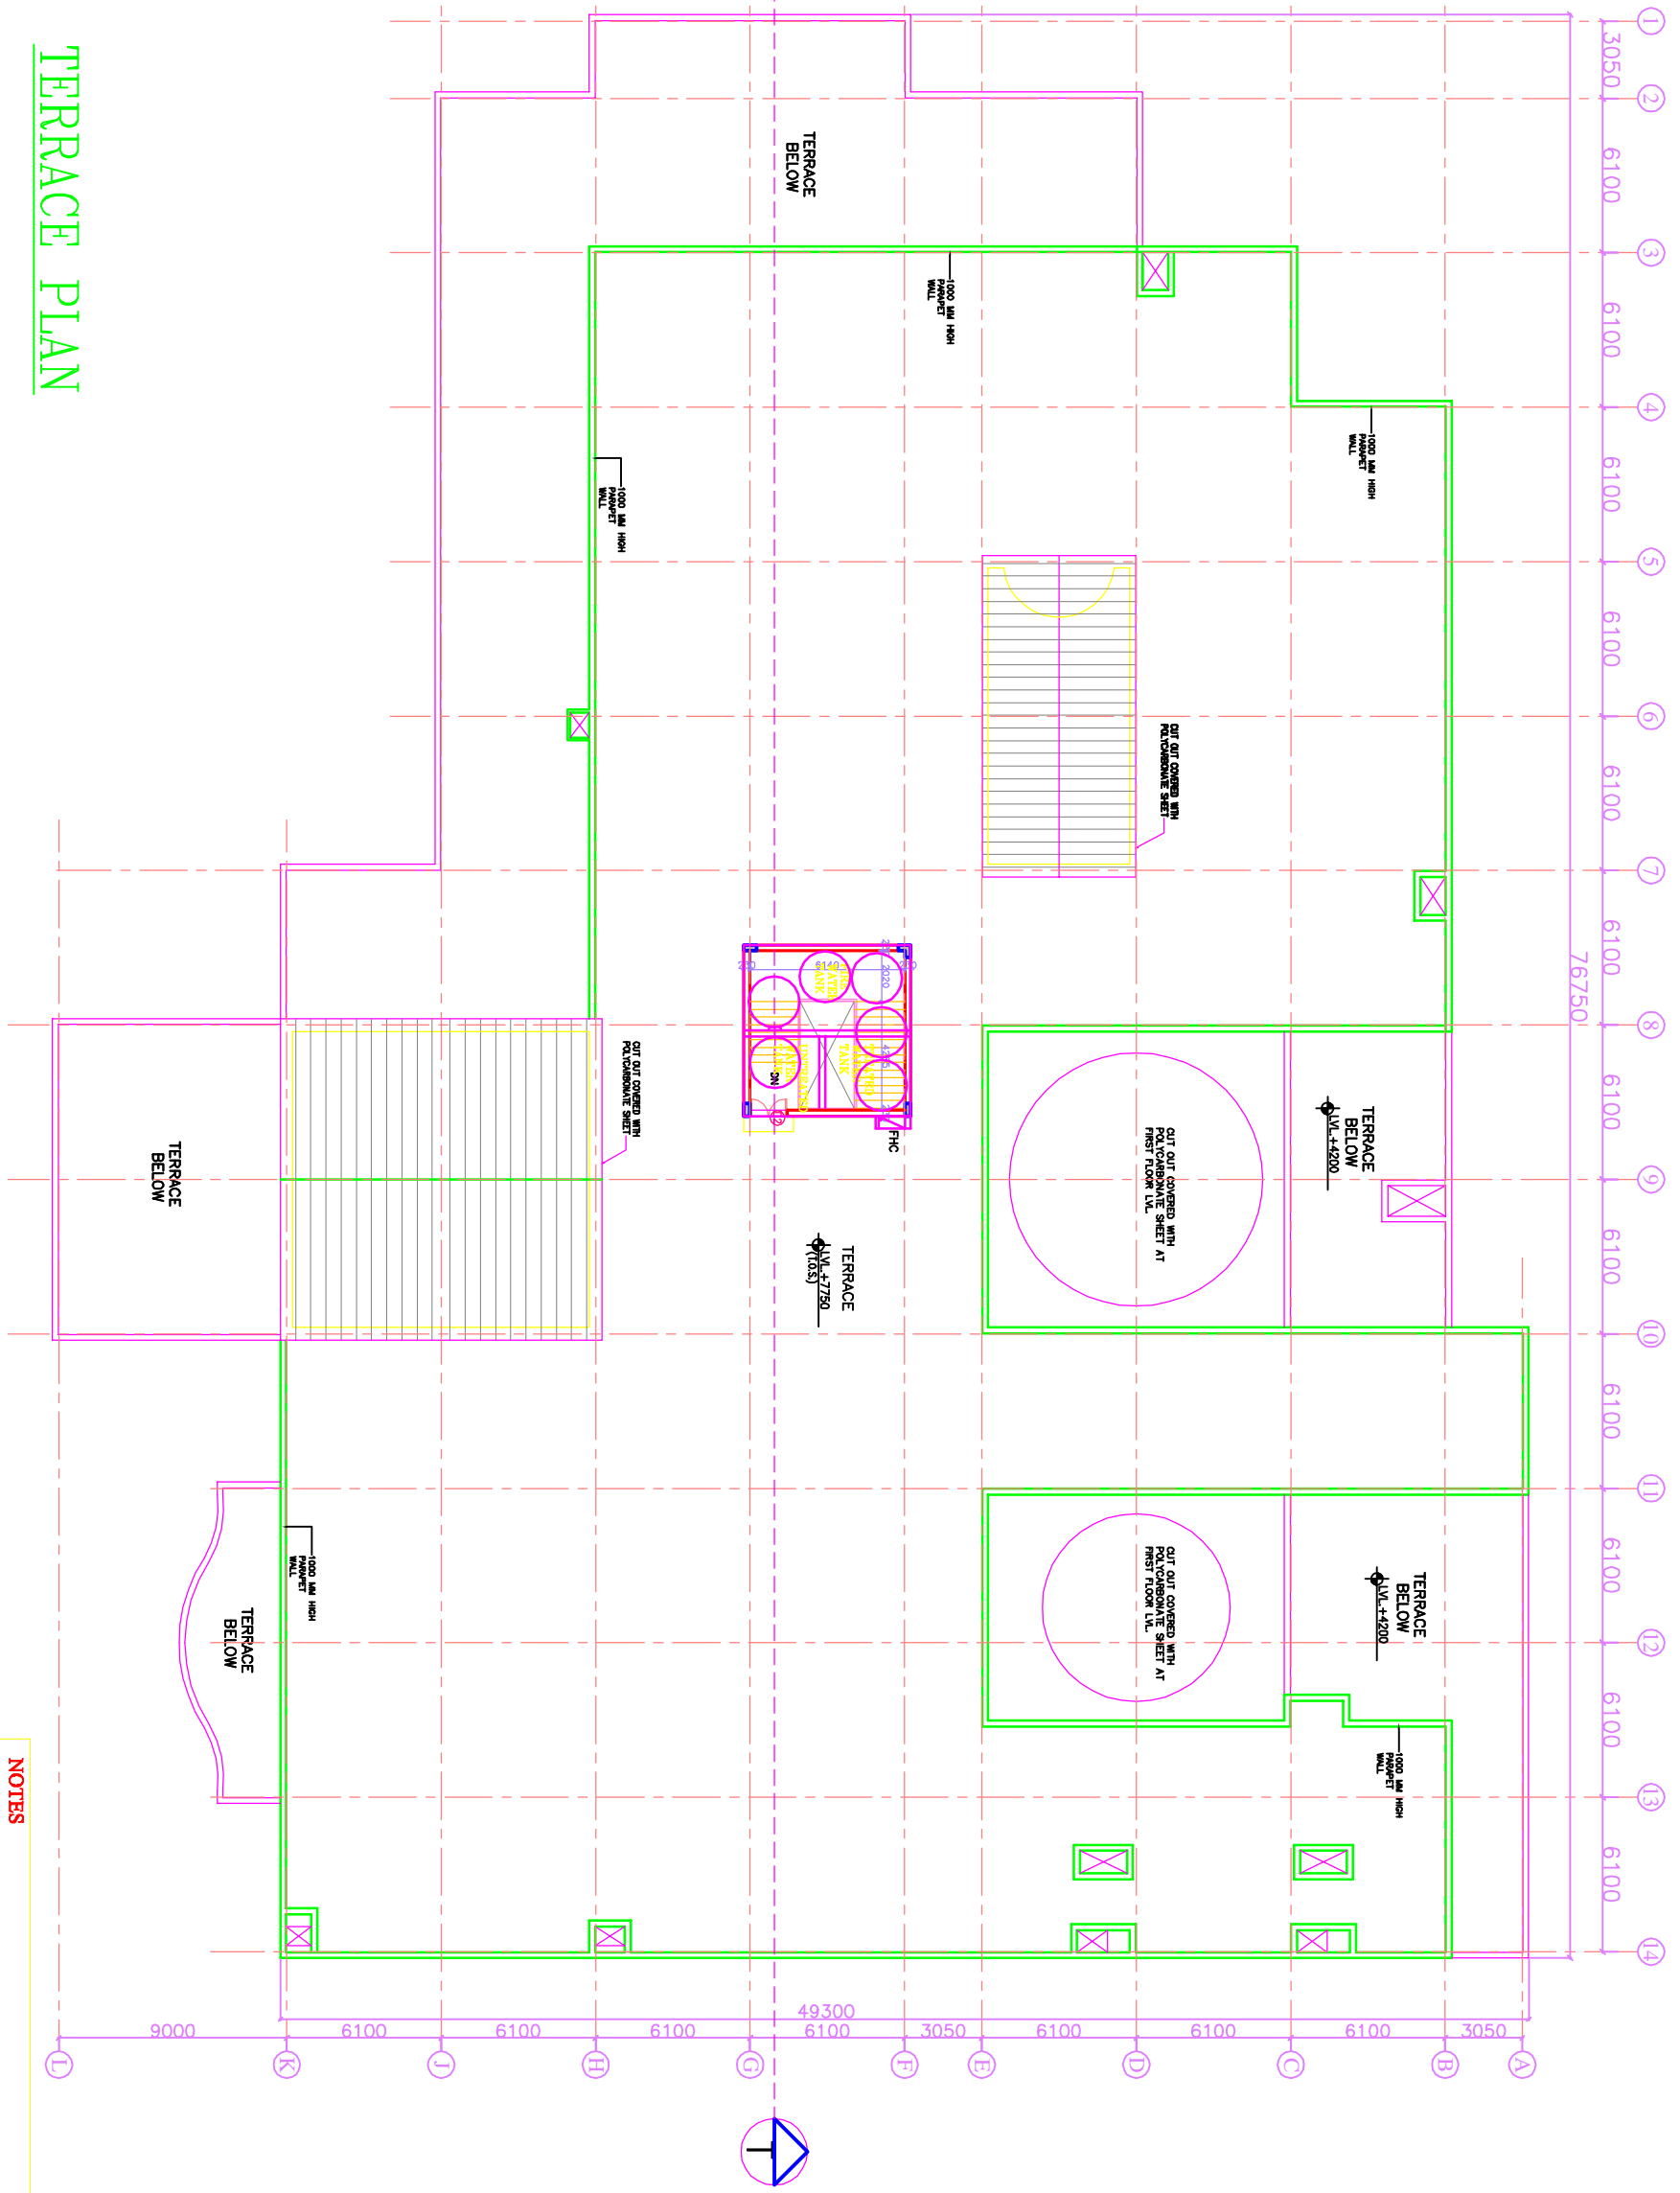

TERRACE PLAN


- NOTES**
1. BASED ON THIS DRAWING EXECUTING AGENCY WILL PREPARE SHOP DRAWING AFTER INCORPORATING THE CHANGES AS PER SITE CONDITION FOR THE APPROVAL OF HSCC BEFORE START OF WORK.
 2. THE NUMBER & LOCATION OF FIXTURES & WET POINT TO BE FINALIZED BEFORE EXECUTION WITH CLINT OFFICER'S INCHARGE..

ELECTRICAL

DRAWINGS

This drawing with all its contents is the sole intellectual property of the HSCC (INDIA) LIMITED (A GOVERNMENT OF INDIA ENTERPRISE) (INCORPORATED IN INDIA) and shall remain the property of HSCC (INDIA) LIMITED. No part of this drawing may be reproduced, stored in a retrieval system, or transmitted in any form or by any means, electronic, mechanical, photocopying, recording, or by any information storage and retrieval system, without the written permission of HSCC (INDIA) LIMITED. Any unauthorized use or reproduction of this drawing is strictly prohibited.

NOTES

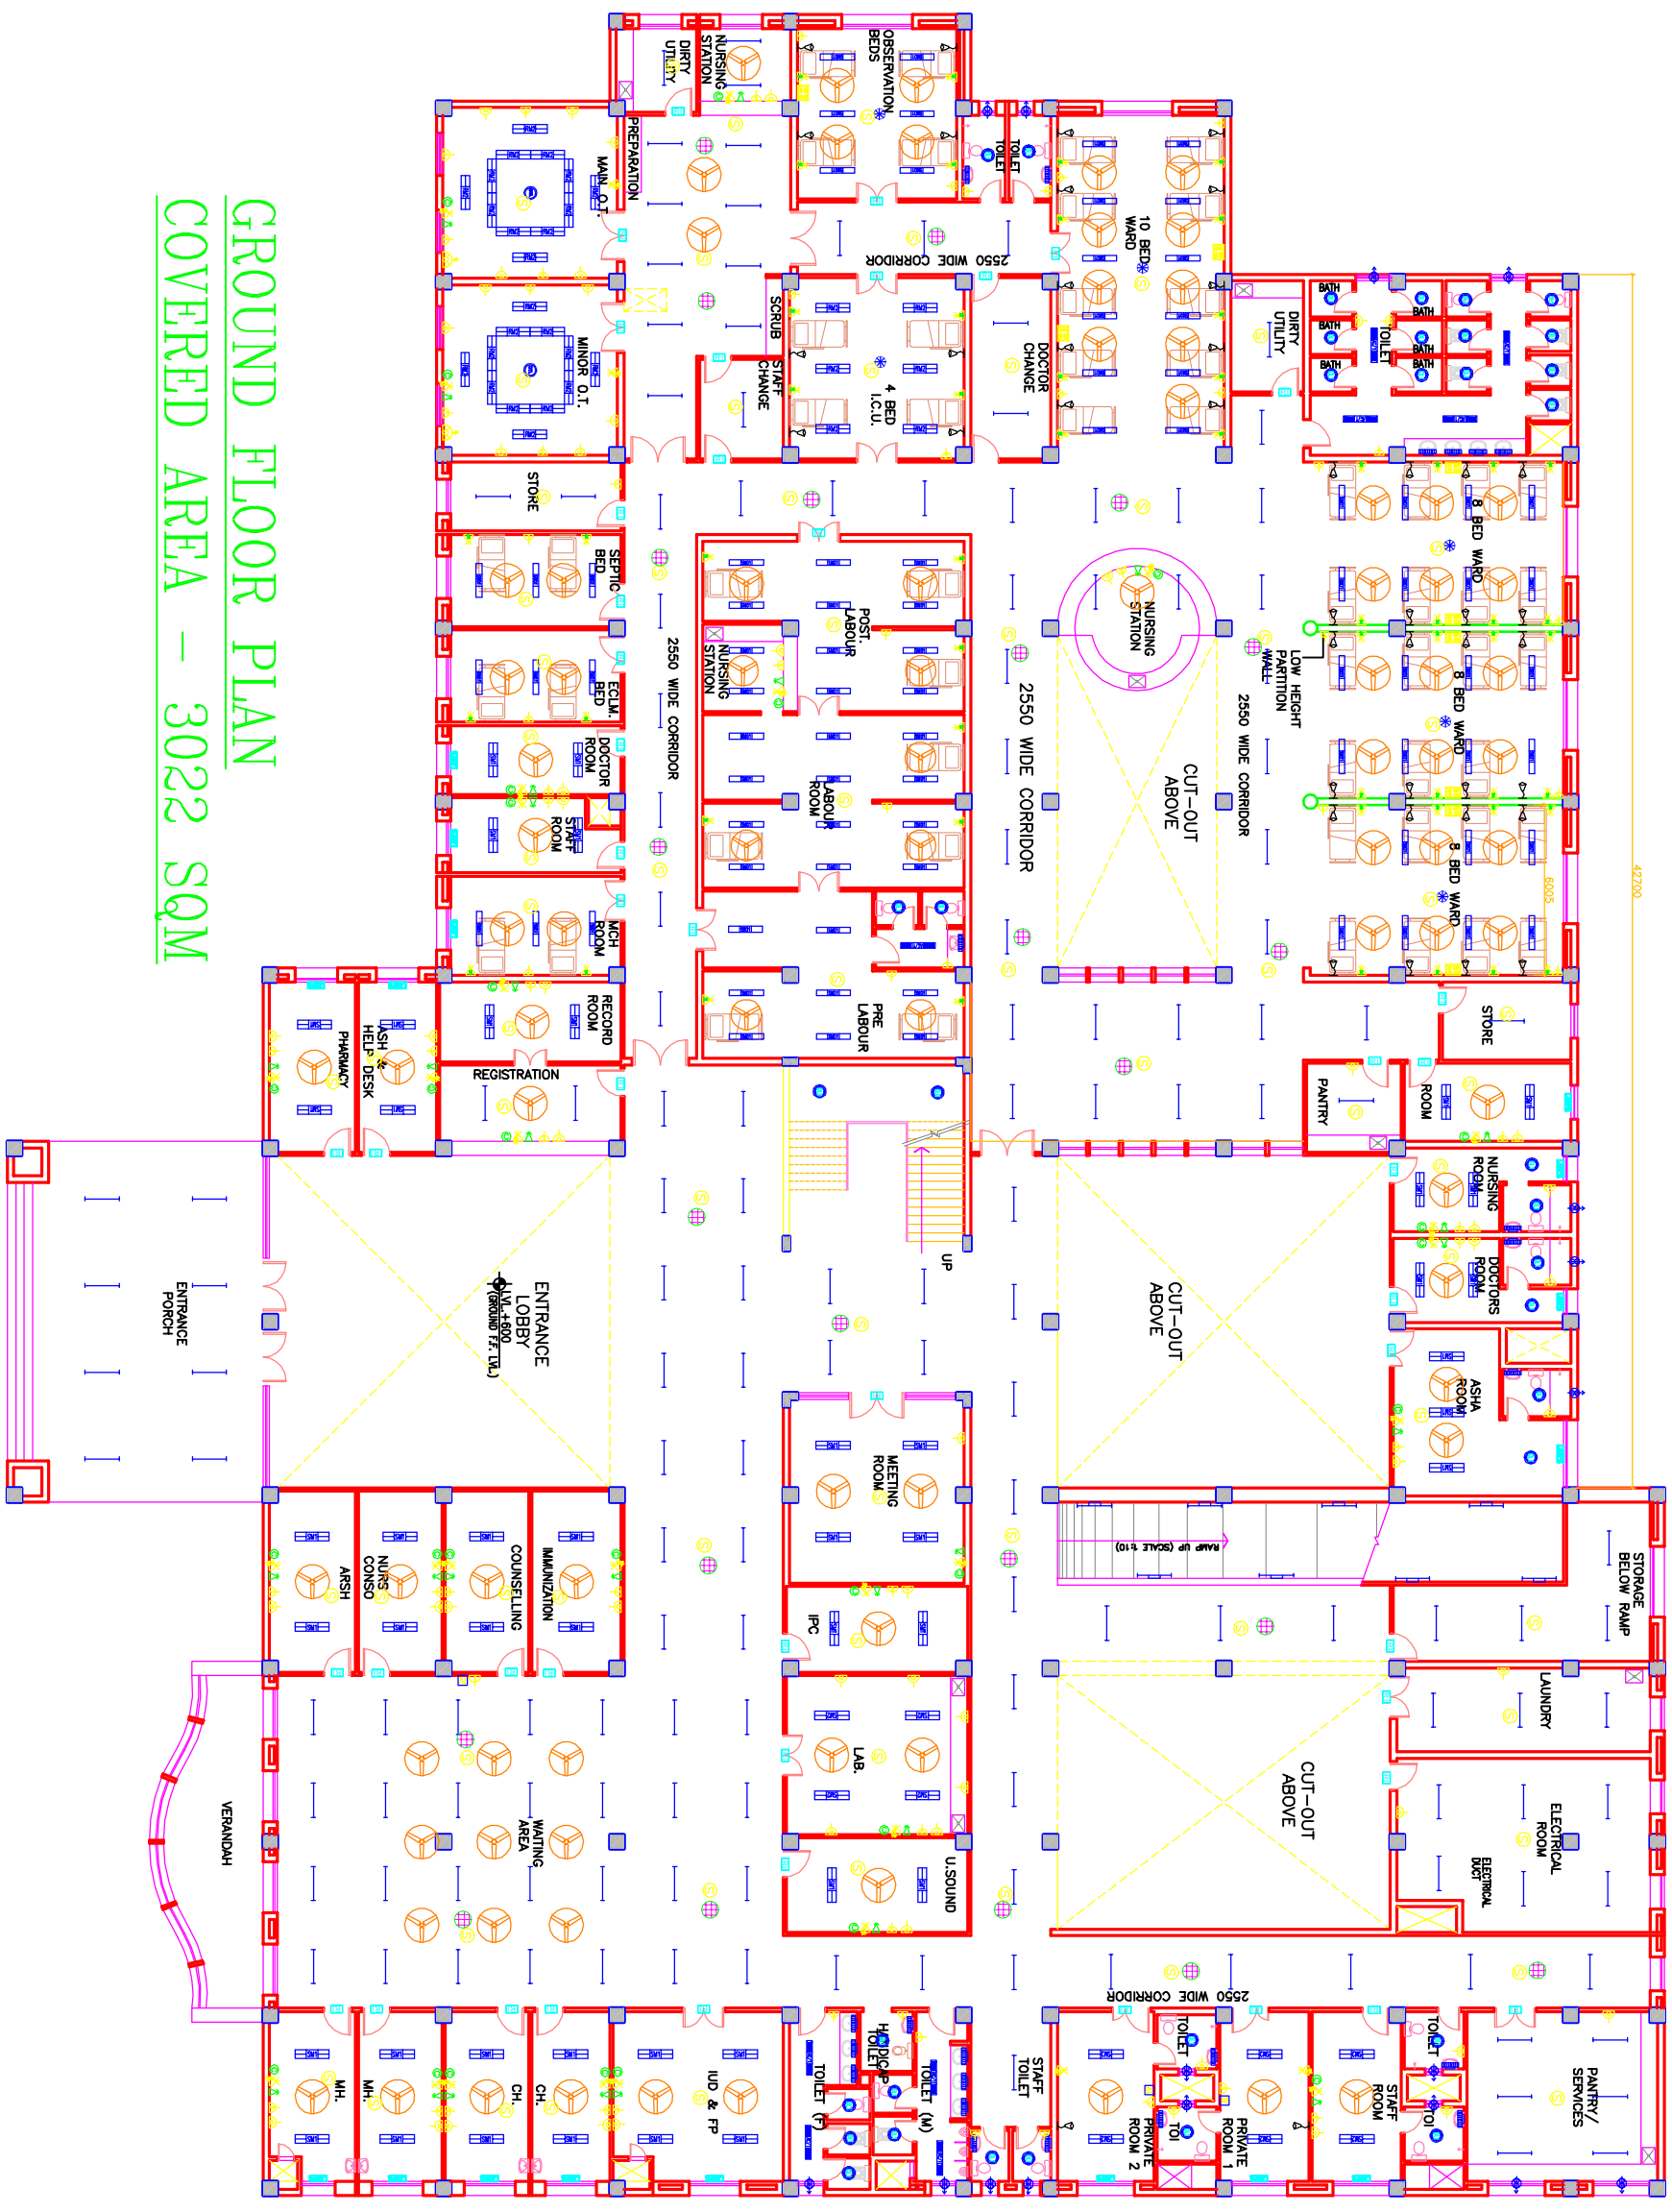


**GROUND FLOOR PLAN
COVERED AREA – 3022 SQM**

PROJECT		RMNCH PROJECT	
		Proposed 100 Bedded Hospital AT CHATTISGARH	
REV. DATE	DESCRIPTION		
TITLE			
MODEL PLANS			
GROUND FLOOR PLAN			
ELECTRICAL LAYOUT			
(COVERED AREA=3022 SQ. MT.)			
HSCC/IA&E/DEL-101			R-0
Drawing No.			
NS	Scale		Date
App by	Rev. by		Prep. by

This drawing with all its contents is the sole intellectual property of the HSCC (INDIA) LIMITED (A GOVERNMENT OF INDIA ENTERPRISE). Any use or part thereof for any purpose without the written permission of HSCC is prohibited.

NOTES

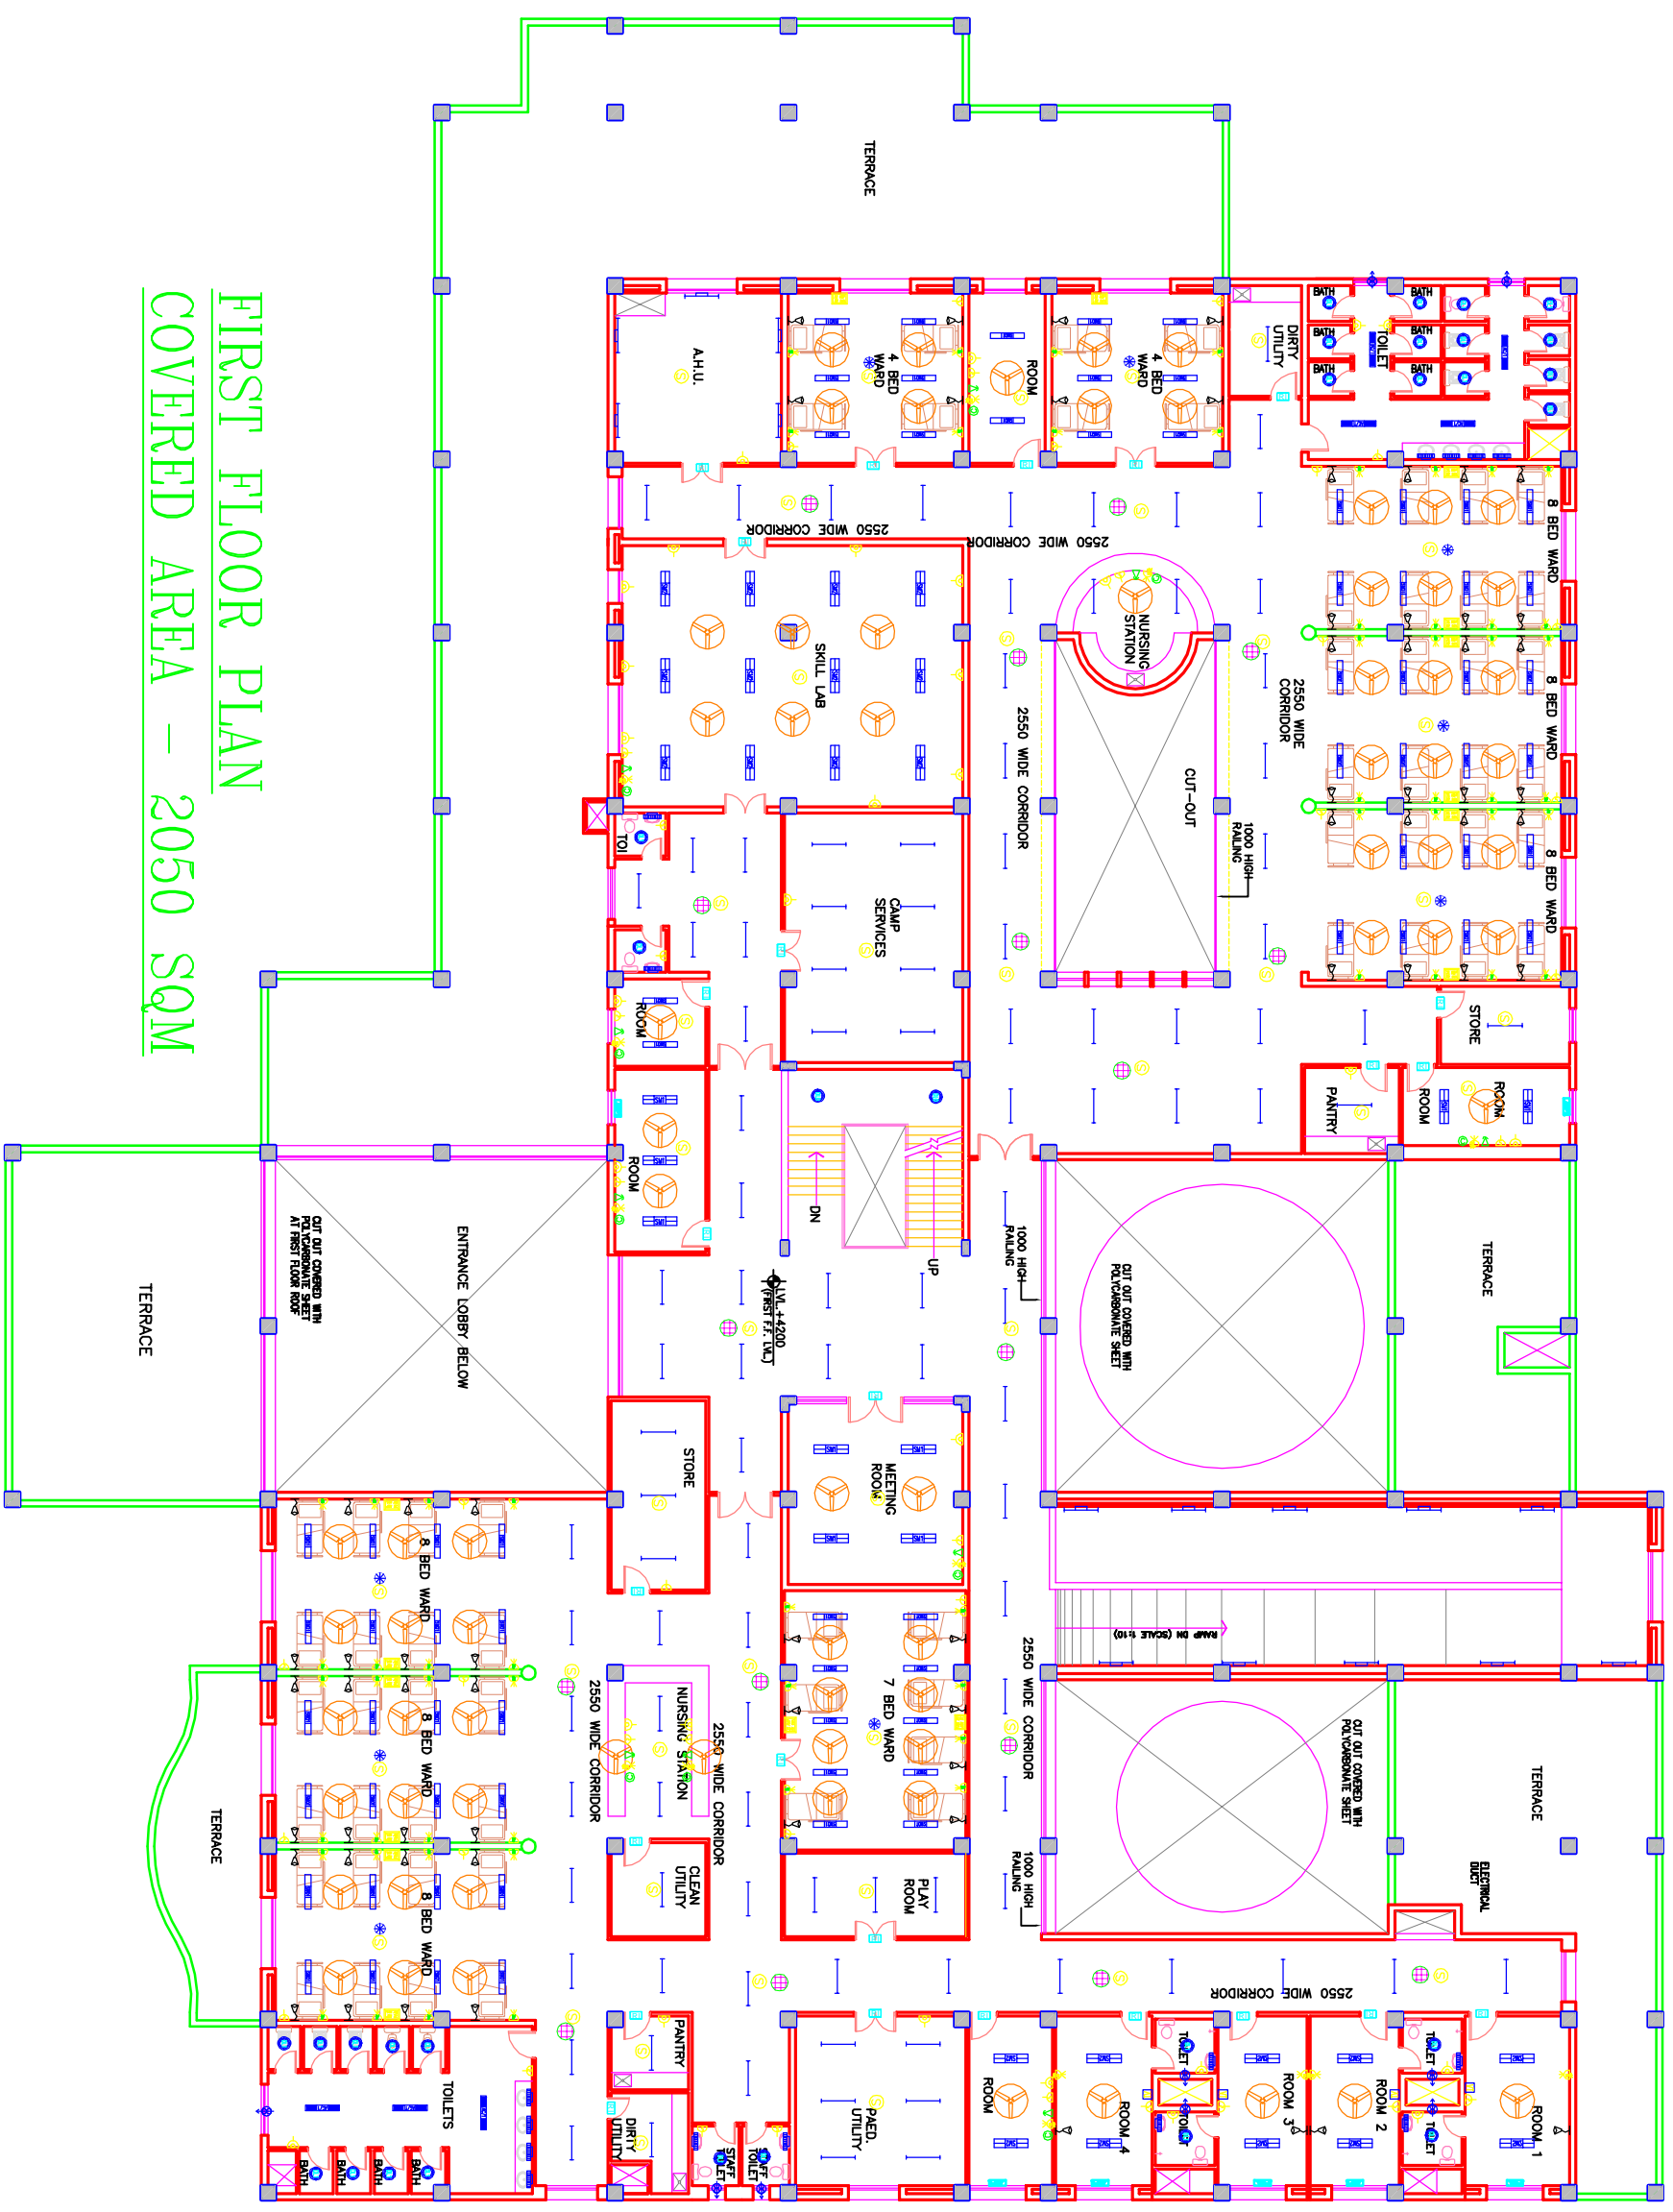

FIRST FLOOR PLAN
COVERED AREA – 2050 SQM

REV.	DATE	DESCRIPTION

PROJECT
RMNCH PROJECT
Proposed
100 Bedded Hospital
AT
CHATTISGARH

TITLE
MODEL PLANS
FIRST
FLOOR PLAN
ELECTRICAL LAYOUT
(COVERED AREA=2050 SQ. MT.)

HSCC/D&E/T/D/EL-102 R-0
Drawing No. Rev.


BSRC/-	NTS	Date
Job No.	Scale	

App by	Rev. by	Prep. by

This drawing with all its contents is the sole intellectual property of the HSCC (INDIA) LIMITED (a Government of India Enterprise) and no part hereof shall be reproduced, stored in a retrieval system or transmitted in any form or by any means, electronic, mechanical, photocopying, recording, or otherwise, without the written permission of HSCC is prohibited.

NOTES

<p>PROJECT RMNCH PROJECT Proposed 100 Bedded Hospital AT CHATTISGARH</p>		<p>TITLE MODEL PLANS TERRACE PLAN ELECTRICAL LAYOUT</p>	
<p>REV. DATE DESCRIPTION</p>	<p>REVISION</p>	<p>HSCC/D&E/ID/DEL-103</p>	<p>R-0</p>
<p>App by</p>	<p>Rev. by</p>	<p>Prep. by</p>	<p>Job No.</p>
<p>Scale</p>	<p>Date</p>	<p>NTS</p>	<p>Job No.</p>

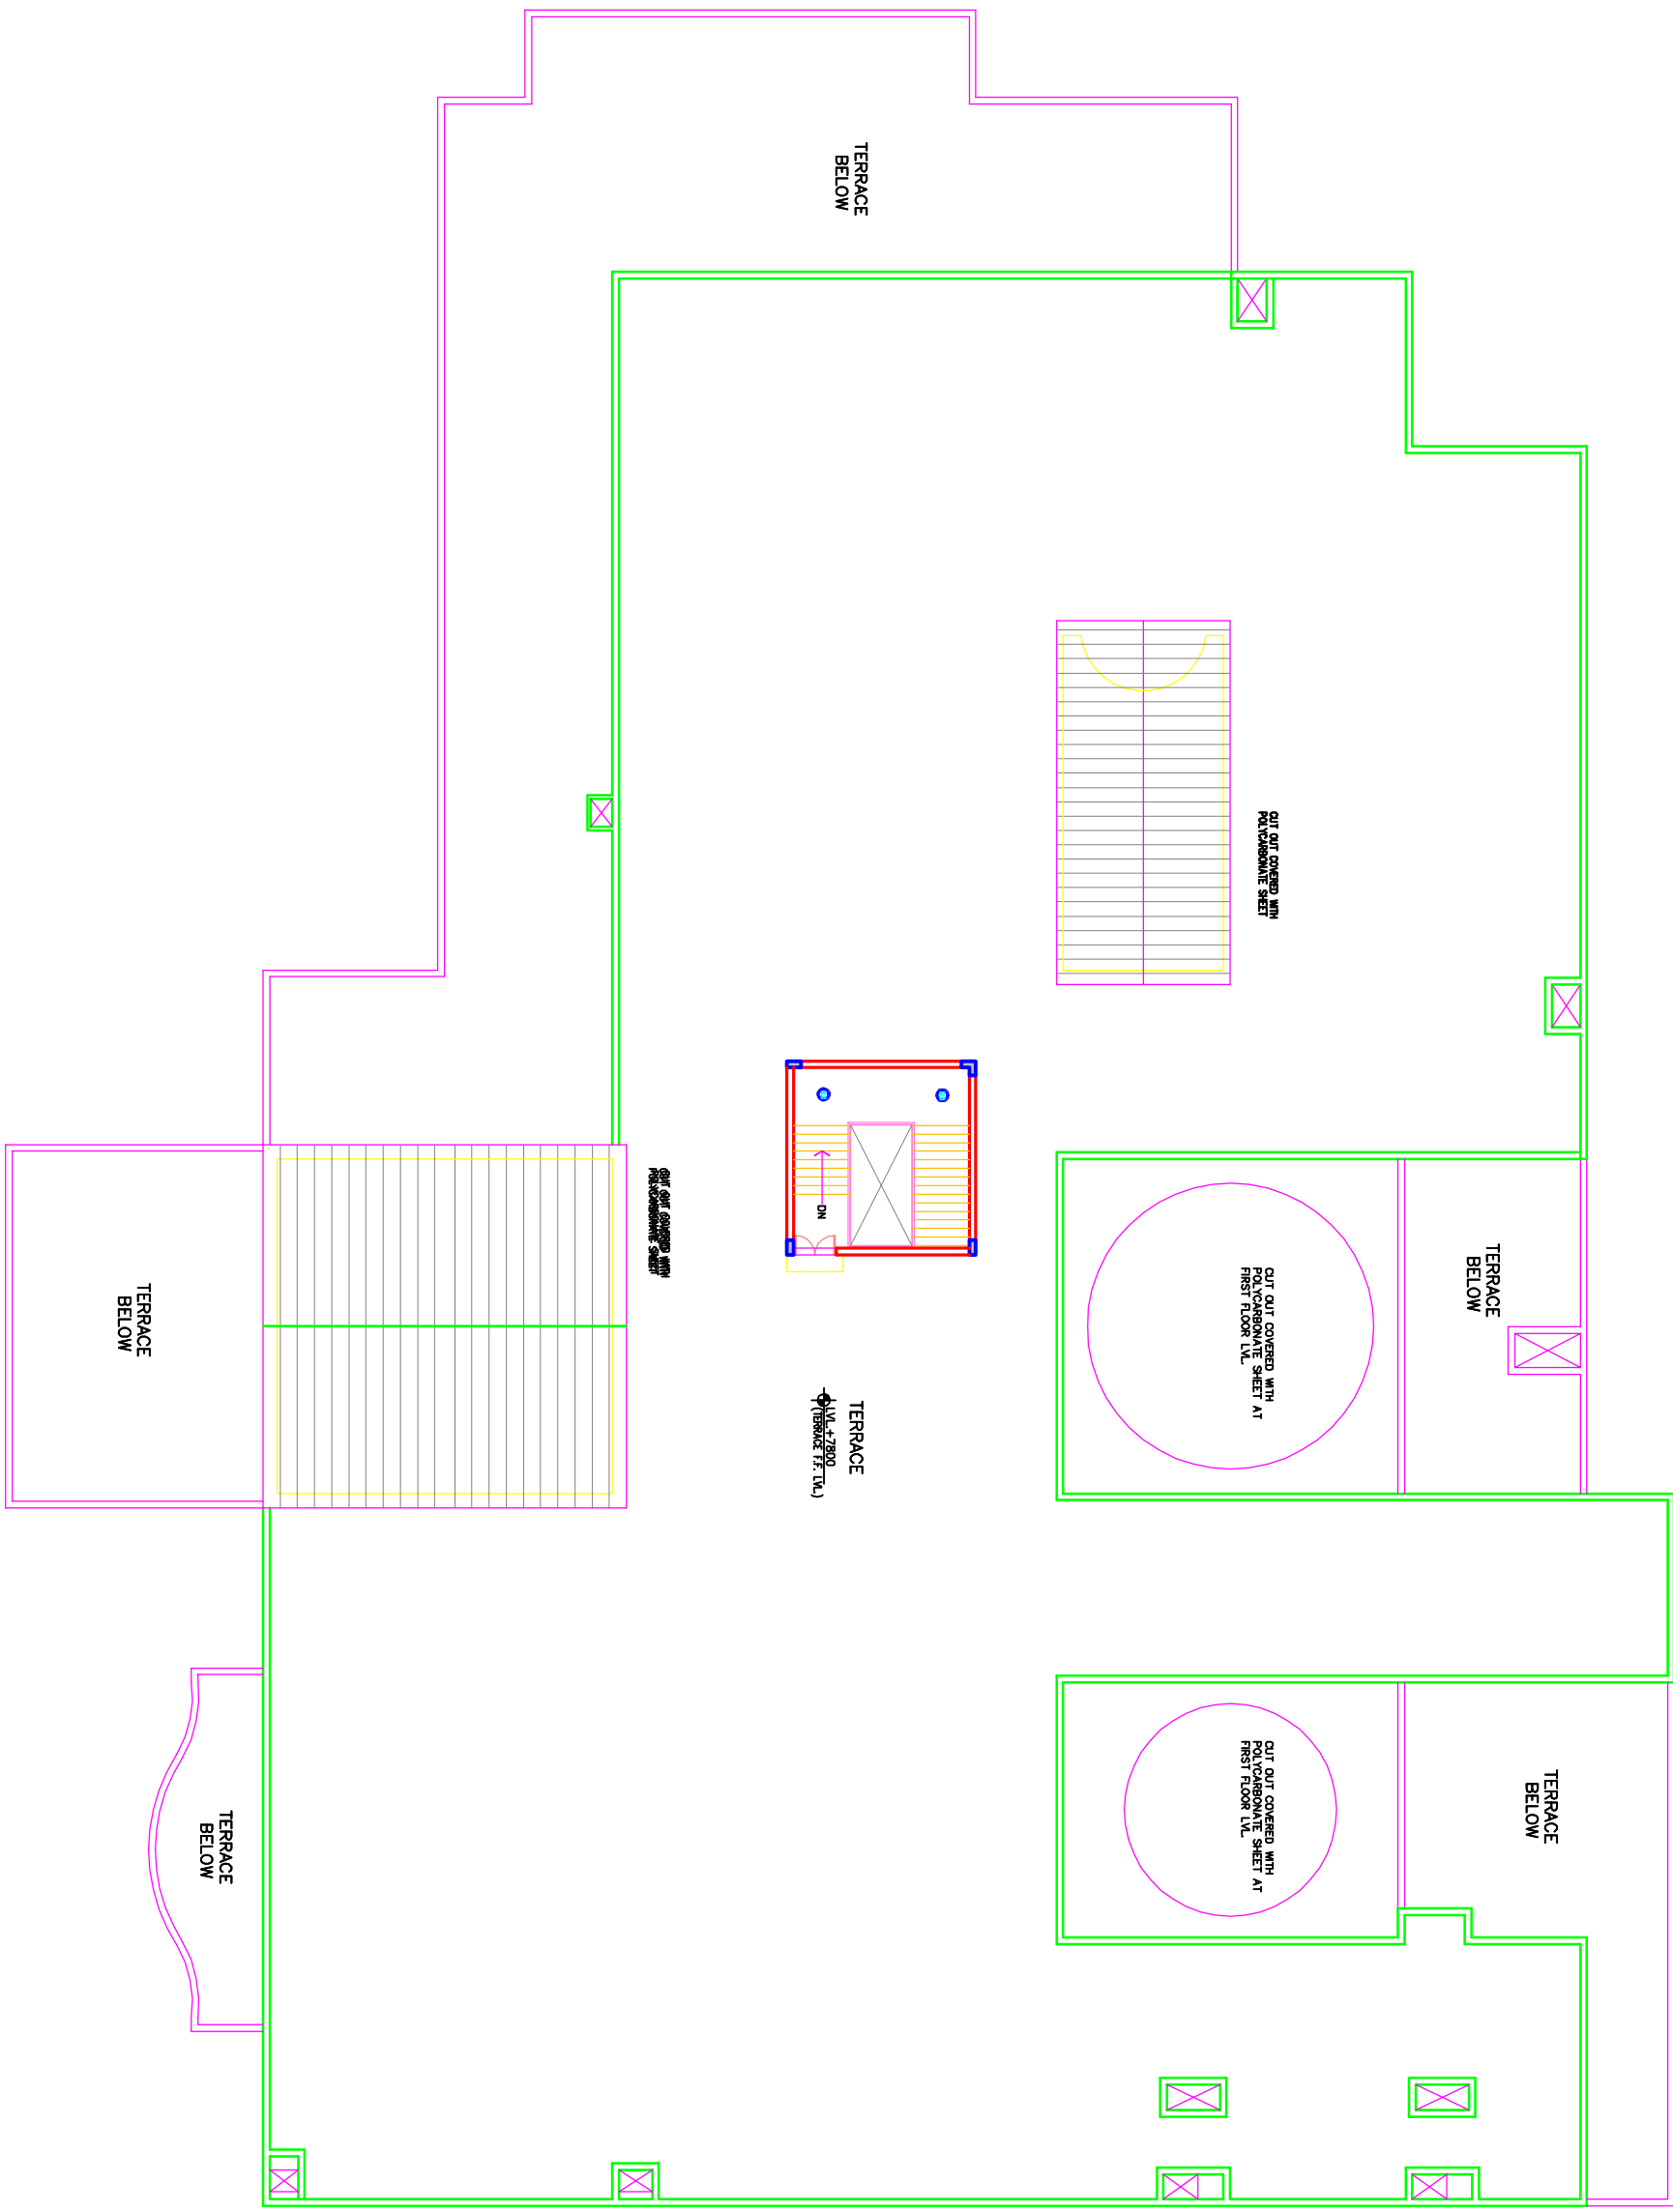

HVAC
DRAWINGS



NOTES

The drawing with all its contents is the sole intellectual property of the Institute of Health Care Consultants (India) Ltd. Copying of this drawing or part thereof for any purpose without the written permission of IHC is prohibited.

REV	DATE	DESCRIPTION

PROJECT

Proposed
100 Bedded Hospital
At CHHATTISGARH

TITLE


TENDER DRAWING
GROUND FLOOR PLAN
HVAC LAYOUT
(COVERED AREA=3022 SQ. MT.)

ESCCDAEHTYACNREHMCGAC-01	R-0
Drawing No.	
BSQC/-	1:125
Job No.	Scale
	25-03-2013
Date	
App by	Rev. by
	Prep. by

HSCC (INDIA) LIMITED
(A GOVERNMENT OF INDIA ENTERPRISE)

HSCC

NEW DELHI
INDIA

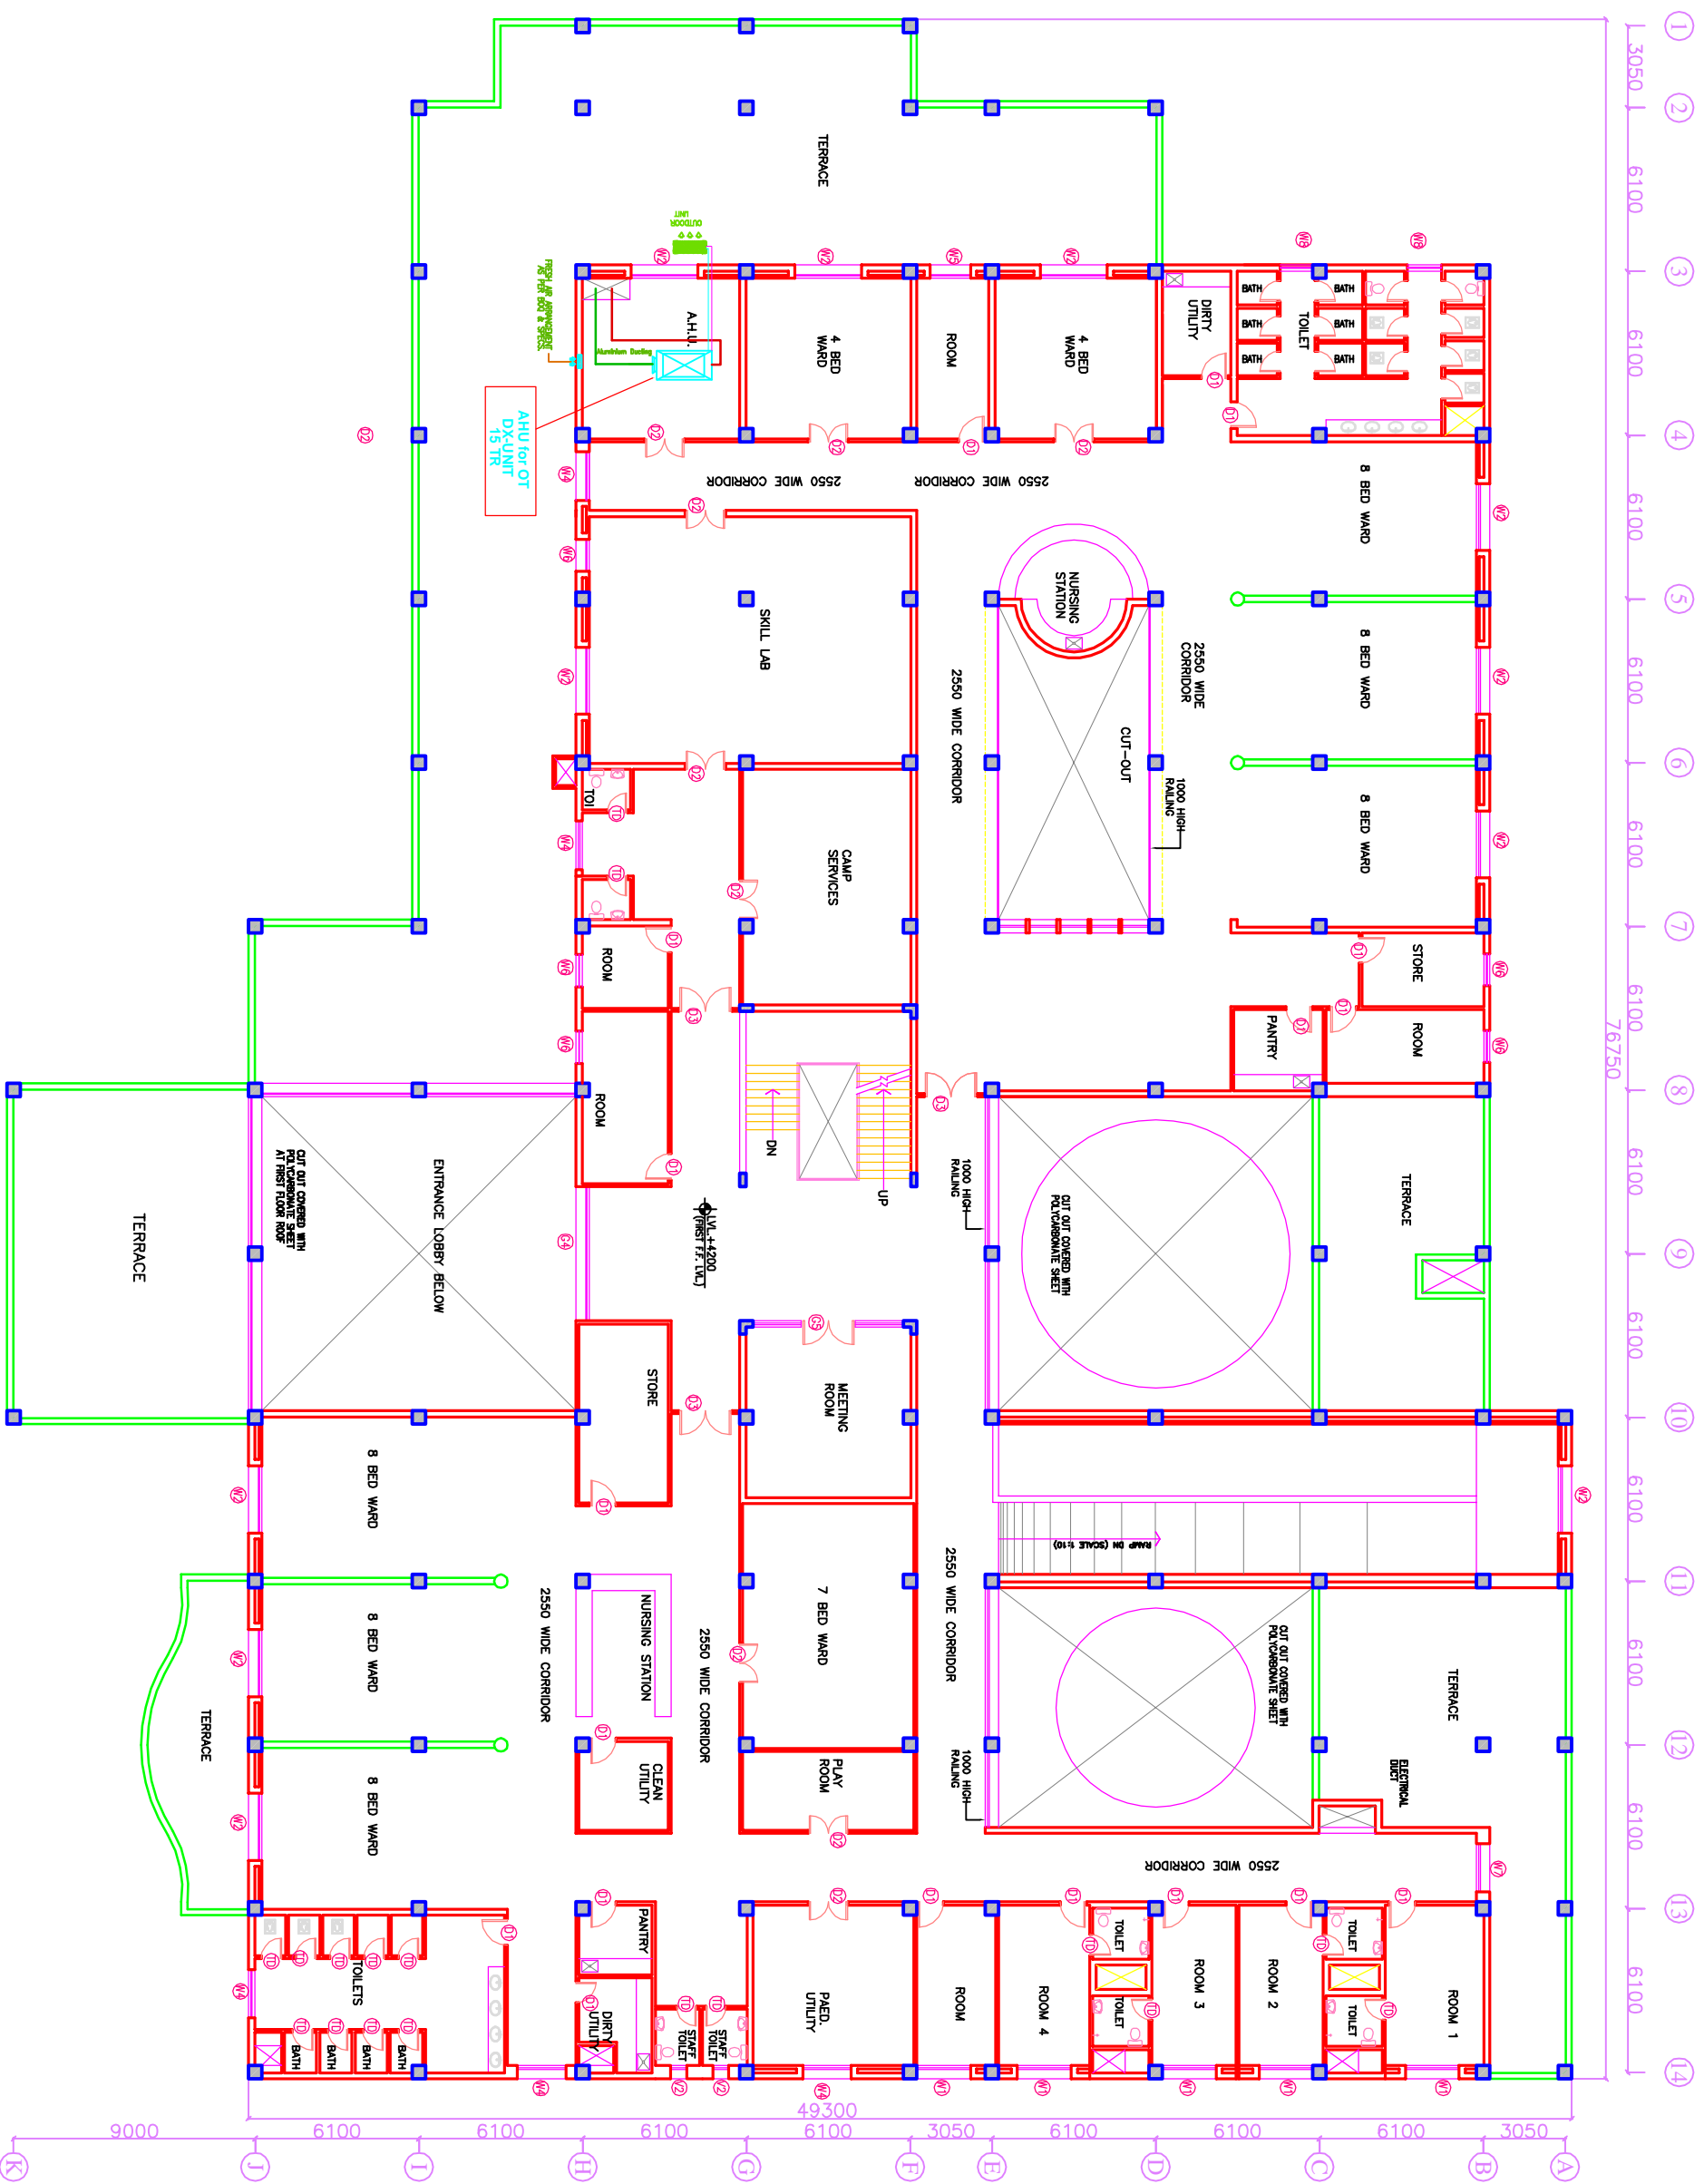

NOTES

The drawing with all its contents is the sole intellectual property of the Institute of Engineers (India) Ltd. Copying of this drawing or part thereof in any form or by any means without the written permission of IESCI is prohibited.

REV	DATE	DESCRIPTION

PROJECT

Proposed
100 Bedded Hospital
At CHHATISGARH

TITLE

TENDER DRAWING
FIRST FLOOR PLAN
HVAC LAYOUT
(COVERED AREA=2050 SQ. MT.)

ESCCD&E/HT/AC/ENR/HA/CG/AC-02	R-0
Drawing No.	
BS/CC/-	1:125
Job No.	Scale
	19-03-2013
	Date
App by	Rev. by
	Prep. by