


PHE & FIRE

DRAWINGS

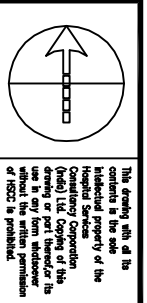

- NOTES**
1. DRAWINGS TO BE READ NOT MEASURED
 2. PARTITION WALL IN TOILETS UP TO LINTEL HEIGHT

LEGEND:

1	100 Ø CI SOIL & VENT PIPE
2	100Ø CI WASTE & VENT PIPE
3	100Ø CI SOIL PIPE
4	100Ø CI WASTE PIPE
5	50Ø GI / CPVC SOIL PIPE
6	40Ø GI / CPVC WASTE PIPE for lab, Urinal
7	32Ø GI / CPVC WASTE PIPE FOR W.B.
8	Ø CPVC UTW / DN TAKE
9	Ø CPVC TW / DN TAKE
10	100 Ø SW PIPE
11	100 Ø RW PIPE
12	100 Ø HDPE/LAB WASTE PIPE
13	50 Ø HDPE/LAB WASTE PIPE
FT	FLOOR TRAP 100x100
FD	FLOOR DRAIN 50Ø
FO	FLOOR CLEAN OUT
COF	CLEAN OUT PLUG
⊗	VALVE
MH	MANHOLE (900x600)mm
GT	GULLY TRAP (300x300)mm

REVISION	DESCRIPTION

PROJECT
PROPOSED
100 BEDDED HOSPITAL

**RMNCH PROJECT,
CHATTISGARH**


**TITLE PLUMBING
TENDER DRAWING**

**GROUND
FLOOR PLAN**

HSCC/D&E/TD/RMNC/PL-01	Rev.
Drawing No.	
Job No.	1-300
Scale	As per site condition for the approval of HSCC BEFORE START OF WORK.
App By	RITAGI
Rev. By	R.SUR
Prep. by	S.BHAI
Date	06-04-2013


HSCC (INDIA) LIMITED
(A GOVERNMENT OF INDIA ENTERPRISE)
HSCC
INDIA

NEW DELHI

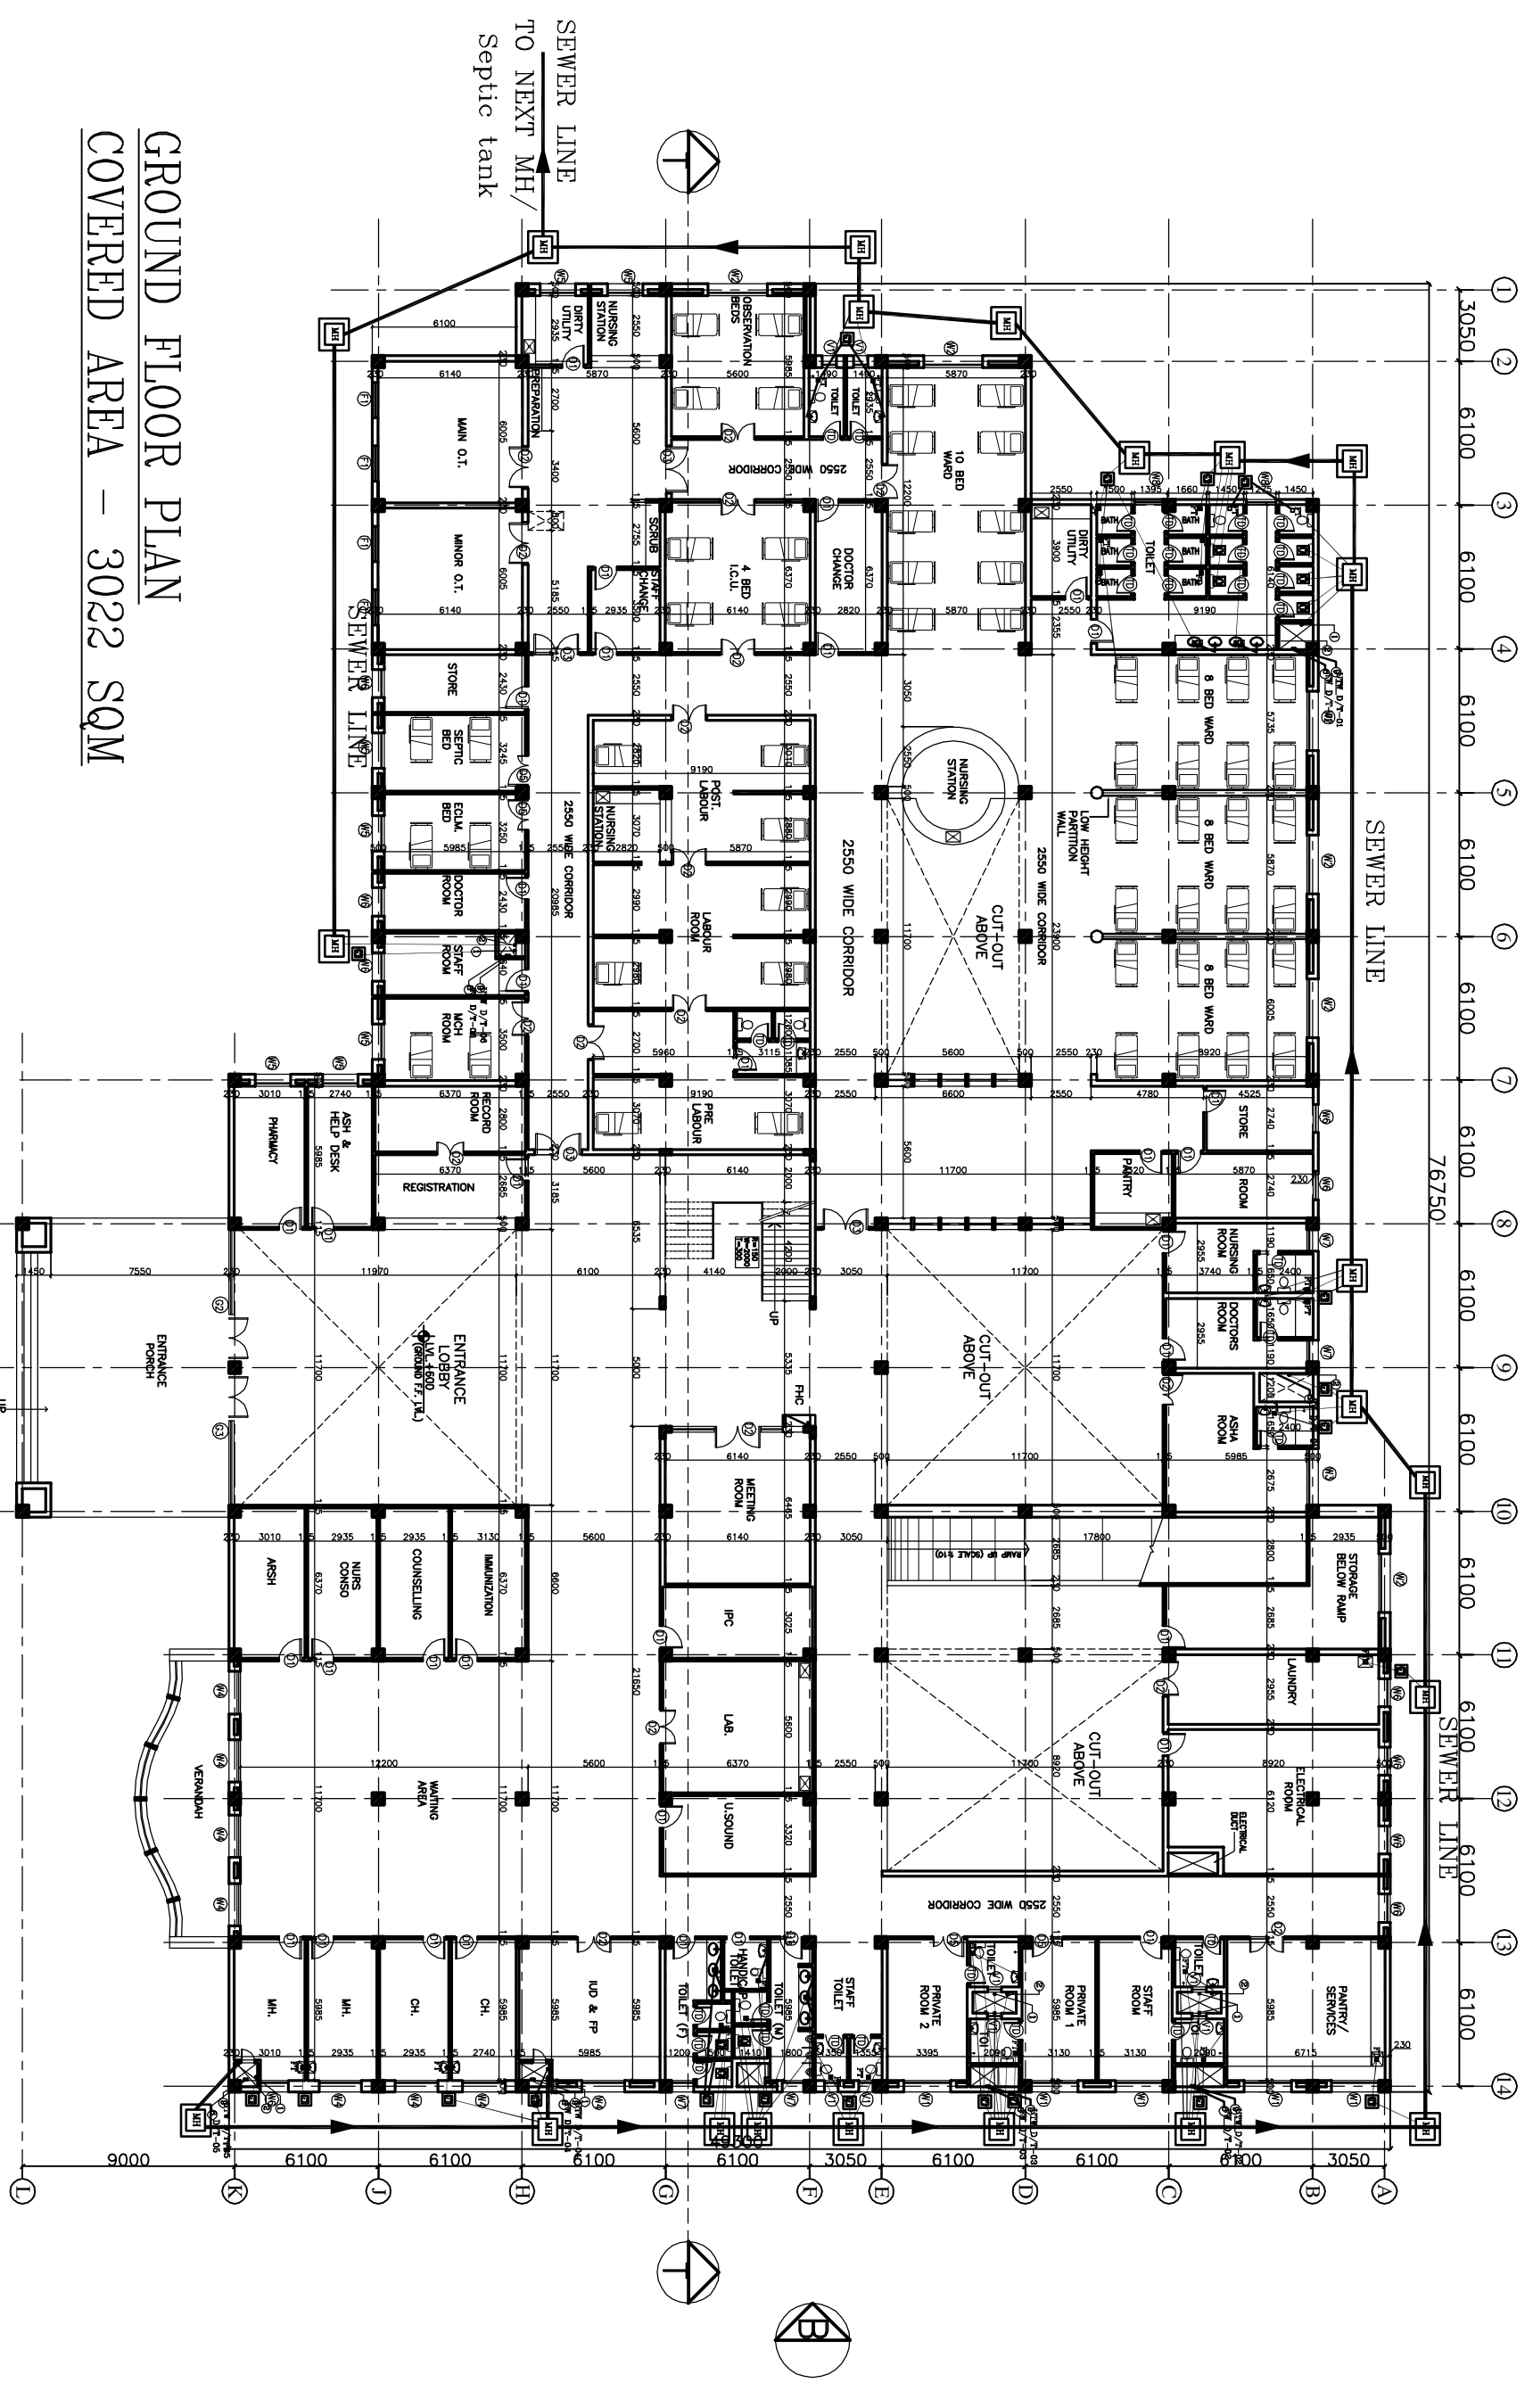

**GROUND FLOOR PLAN
COVERED AREA - 3022 SQM**

- NOTES**
1. BASED ON THIS DRAWING EXECUTING AGENCY WILL PREPARE SHOP DRAWING AFTER INCORPORATING THE CHANGES AS PER SITE CONDITION FOR THE APPROVAL OF HSCC BEFORE START OF WORK.
 2. THE NUMBER & LOCATION OF FIXTURES & WET POINT TO BE FINALIZED BEFORE EXECUTION WITH CLINT OFFICER'S INCHARGE..

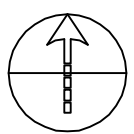

This drawing with all its contents is the sole intellectual property of the Consulting Engineer (India) Ltd. Copying of this drawing or part thereof in any form or by any means without the written permission of HSCC is prohibited.

- NOTES**
1. DRAWINGS TO BE READ NOT MEASURED
 2. PARTITION WALL IN TOILETS UP TO UNTEL HEIGHT

LEGEND:

1	100 Ø CI SOIL & VENT PIPE
2	100Ø CI WASTE & VENT PIPE
3	100Ø CI SOIL PIPE
4	100Ø CI WASTE PIPE
5	50Ø GI/CPVC SOIL PIPE
6	40Ø GI/CPVC WASTE PIPE for Sk.Utlia
7	32Ø GI/CPVC WASTE PIPE FOR W.A.
8	Ø CPVC UTW/DN. TAKE
9	Ø CPVC TW/DN.TAKE
10	100 Ø S.W. PIPE
11	100 Ø R.W. PIPE
12	100 Ø HDPE/LAB WASTE PIPE
13	50 Ø HDPE/LAB WASTE PIPE
FD	FLOOR DRAIN 50Ø
FT	FLOOR TRAP 100x100
FOO	FLOOR CLEAN OUT
COF	CLEAN OUT PLUG
☒	VALVE
MH	MANHOLE (900x900)mm
GT	GULLY TRAP(300x300)mm

REVISION	DESCRIPTION


PROJECT
 PROPOSED
 100 BEDDED HOSPITAL

**RMNCH PROJECT,
 CHATTISGARH**

**TITLE PLUMBING
 TENDER DRAWING
 FIRST
 FLOOR PLAN**

HSCC/D&E/TD/RMNC/PL-02	Rev
Drawing No.	
Job No.	1:300
Scale	05-04-2013
Date	
App by	R.TAGI
Rev. by	R.SUR
Prep. by	S.BHATT


HSCC (INDIA) LIMITED
 (A GOVERNMENT OF INDIA ENTERPRISE)
HSCC
 NEW DELHI INDIA

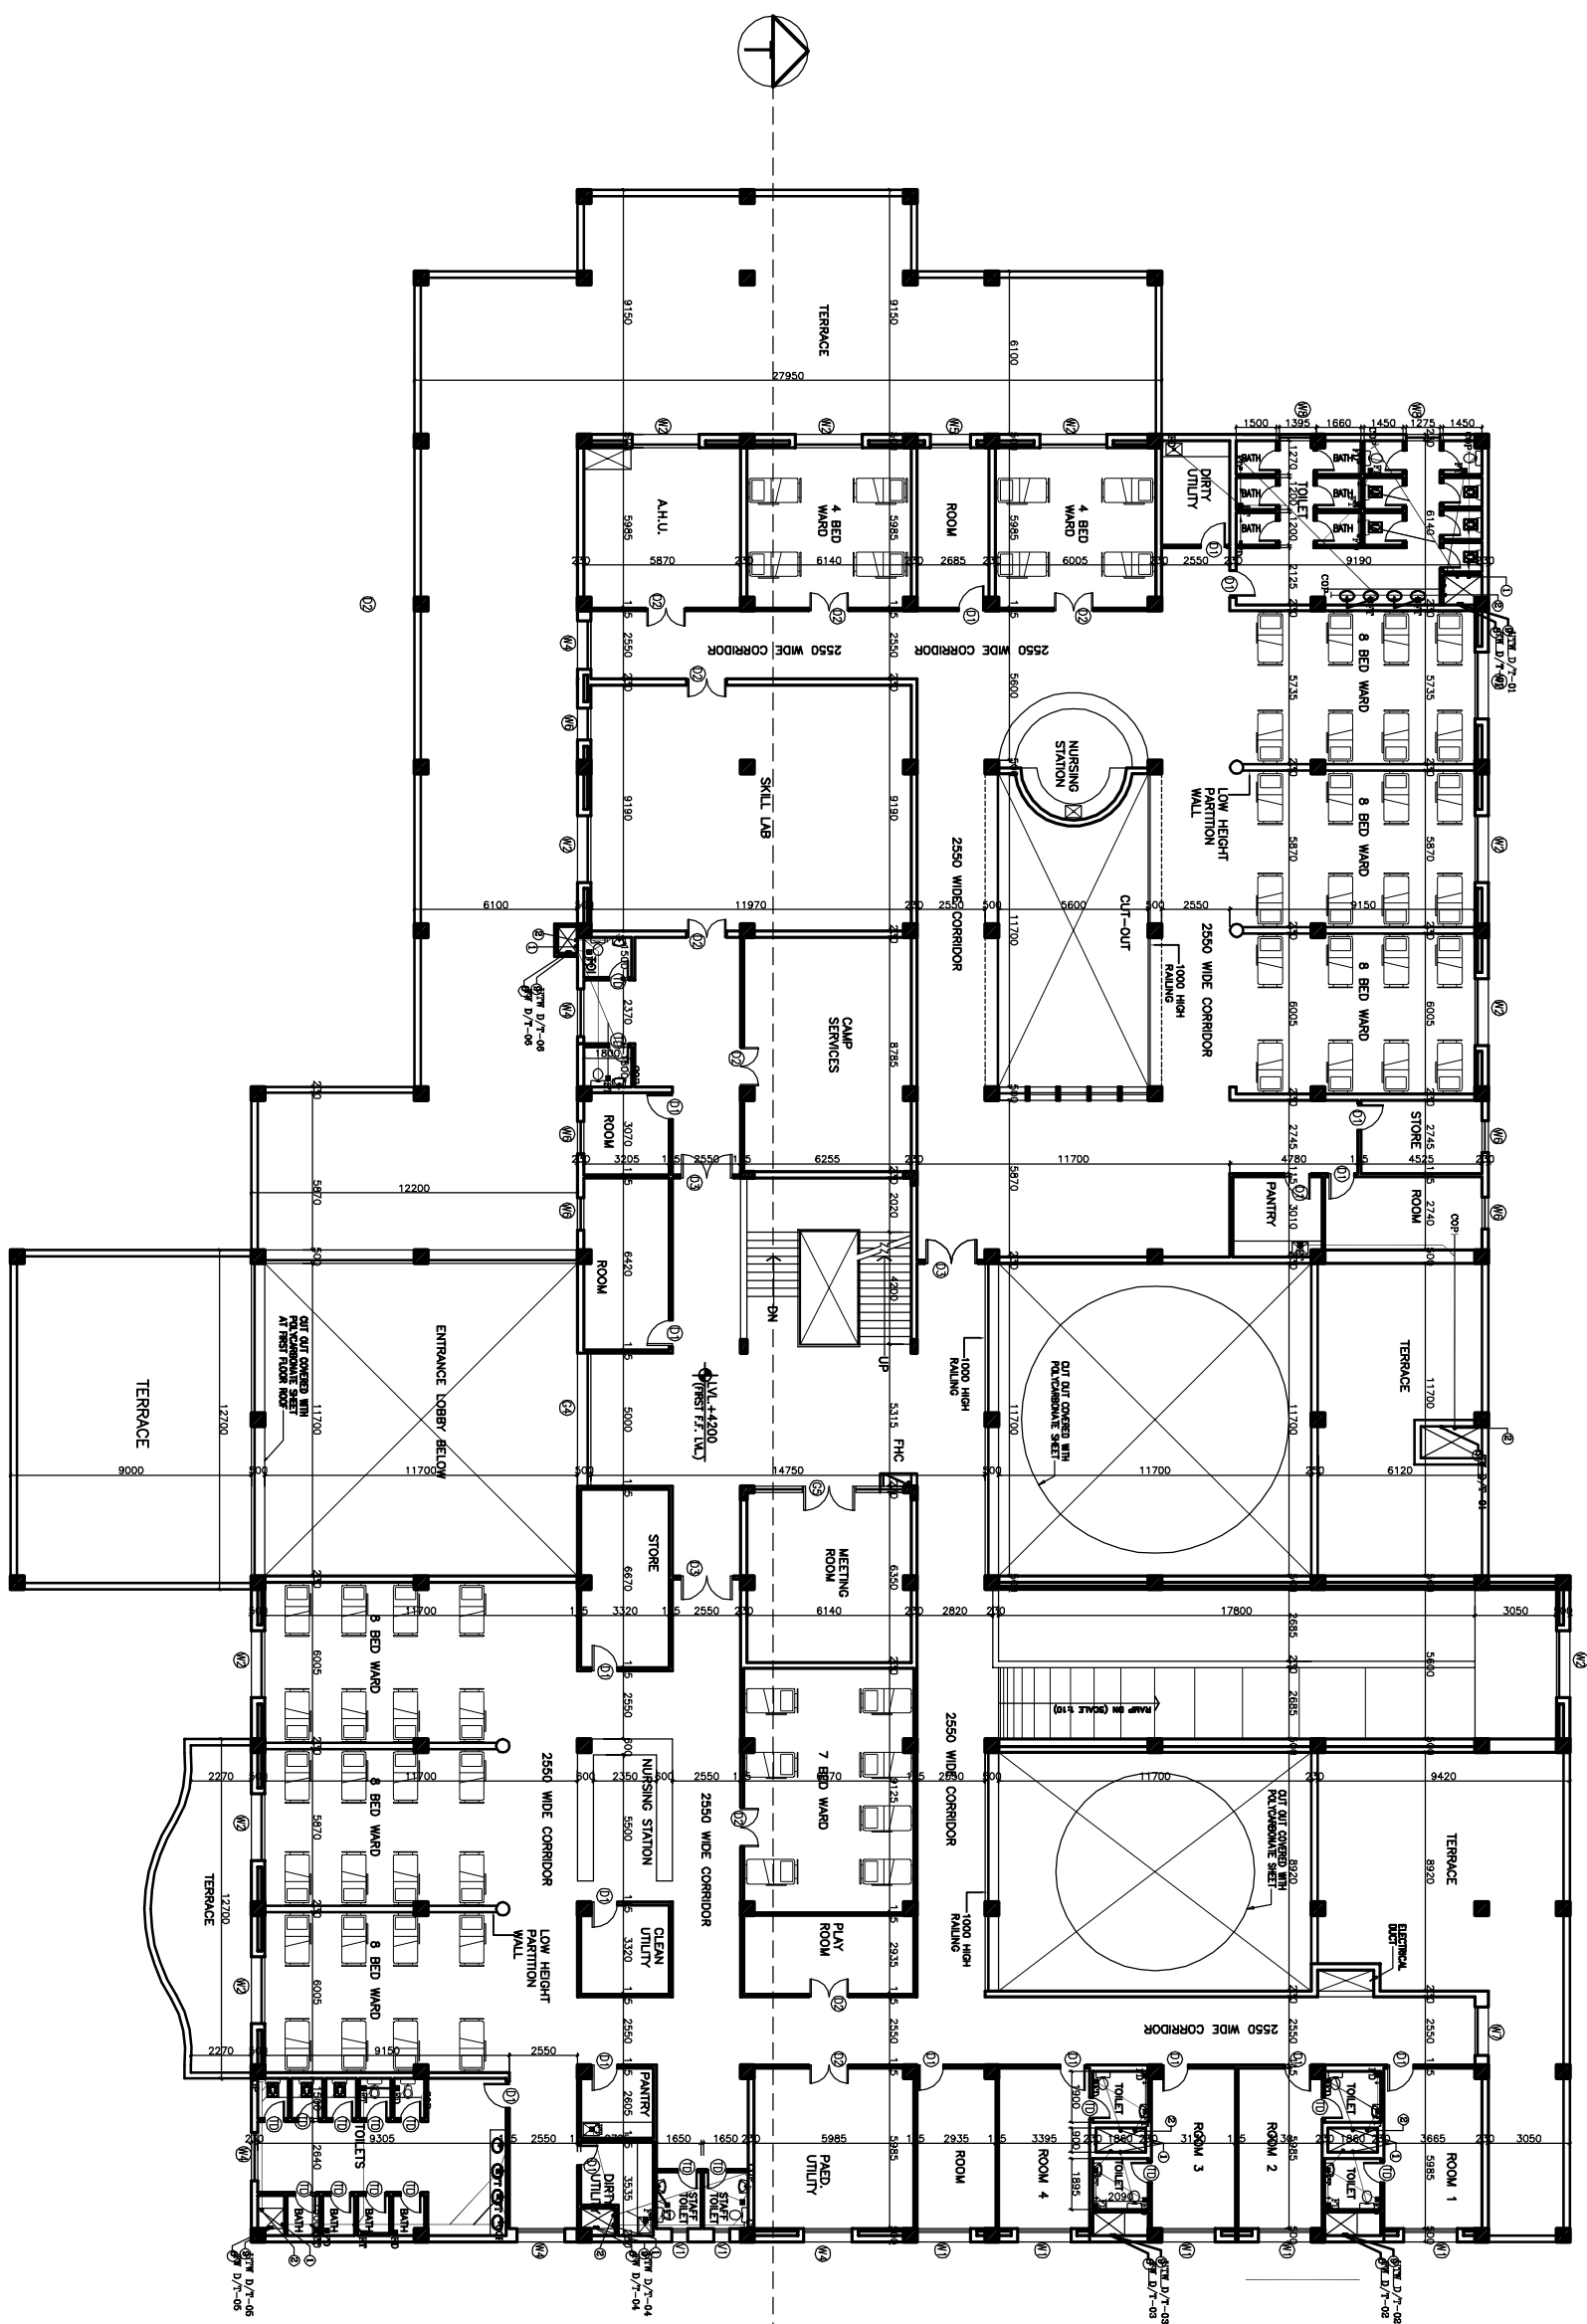

**FIRST FLOOR PLAN
 COVERED AREA – 2050 SQM**



- NOTES**
1. BASED ON THIS DRAWING EXECUTING AGENCY WILL PREPARE SHOP DRAWING AFTER INCORPORATING THE CHANGES AS PER SITE CONDITION FOR THE APPROVAL OF HSCC BEFORE START OF WORK.
 2. THE NUMBER & LOCATION OF FIXTURES & WET POINT TO BE FINALIZED BEFORE EXECUTION WITH CLINT OFFICER'S INCHARGE..

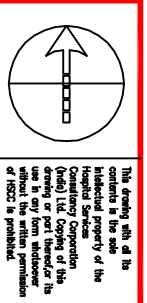

This drawing, with all the contents in the same, is the Intellectual Property of the Consulting Corporation (Iqbal) Ltd. Copying of this drawing or part thereof for any purpose without the written permission of HSCC is prohibited.

- NOTES**
- DRAWINGS TO BE READ NOT MEASURED
 - PARTITION WALL IN TOILETS UP TO LINTEL HEIGHT

LEGEND:

1	100 Ø CI SOIL & VENT PIPE
2	100Ø CI WASTE & VENT PIPE
3	100Ø CI SOIL PIPE
4	100Ø CI WASTE PIPE
5	50Ø ØI CPVC SOIL PIPE
6	40Ø ØI CPVC WASTE PIPE FOR URINAL LAB/SINK
7	32Ø ØI CPVC WASTE PIPE FOR W.B.
8	Ø CPVC UTW/DN TAKE
9	Ø CPVC TW/DN TAKE
10	100 Ø S.W. PIPE
11	100 Ø R.W. PIPE
12	100 Ø HDPE LAB WASTE PIPE
13	5Ø HDPE LAB WASTE PIPE
FT	FLOOR TRAP 100x100
FD	FLOOR DRAIN 50Ø
FO	FLOOR CLEAN OUT
COF	CLEAN OUT FLUG
✕	VALVE
MH	MANHOLE (900x900)mm
GT	GULLY TRAP (300x300)mm

REVISION	DESCRIPTION

PROJECT
PROPOSED
100 BEDDED HOSPITAL


**RMNCH PROJECT,
CHATTISGARH**

**TITLE PLUMBING
TENDER DRAWING**

**TERRACE
FLOOR PLAN**

HSCC/D&E/TD/RMNCH/PL-03

Drawing No.	1:300	Rev.	06-04-2013
Job No.	Scale	Date	
App. By	R.TYAGI	Rev. By	R.SUR
		Prep. by	S.BHAI

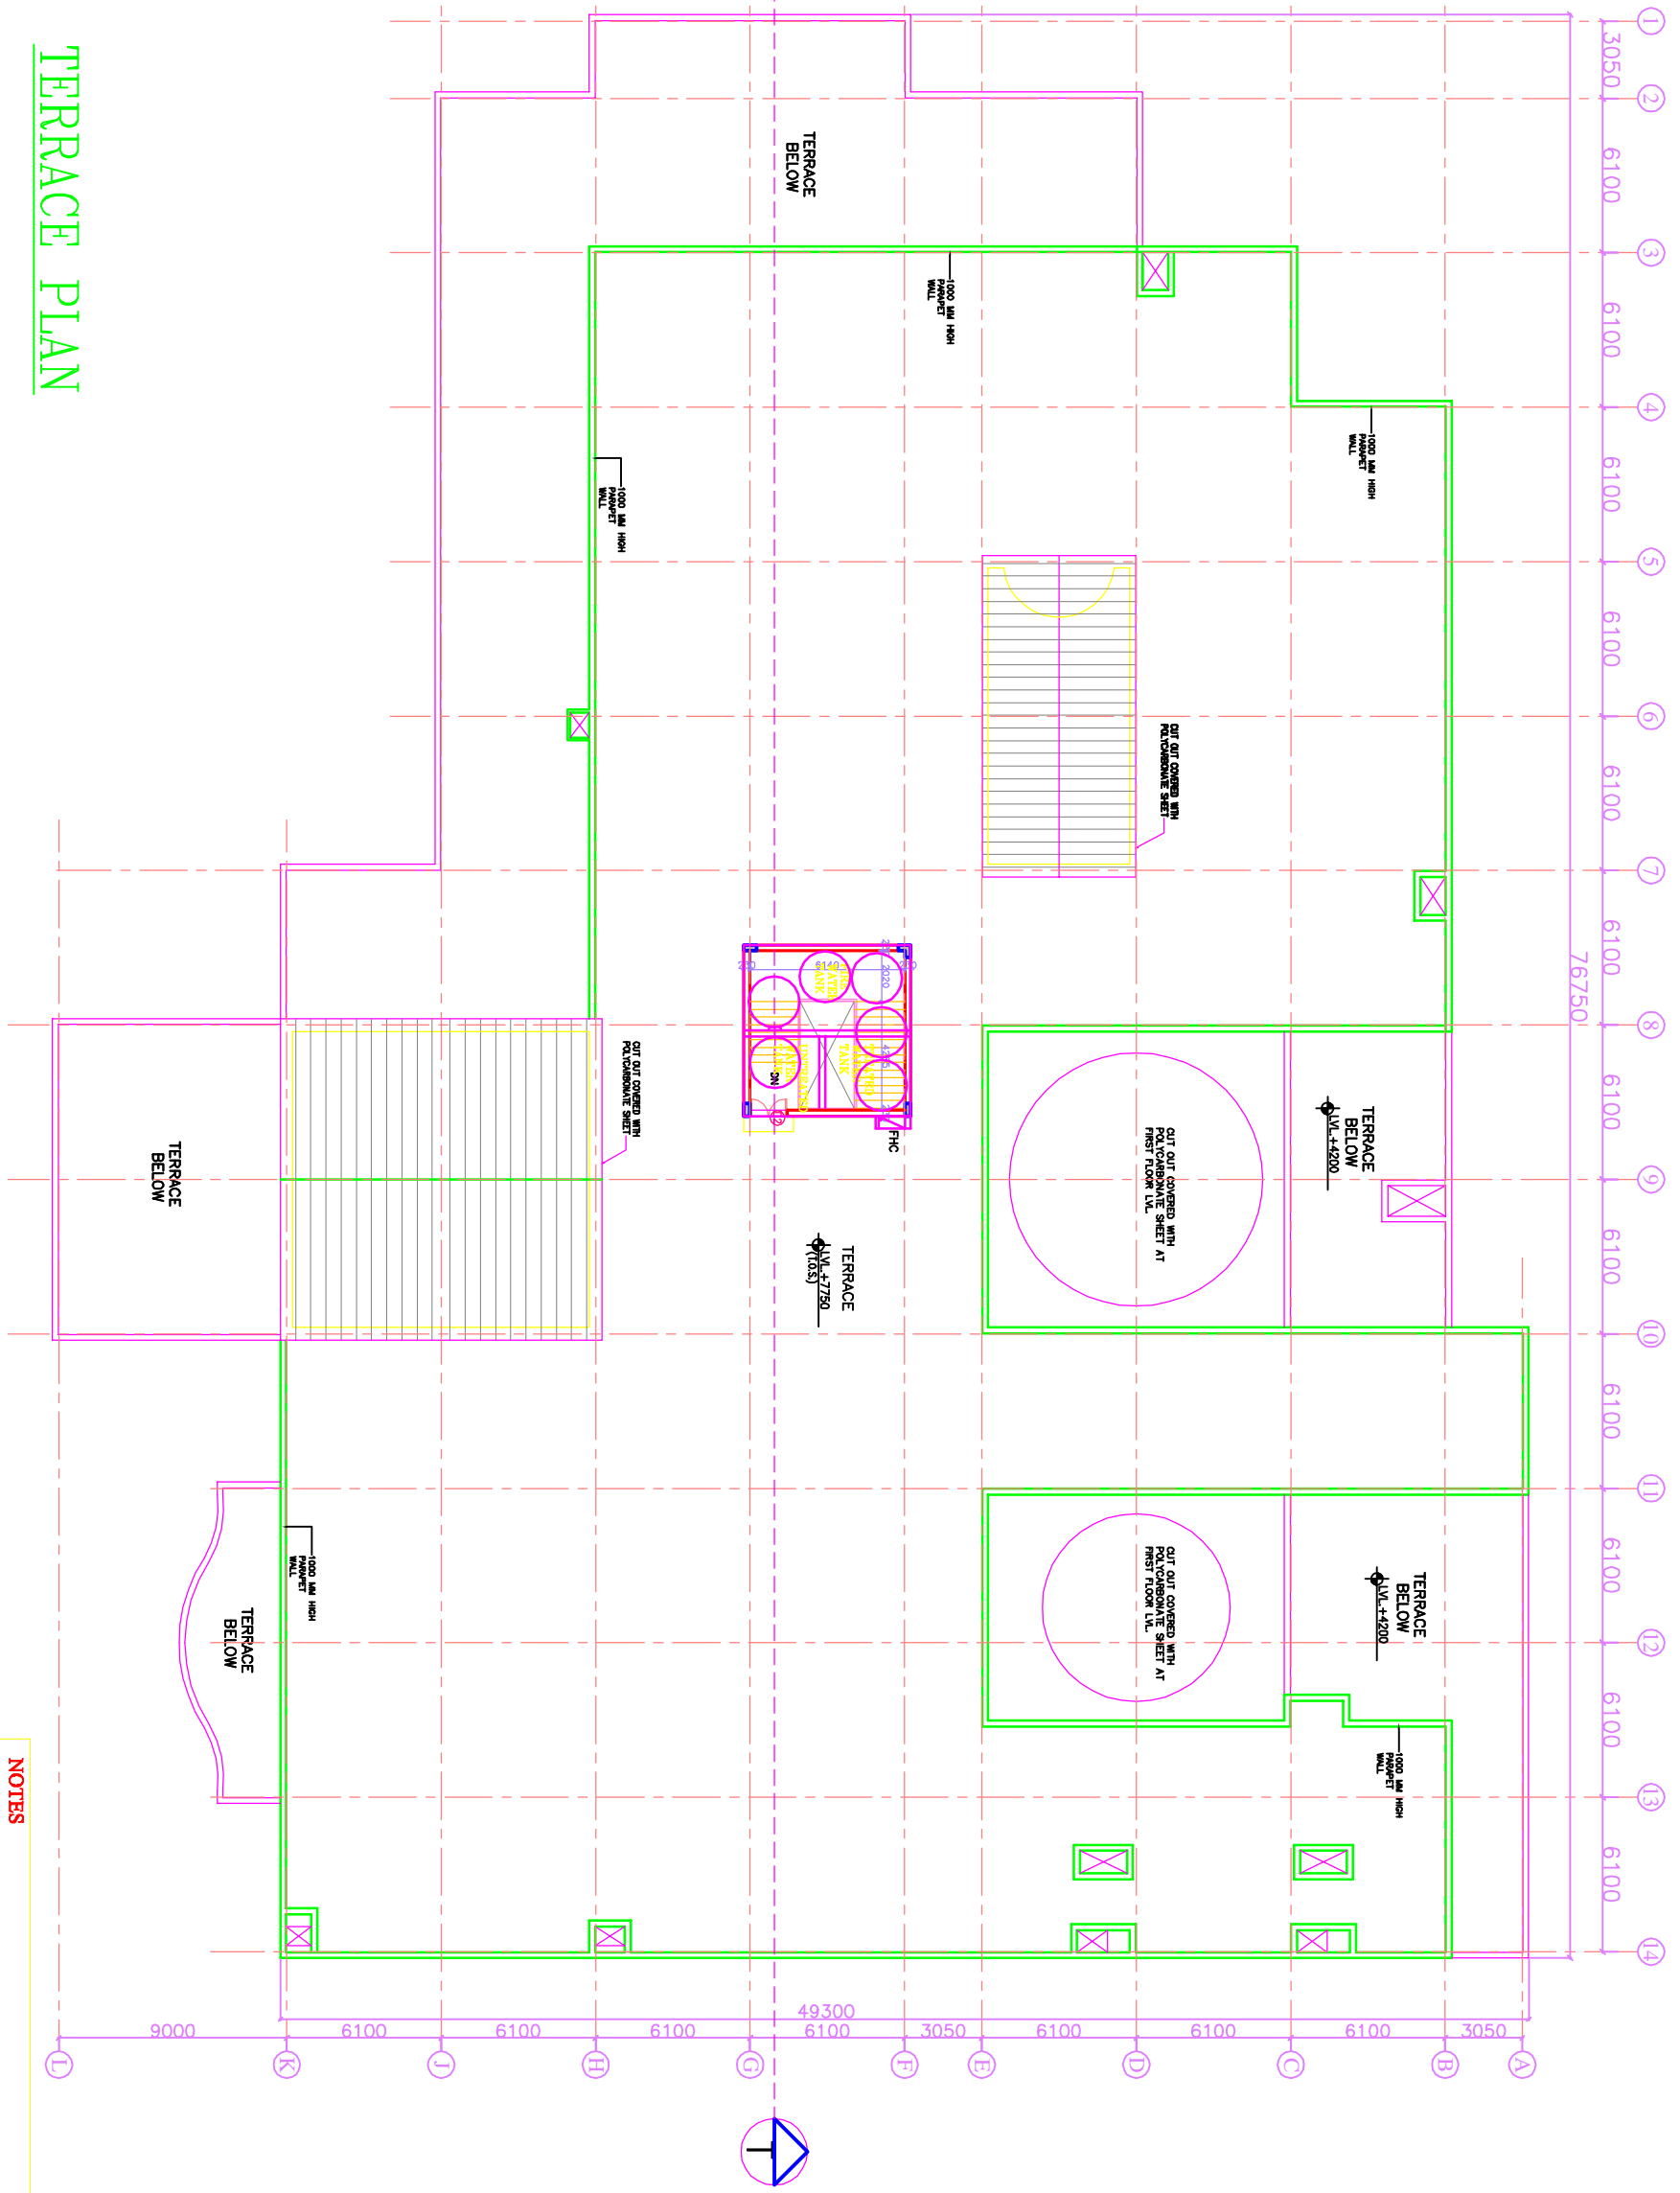

TERRACE PLAN


- NOTES**
- BASED ON THIS DRAWING EXECUTING AGENCY WILL PREPARE SHOP DRAWING AFTER INCORPORATING THE CHANGES AS PER SITE CONDITION FOR THE APPROVAL OF HSCC BEFORE START OF WORK.
 - THE NUMBER & LOCATION OF FIXTURES & WET POINT TO BE FINALIZED BEFORE EXECUTION WITH CLINT OFFICER'S INCHARGE..

ELECTRICAL

DRAWINGS

This drawing with all its contents is the sole intellectual property of the HSCC (INDIA) LIMITED (A GOVERNMENT OF INDIA ENTERPRISE) (Incorporated under the Companies Act, 1956) and shall remain the property of HSCC (INDIA) LIMITED. No part of this drawing shall be reproduced, stored in a retrieval system, or transmitted in any form or by any means, electronic, mechanical, photocopying, recording, or otherwise, without the written permission of HSCC (INDIA) LIMITED.

NOTES

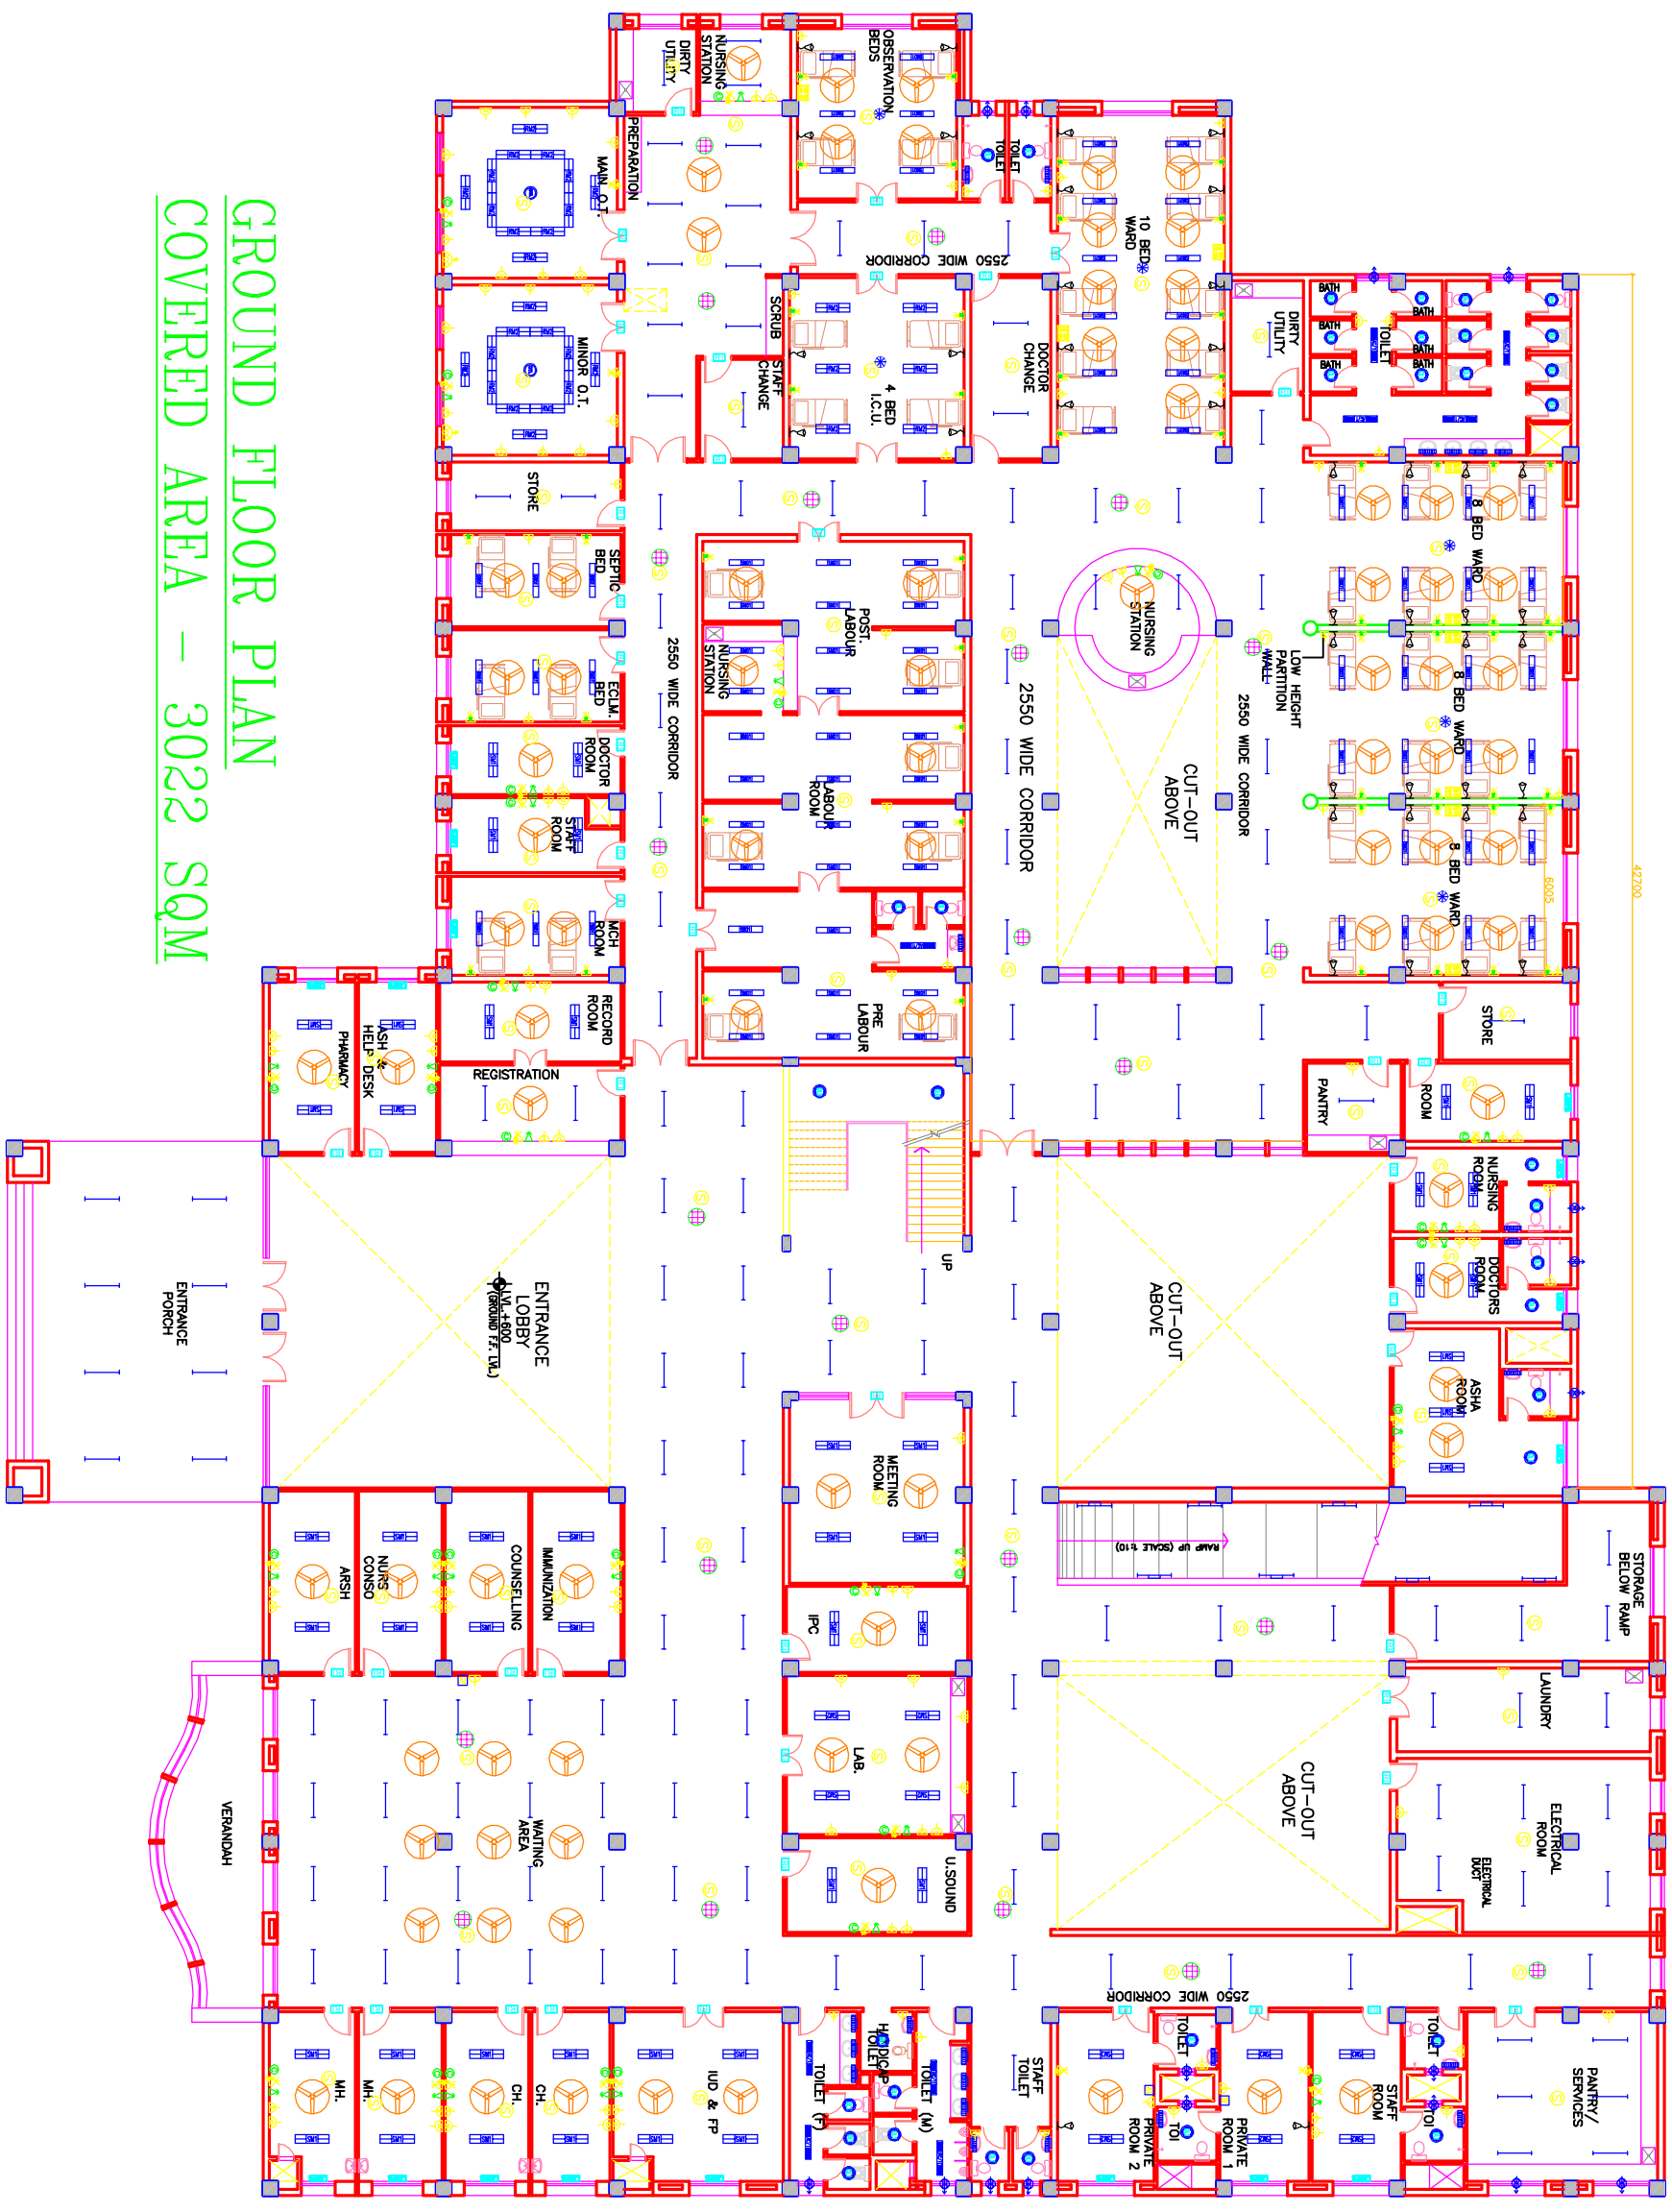


**GROUND FLOOR PLAN
COVERED AREA – 3022 SQM**

REV. DATE		DESCRIPTION	
PROJECT			
RMNCH PROJECT			
Proposed			
100 Bedded Hospital			
AT			
CHATTISGARH			
TITLE			
MODEL PLANS			
GROUND			
FLOOR PLAN			
ELECTRICAL LAYOUT			
(COVERED AREA=3022 SQ. MT.)			
HSCC/INDIA/DEL-101		R-0	
Drawing No.		Rev.	
HSCC/-		NTS	
Job No.		Scale	
		Date	
App by		Rev. by	
		Prep. by	

This drawing with all its contents is the sole intellectual property of the HSCC (INDIA) LIMITED (a Government of India Enterprise). Any use or part thereof for any purpose without the written permission of HSCC is prohibited.

NOTES

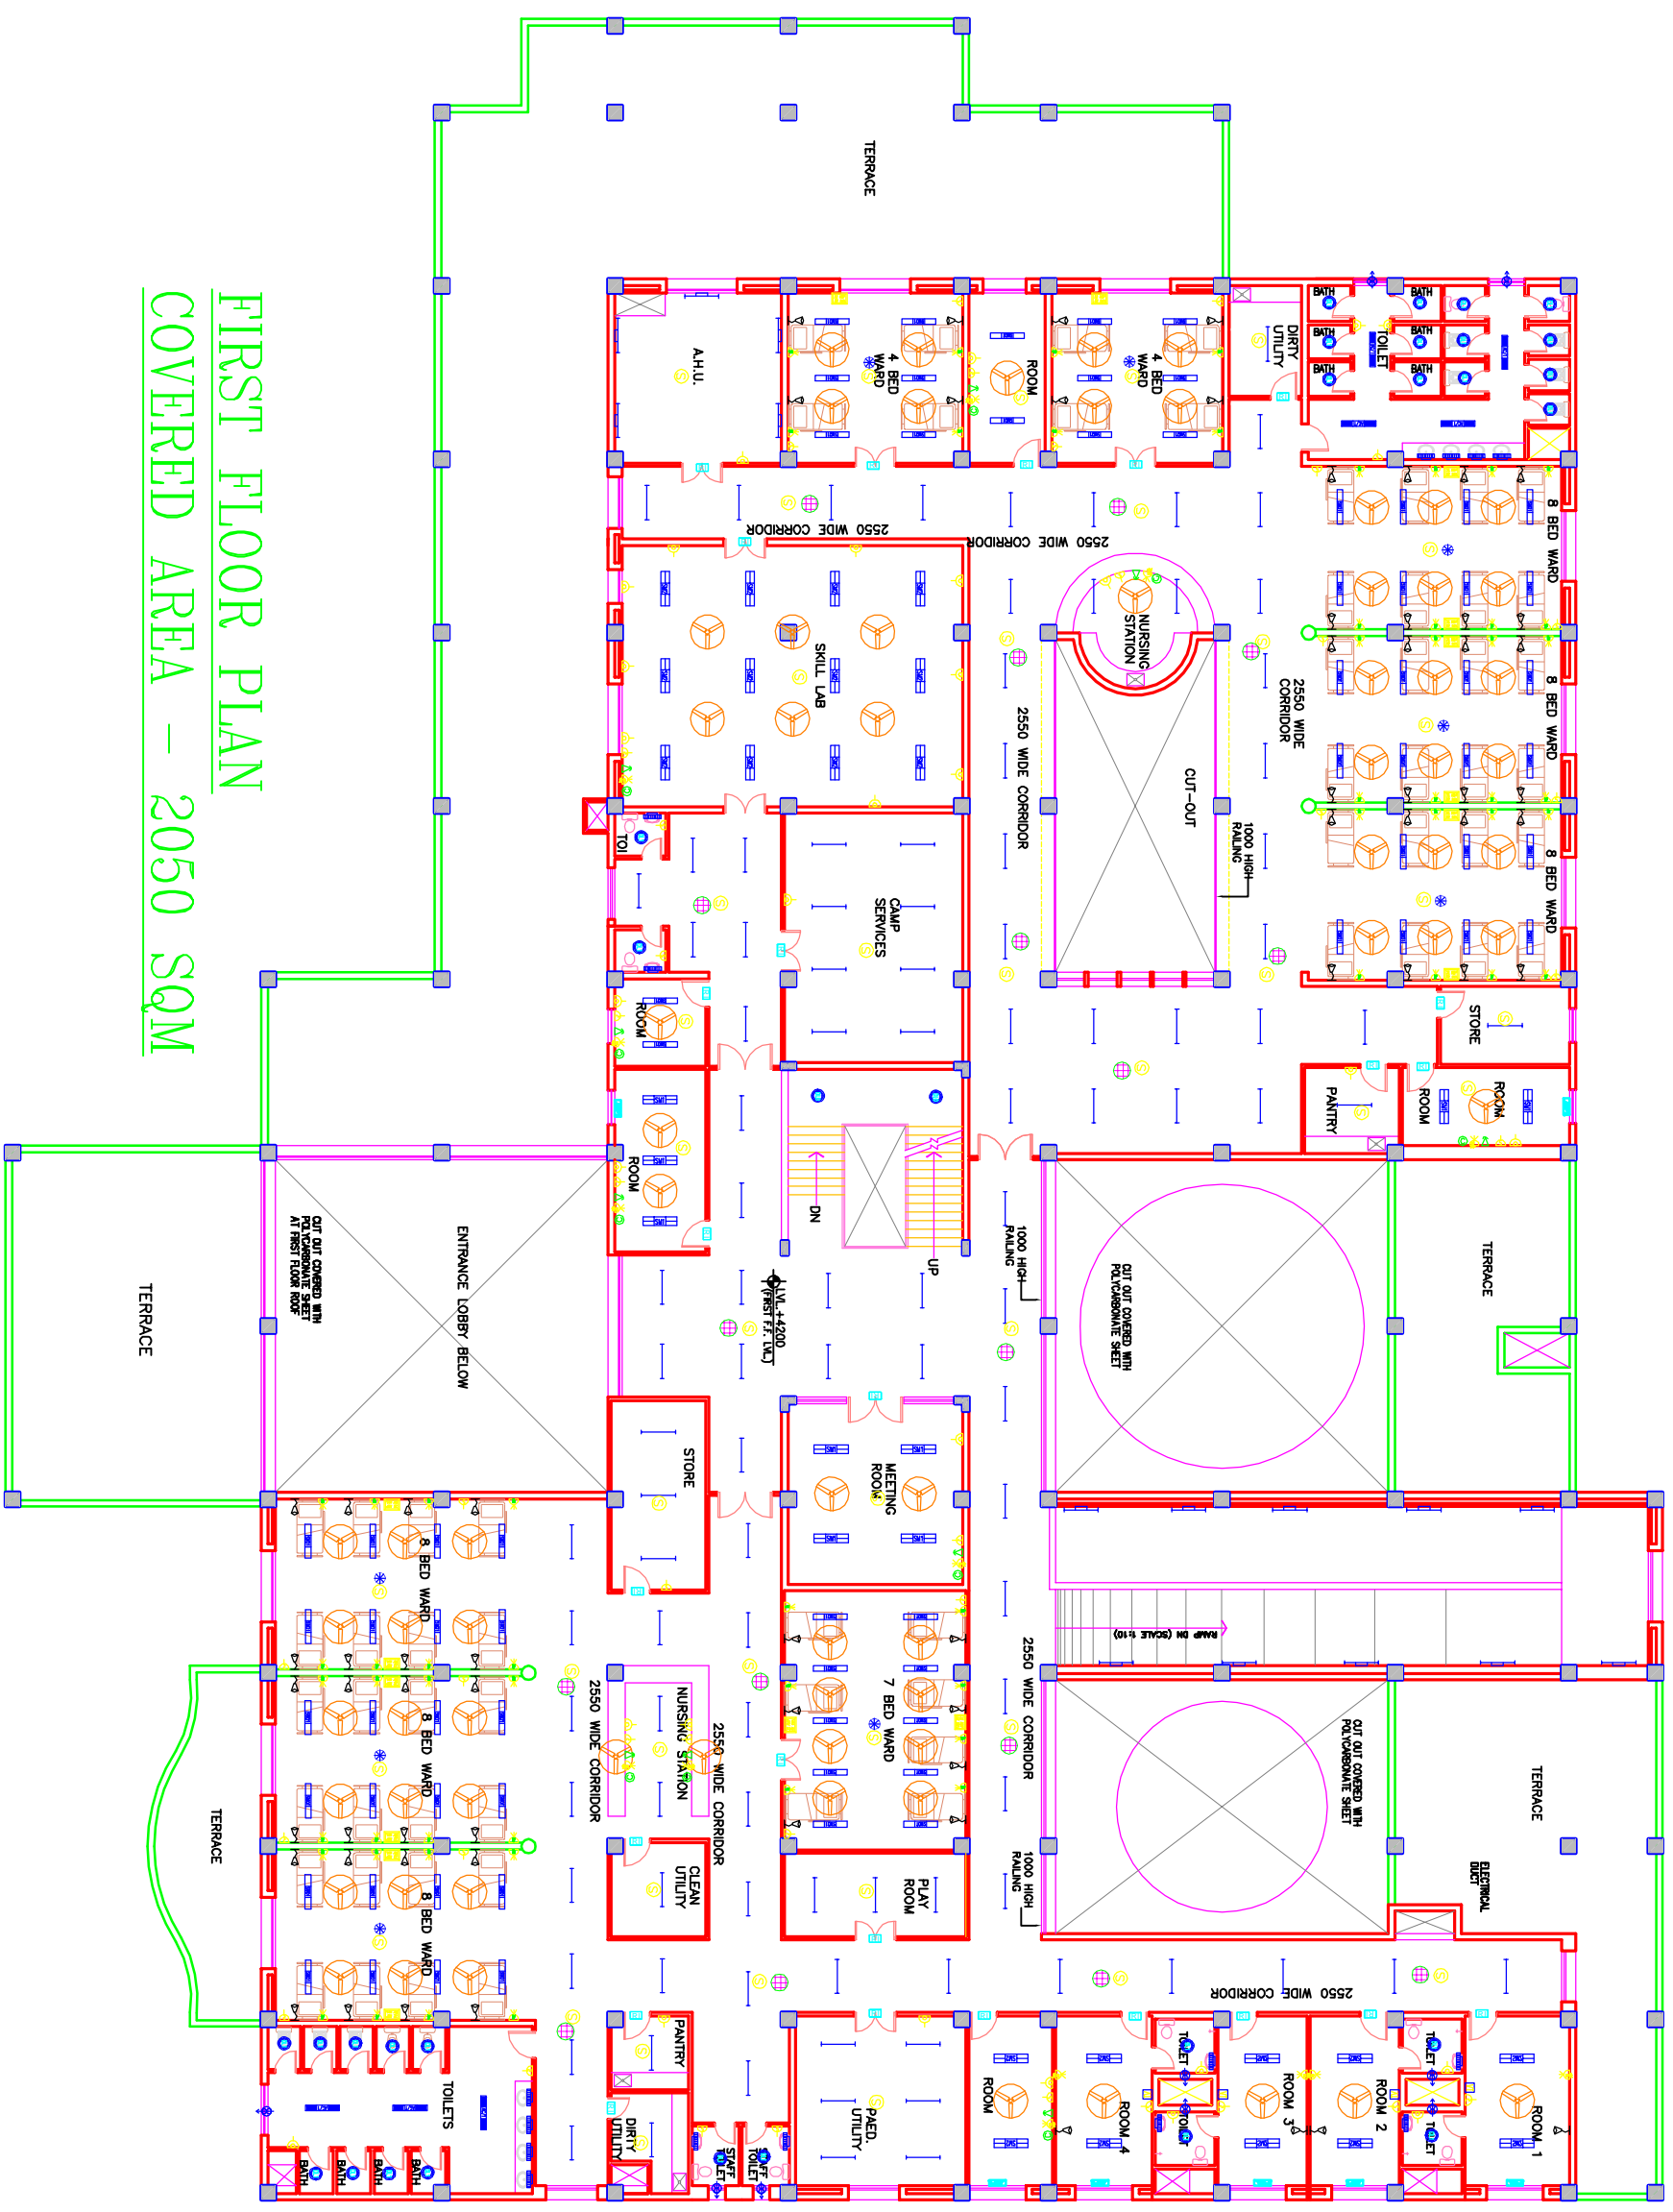


FIRST FLOOR PLAN
COVERED AREA – 2050 SQM

<p>PROJECT RMNCH PROJECT Proposed 100 Bedded Hospital AT CHATTISGARH</p>		<p>TITLE MODEL PLANS FIRST FLOOR PLAN ELECTRICAL LAYOUT (COVERED AREA=2050 SQ. MT.)</p>	
<p>REV. DATE</p>	<p>DESCRIPTION</p>	<p>HSRCC/— Job No.</p>	<p>NTS Scale</p>
<p>REV.</p>	<p>DATE</p>	<p>HSRCC/08&E/TD/DEL-102 Drawing No.</p>	<p>R-0 Rev.</p>
<p>App by</p>	<p>Rev. by</p>	<p>Prep. by</p>	<p>App by</p>

This drawing with all its contents is the sole intellectual property of the Haryana State Civil Services Commission (HSCC) and shall remain the property of the Commission. No part of this drawing may be reproduced, stored in a retrieval system, or transmitted in any form or by any means, electronic, mechanical, photocopying, recording, or by any information storage and retrieval system, without the written permission of HSCC is prohibited.

NOTES

<p>PROJECT RMNCH PROJECT Proposed 100 Bedded Hospital AT CHATTISGARH</p>		<p>TITLE MODEL PLANS TERRACE PLAN ELECTRICAL LAYOUT</p>	
<p>REV. DATE DESCRIPTION</p>	<p>REVISION</p>	<p>HSCC/D&E/ID/DEL-103</p>	<p>R-0</p>
<p>DRWING NO.</p>	<p>Job No.</p>	<p>NTS Scale</p>	<p>Date</p>
<p>App by</p>	<p>Rev. by</p>	<p>Prep. by</p>	

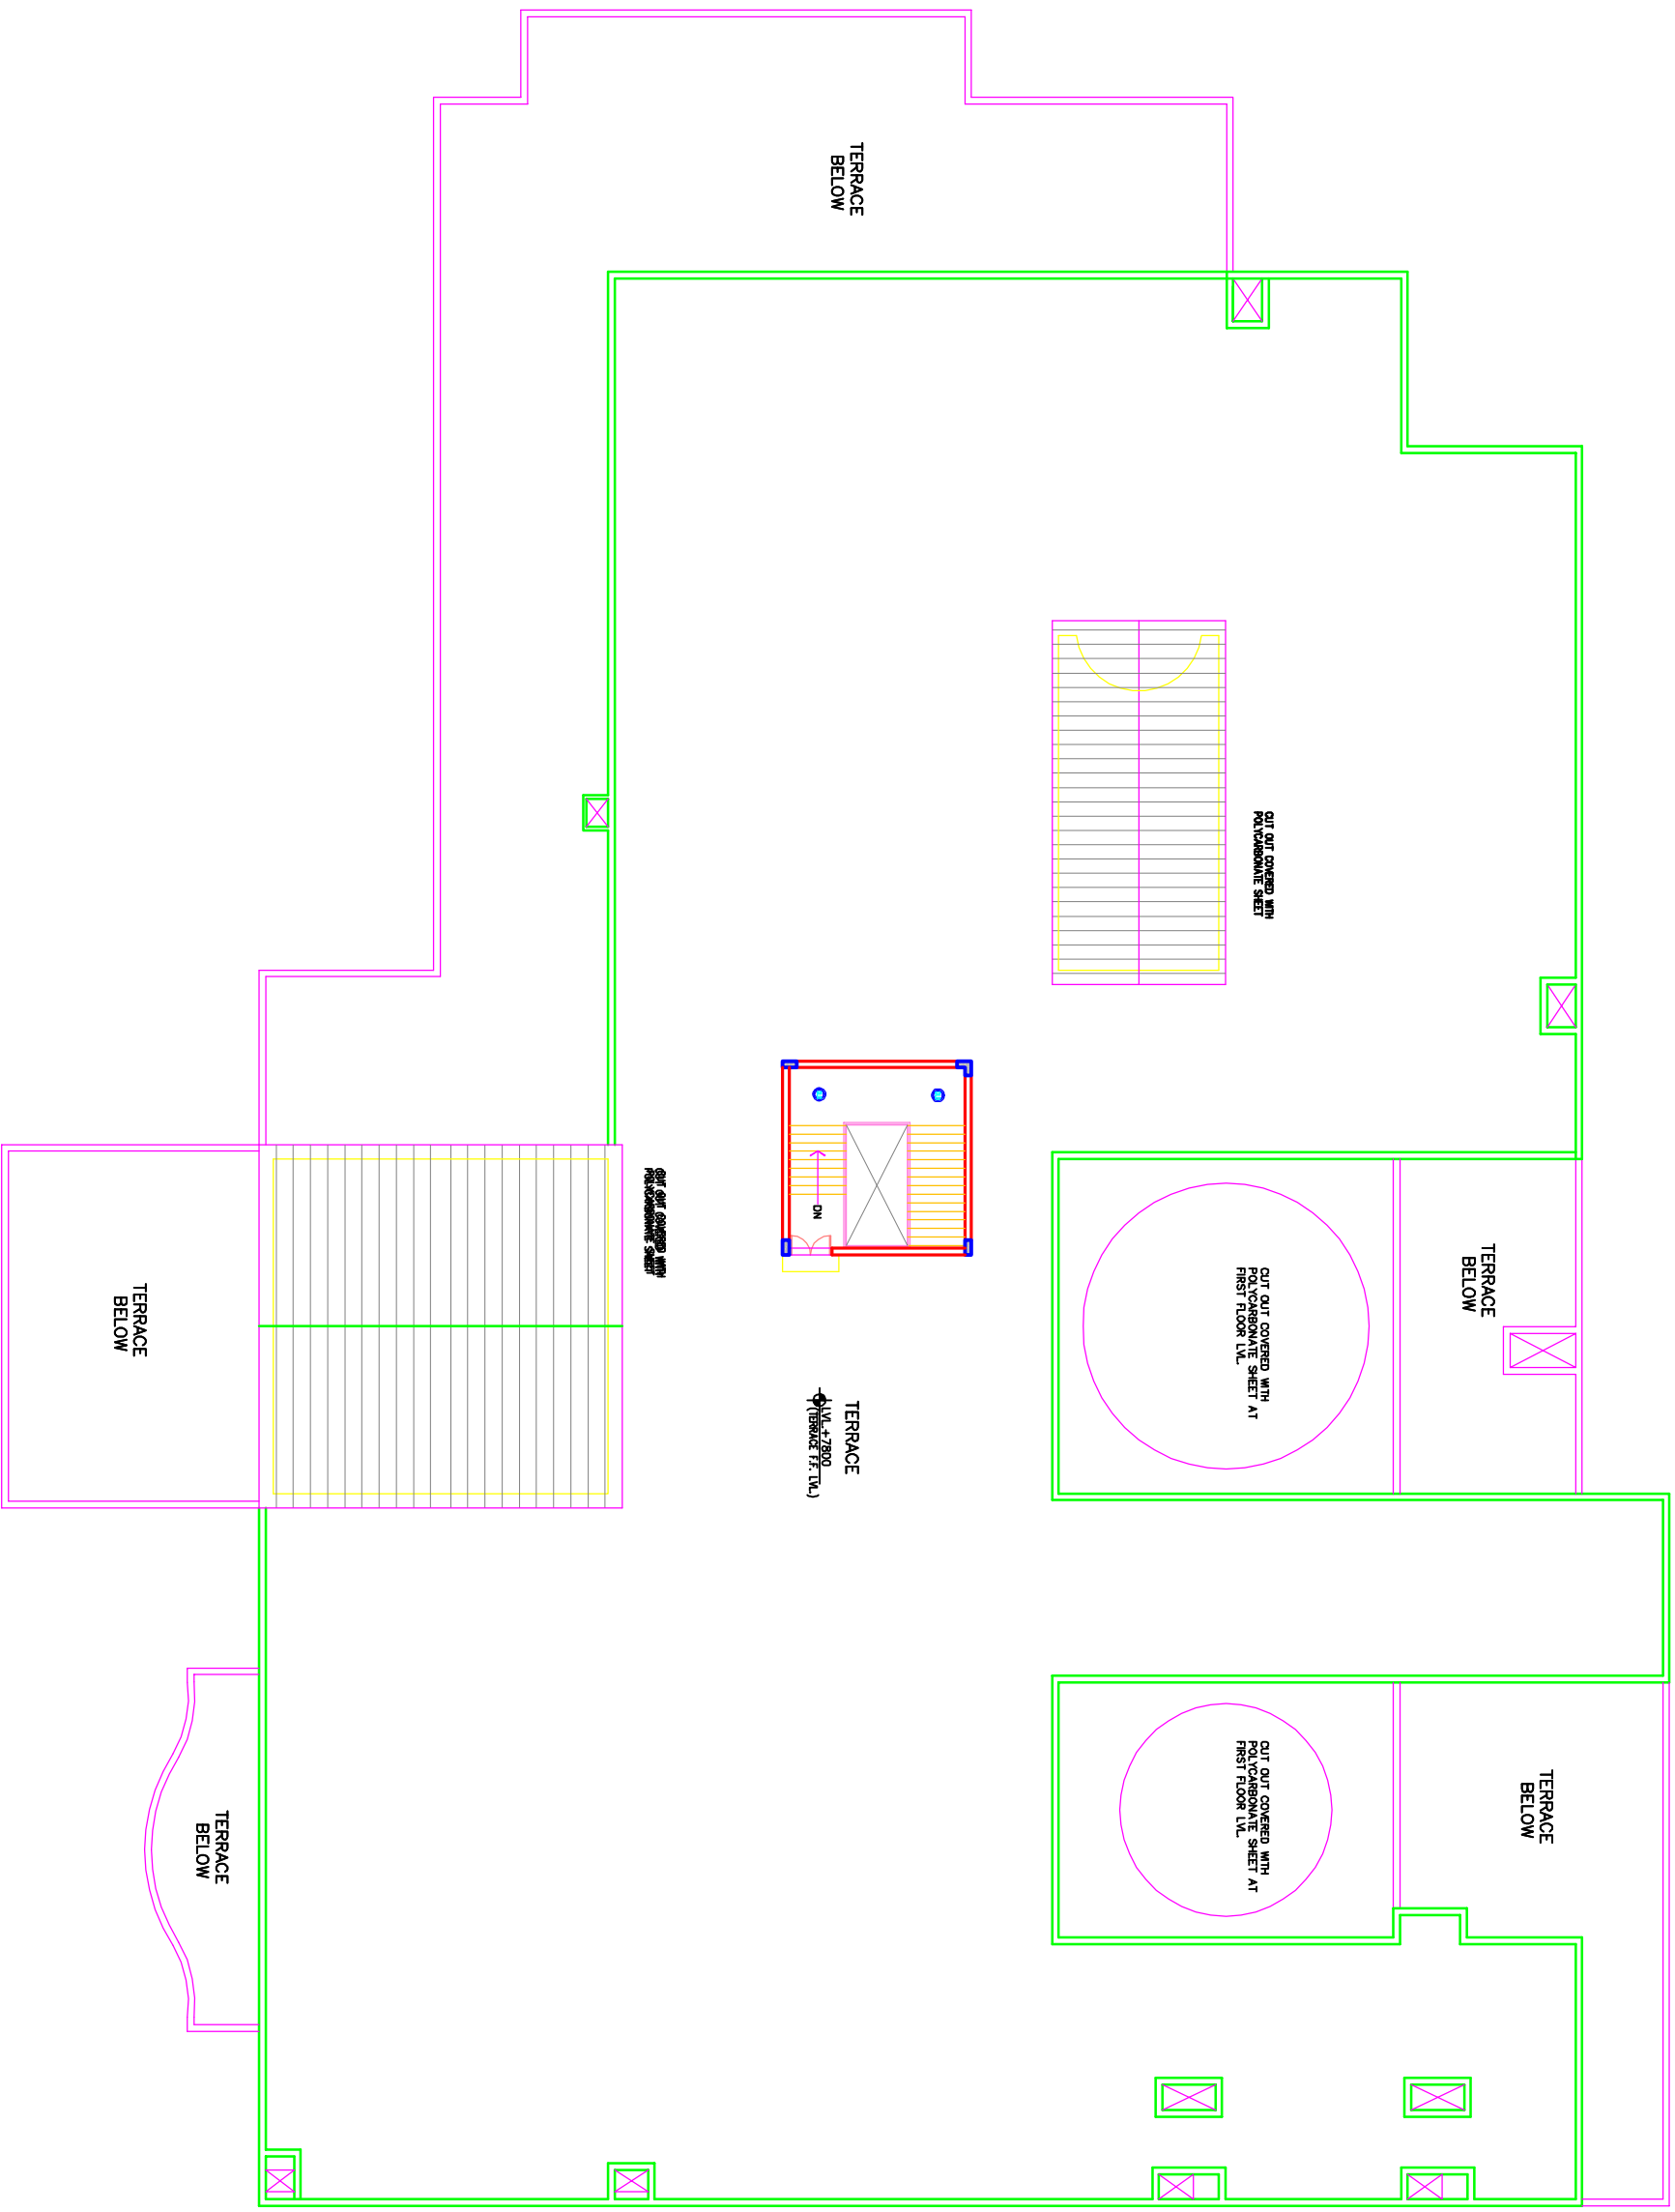

HVAC
DRAWINGS



NOTES

The drawing with all its contents is the sole intellectual property of the Institute of Health Services Consultants & Engineers (India) Ltd. Copying of this drawing or part thereof in any form or by any means without the written permission of IHSCE is prohibited.

REV	DATE	DESCRIPTION


PROJECT

Proposed
100 Bedded Hospital
At CHHATTISGARH

TITLE

TENDER DRAWING
GROUND FLOOR PLAN
HVAC LAYOUT
(COVERED AREA=3022 SQ. MT.)

ESCCD&EHTYAONRBNMCGAC-01	R-0
Drawing No.	
BSQC/-	1:125
Job No.	Scale
	25-03-2013
Date	
App by	Rev. by
	Prep. by

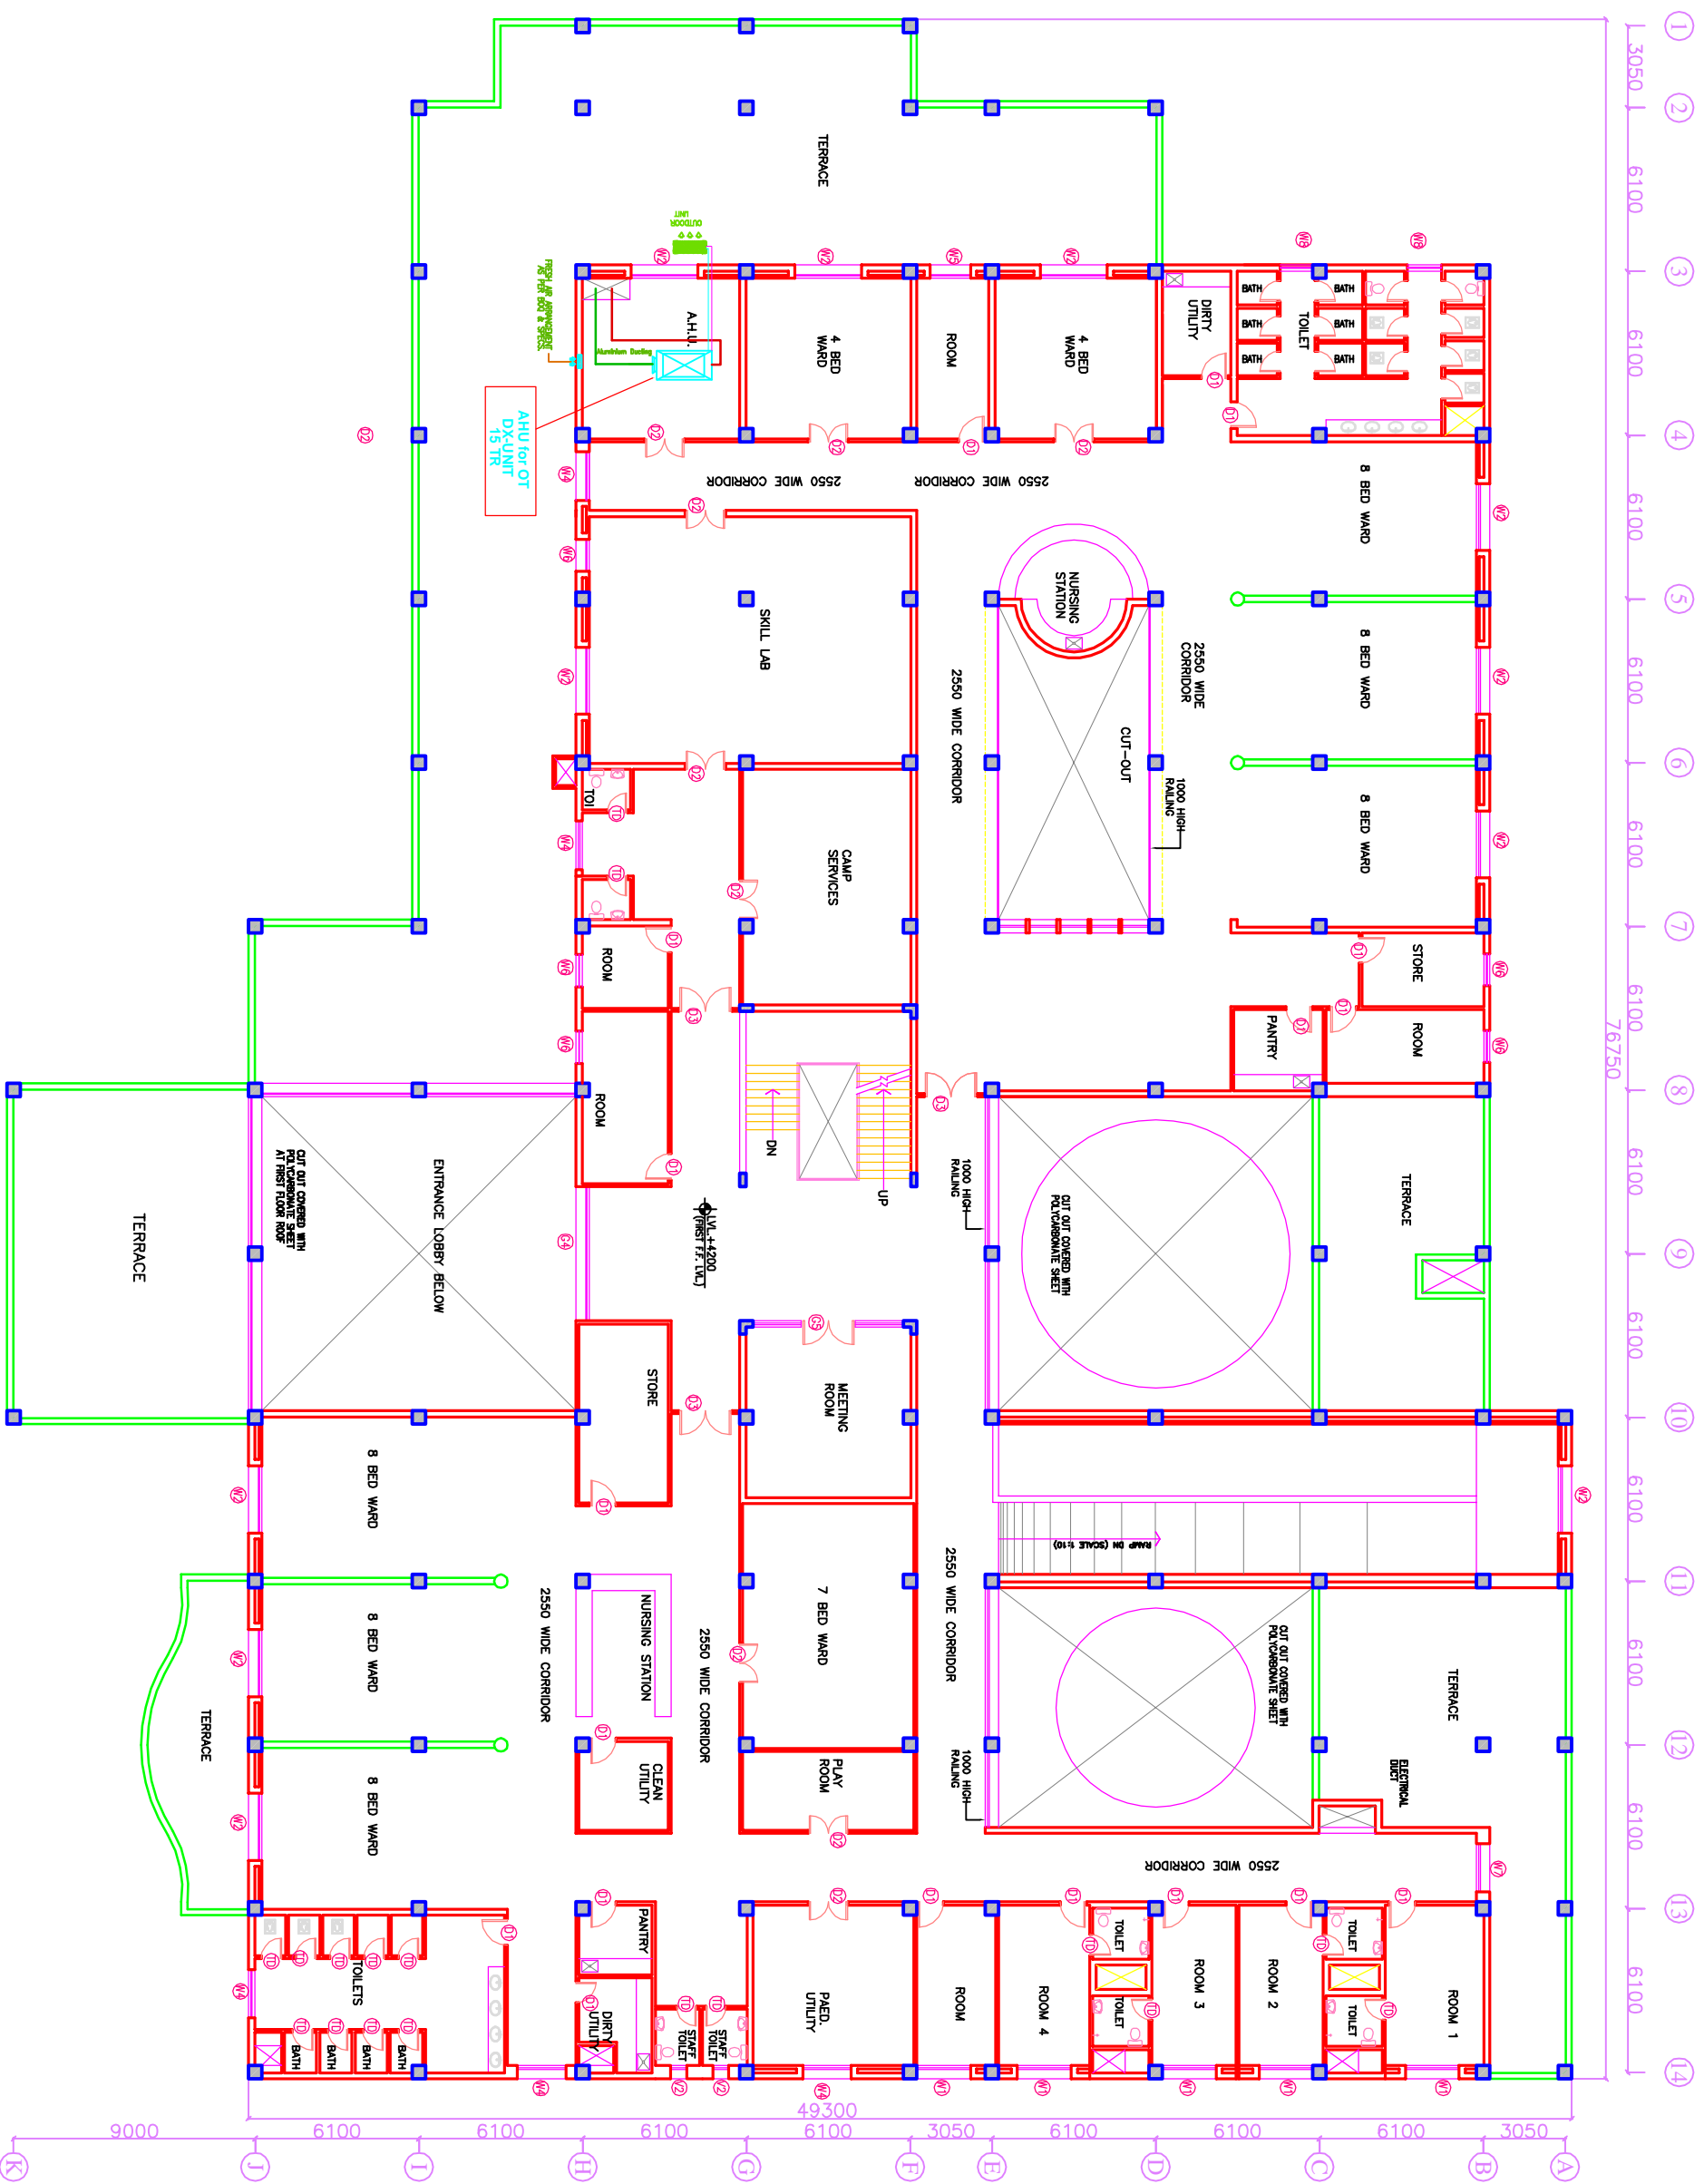

NOTES

The drawing with all its contents is the sole intellectual property of the Institute of Engineers (India) Ltd. Copying of this drawing or part thereof in any form or by any means without the written permission of IESCI is prohibited.

REV	DATE	DESCRIPTION

PROJECT

Proposed
100 Bedded Hospital
At CHHATISGARH

TITLE

TENDER DRAWING
FIRST FLOOR PLAN
HVAC LAYOUT
(COVERED AREA=2050 SQ. MT.)

ESCCD&E/HT/AC/ENR/HA/CG/AC-02	R-0
Drawing No.	Rev.
BS/CC/-	1:125
Job No.	Scale
	19-03-2013
	Date
App by	Rev. by
	Prep. by