


PHE & FIRE

DRAWINGS

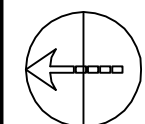

This drawing with its contents is the sole intellectual property of the Hospital Services Consultancy Corporation (India) Ltd. Copying of this drawing or part thereof or its use in any form whatsoever without the written permission of HSCC is prohibited.

NOTES

1. DRAWINGS TO BE READ NOT MEASURED
2. PARTITION WALL IN TOILETS UP TO LINTEL HEIGHT

LEGEND:

1	100 Ø CI SOIL & VENT PIPE
2	100Ø CL.WASTE & VENT PIPE
3	100Ø CI. SOIL PIPE
4	100Ø CI. WASTE PIPE
5	50Ø GI/CPVC SOIL PIPE
6	40Ø GI/CPVC WASTE PIPE for lab, Urinal
7	32Ø GI/CPVC WASTE PIPE For W.B.
8	Ø CPVC UTW DN.TAKE
9	Ø CPVC TW DN.TAKE
10	100 Ø S.W. PIPE
11	100 Ø R.W. PIPE
12	100 Ø HDPE.LAB WASTE PIPE
13	50 Ø HDPE.LAB WASTE PIPE
F.T	FLOOR TRAP 100x100
F.D	FLOOR DRAIN 50Ø
FCO	FLOOR CLEAN OUT
COP	CLEAN OUT PLUG
∇	VALVE
MH	MANHOLE (900x600)mm
GT	GULLY TRAP(300x300)mm

NO.	DESCRIPTION

PROJECT
 PROPOSED
 100 BEDDED HOSPITAL
 RMNCH PROJECT,
 CHATTISGARH

TITLE PLUMBING
TENDER DRAWING


GROUND FLOOR PLAN

HSCC/D&E/TD/RMNCH/PL-01
 Drawing No. Rev.

Job No. 1:300 Scale 05-04-2013 Date

R.TYAGI App by R.SUR Rev. by S.BHATT Prep. by


HSCC (INDIA) LIMITED
 (A GOVERNMENT OF INDIA ENTERPRISE)
HSCC
 NEW DELHI INDIA

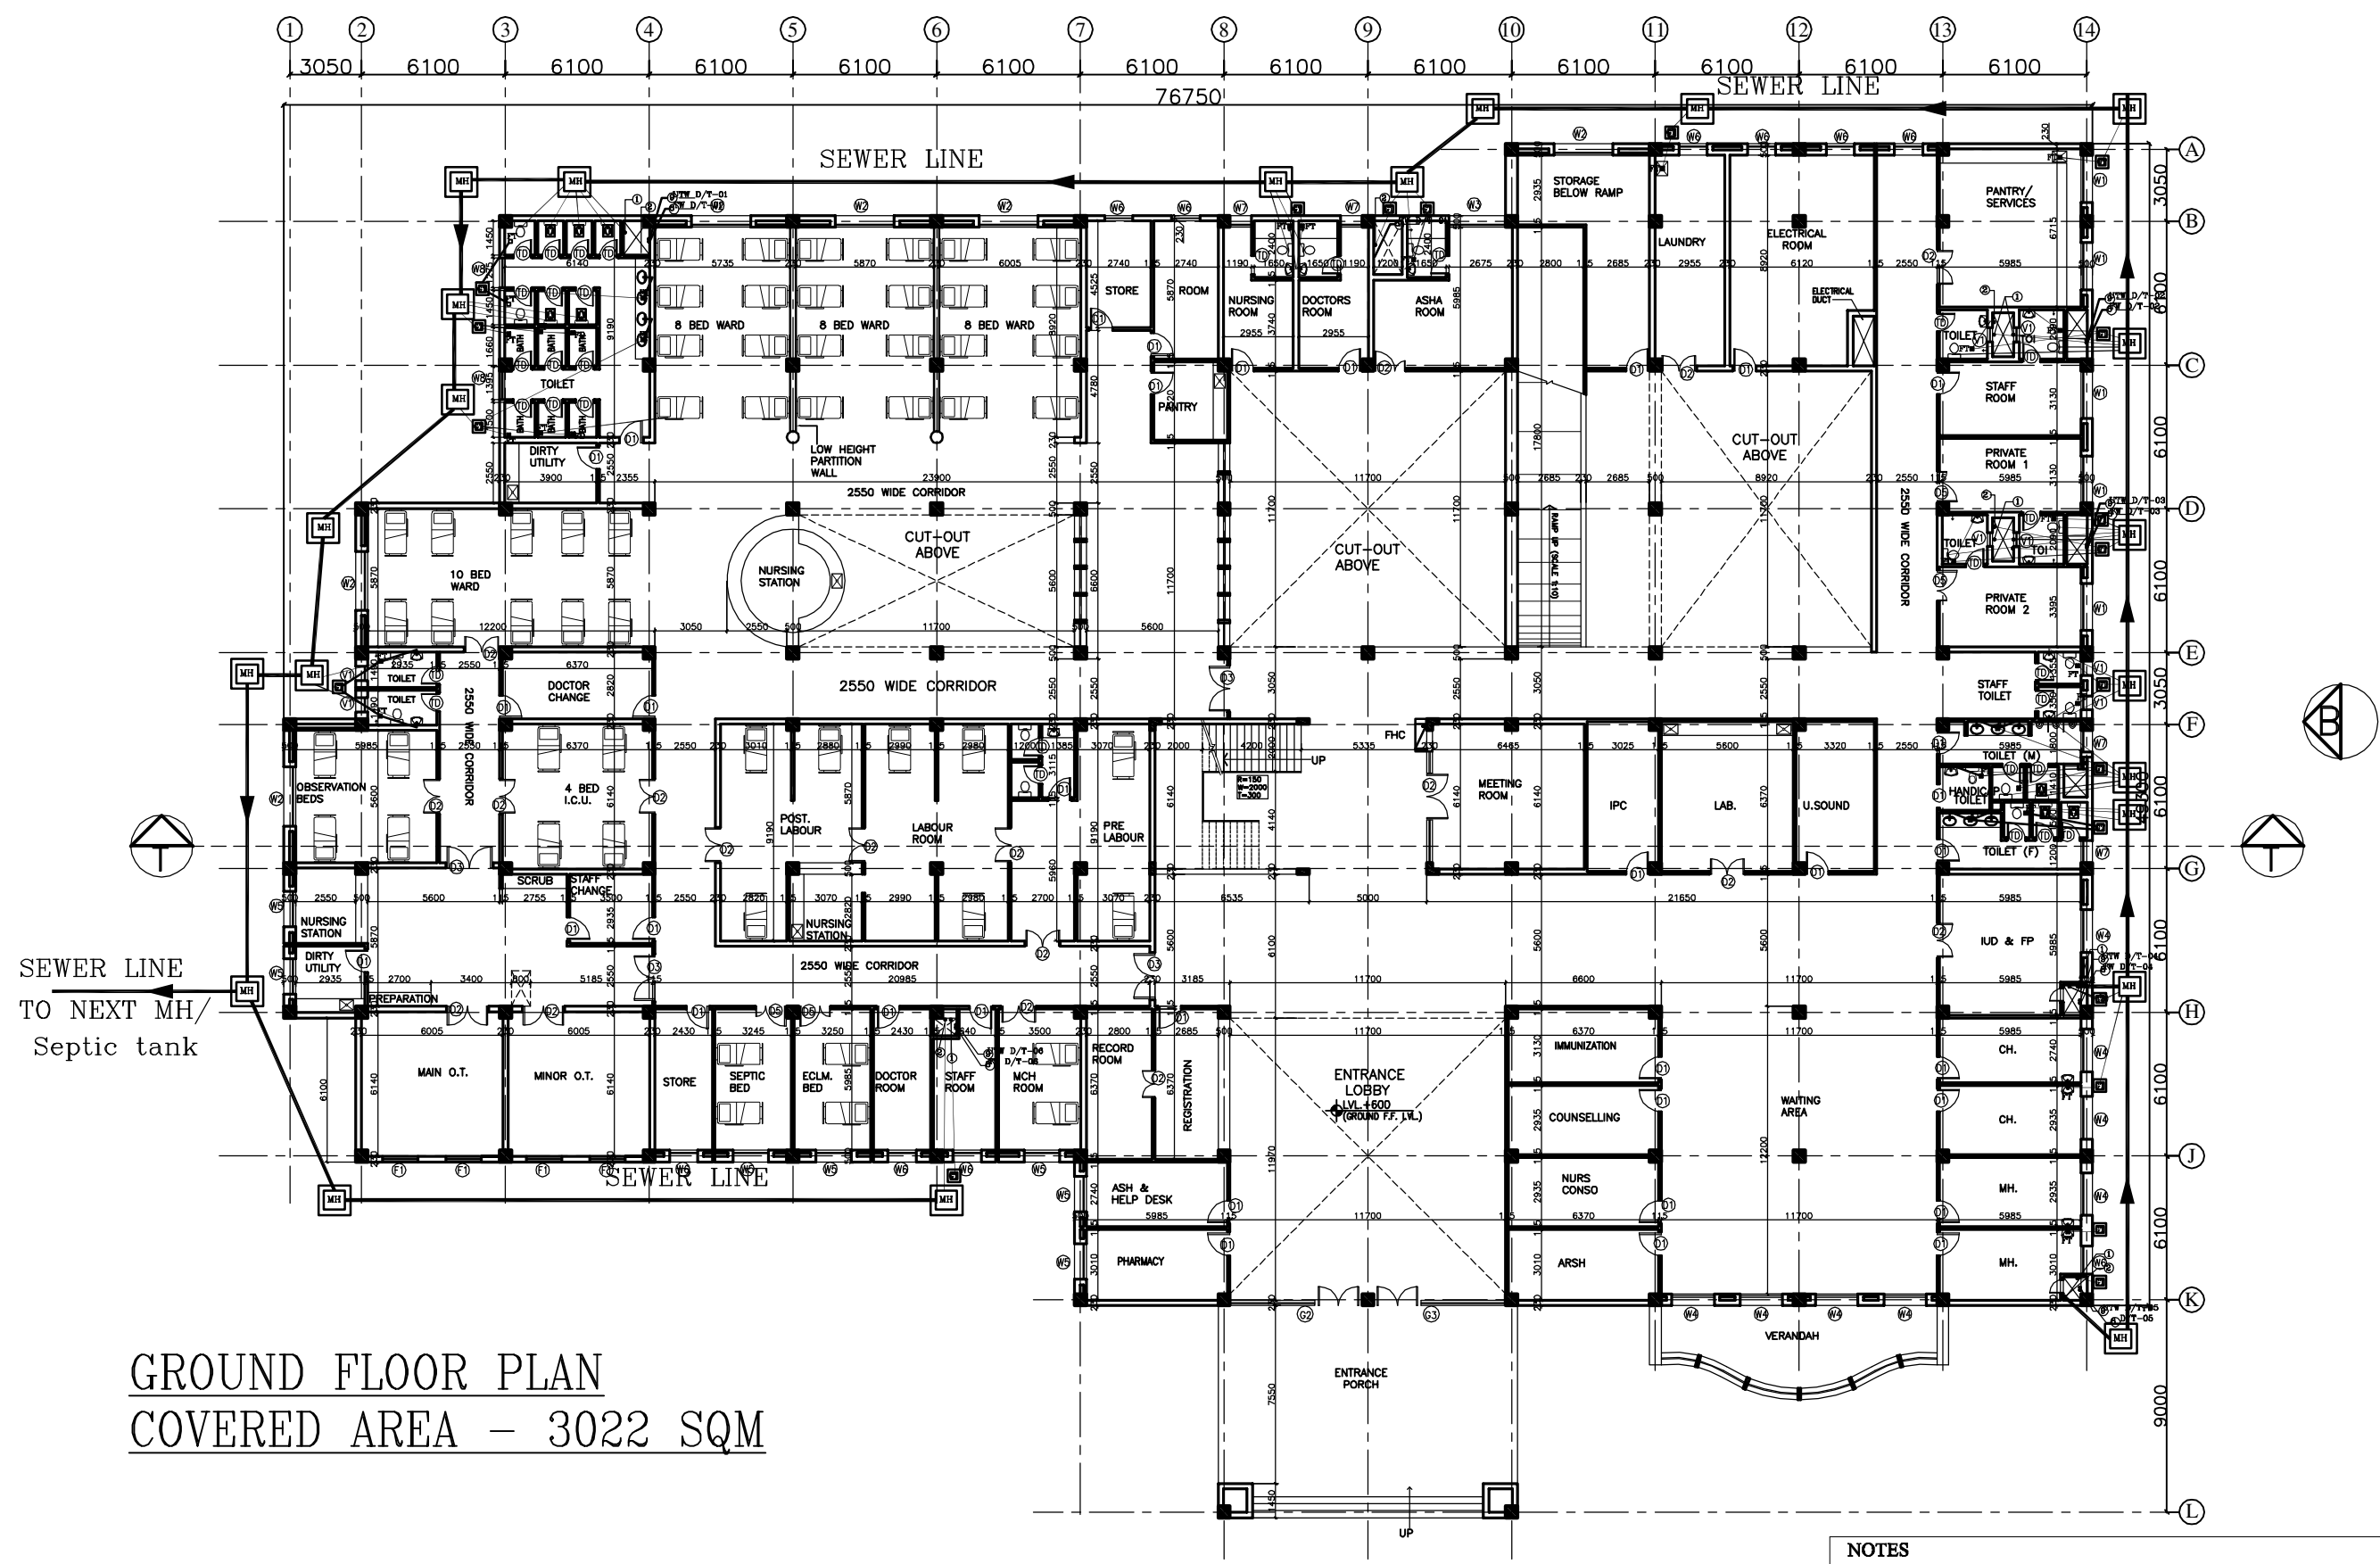


GROUND FLOOR PLAN
 COVERED AREA - 3022 SQM

NOTES

 1. BASED ON THIS DRAWING EXECUTING AGENCY WILL PREPARE SHOP DRAWING AFTER INCORPORATING THE CHANGES AS PER SITE CONDITION FOR THE APPROVAL OF HSCC BEFORE START OF WORK.
2. THE NUMBER & LOCATION OF FIXTURES & WET POINT TO BE FINALIZED BEFORE EXECUTION WITH CLINT OFFICER,S INCHARGE..



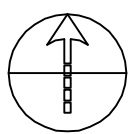

This drawing with all its contents is the sole intellectual property of the Consulting Engineer (India) Ltd. Copying of this drawing or part thereof in any form or by any means without the written permission of HSCC is prohibited.

- NOTES**
1. DRAWINGS TO BE READ NOT MEASURED
 2. PARTITION WALL IN TOILETS UP TO UNTEL HEIGHT

LEGEND:

1	100 Ø CI SOIL & VENT PIPE
2	100Ø CI WASTE & VENT PIPE
3	100Ø CI SOIL PIPE
4	100Ø CI WASTE PIPE
5	50Ø GI/CPVC SOIL PIPE
6	40Ø GI/CPVC WASTE PIPE for Sk.Utlr
7	32Ø GI/CPVC WASTE PIPE FOR W.A.
8	Ø CPVC UTW/DN TAKE
9	Ø CPVC TW/DN TAKE
10	100 Ø S.W. PIPE
11	100 Ø R.W. PIPE
12	100 Ø HDPE/LAB WASTE PIPE
13	50 Ø HDPE/LAB WASTE PIPE
FD	FLOOR DRAIN 50Ø
FT	FLOOR TRAP 100x100
FOO	FLOOR CLEAN OUT
COF	CLEAN OUT PLUG
☒	VALVE
MH	MANHOLE (900x900)mm
GT	GULLY TRAP(300x300)mm


REVISION	DESCRIPTION

PROJECT
 PROPOSED
 100 BEDDED HOSPITAL
 RMNCH PROJECT,
 CHATTISGARH

TITLE PLUMBING
 TENDER DRAWING
 FIRST
 FLOOR PLAN

HSCC/D&E/TD/RMNC/PL-02	Rev
Drawing No.	
Job No.	1:300
Scale	05-04-2013
Date	
App by	RTAGI
Rev. by	RSUR
Prep. by	S.BHATT


HSCC (INDIA) LIMITED
 (A GOVERNMENT OF INDIA ENTERPRISE)
HSCC
 NEW DELHI
 INDIA

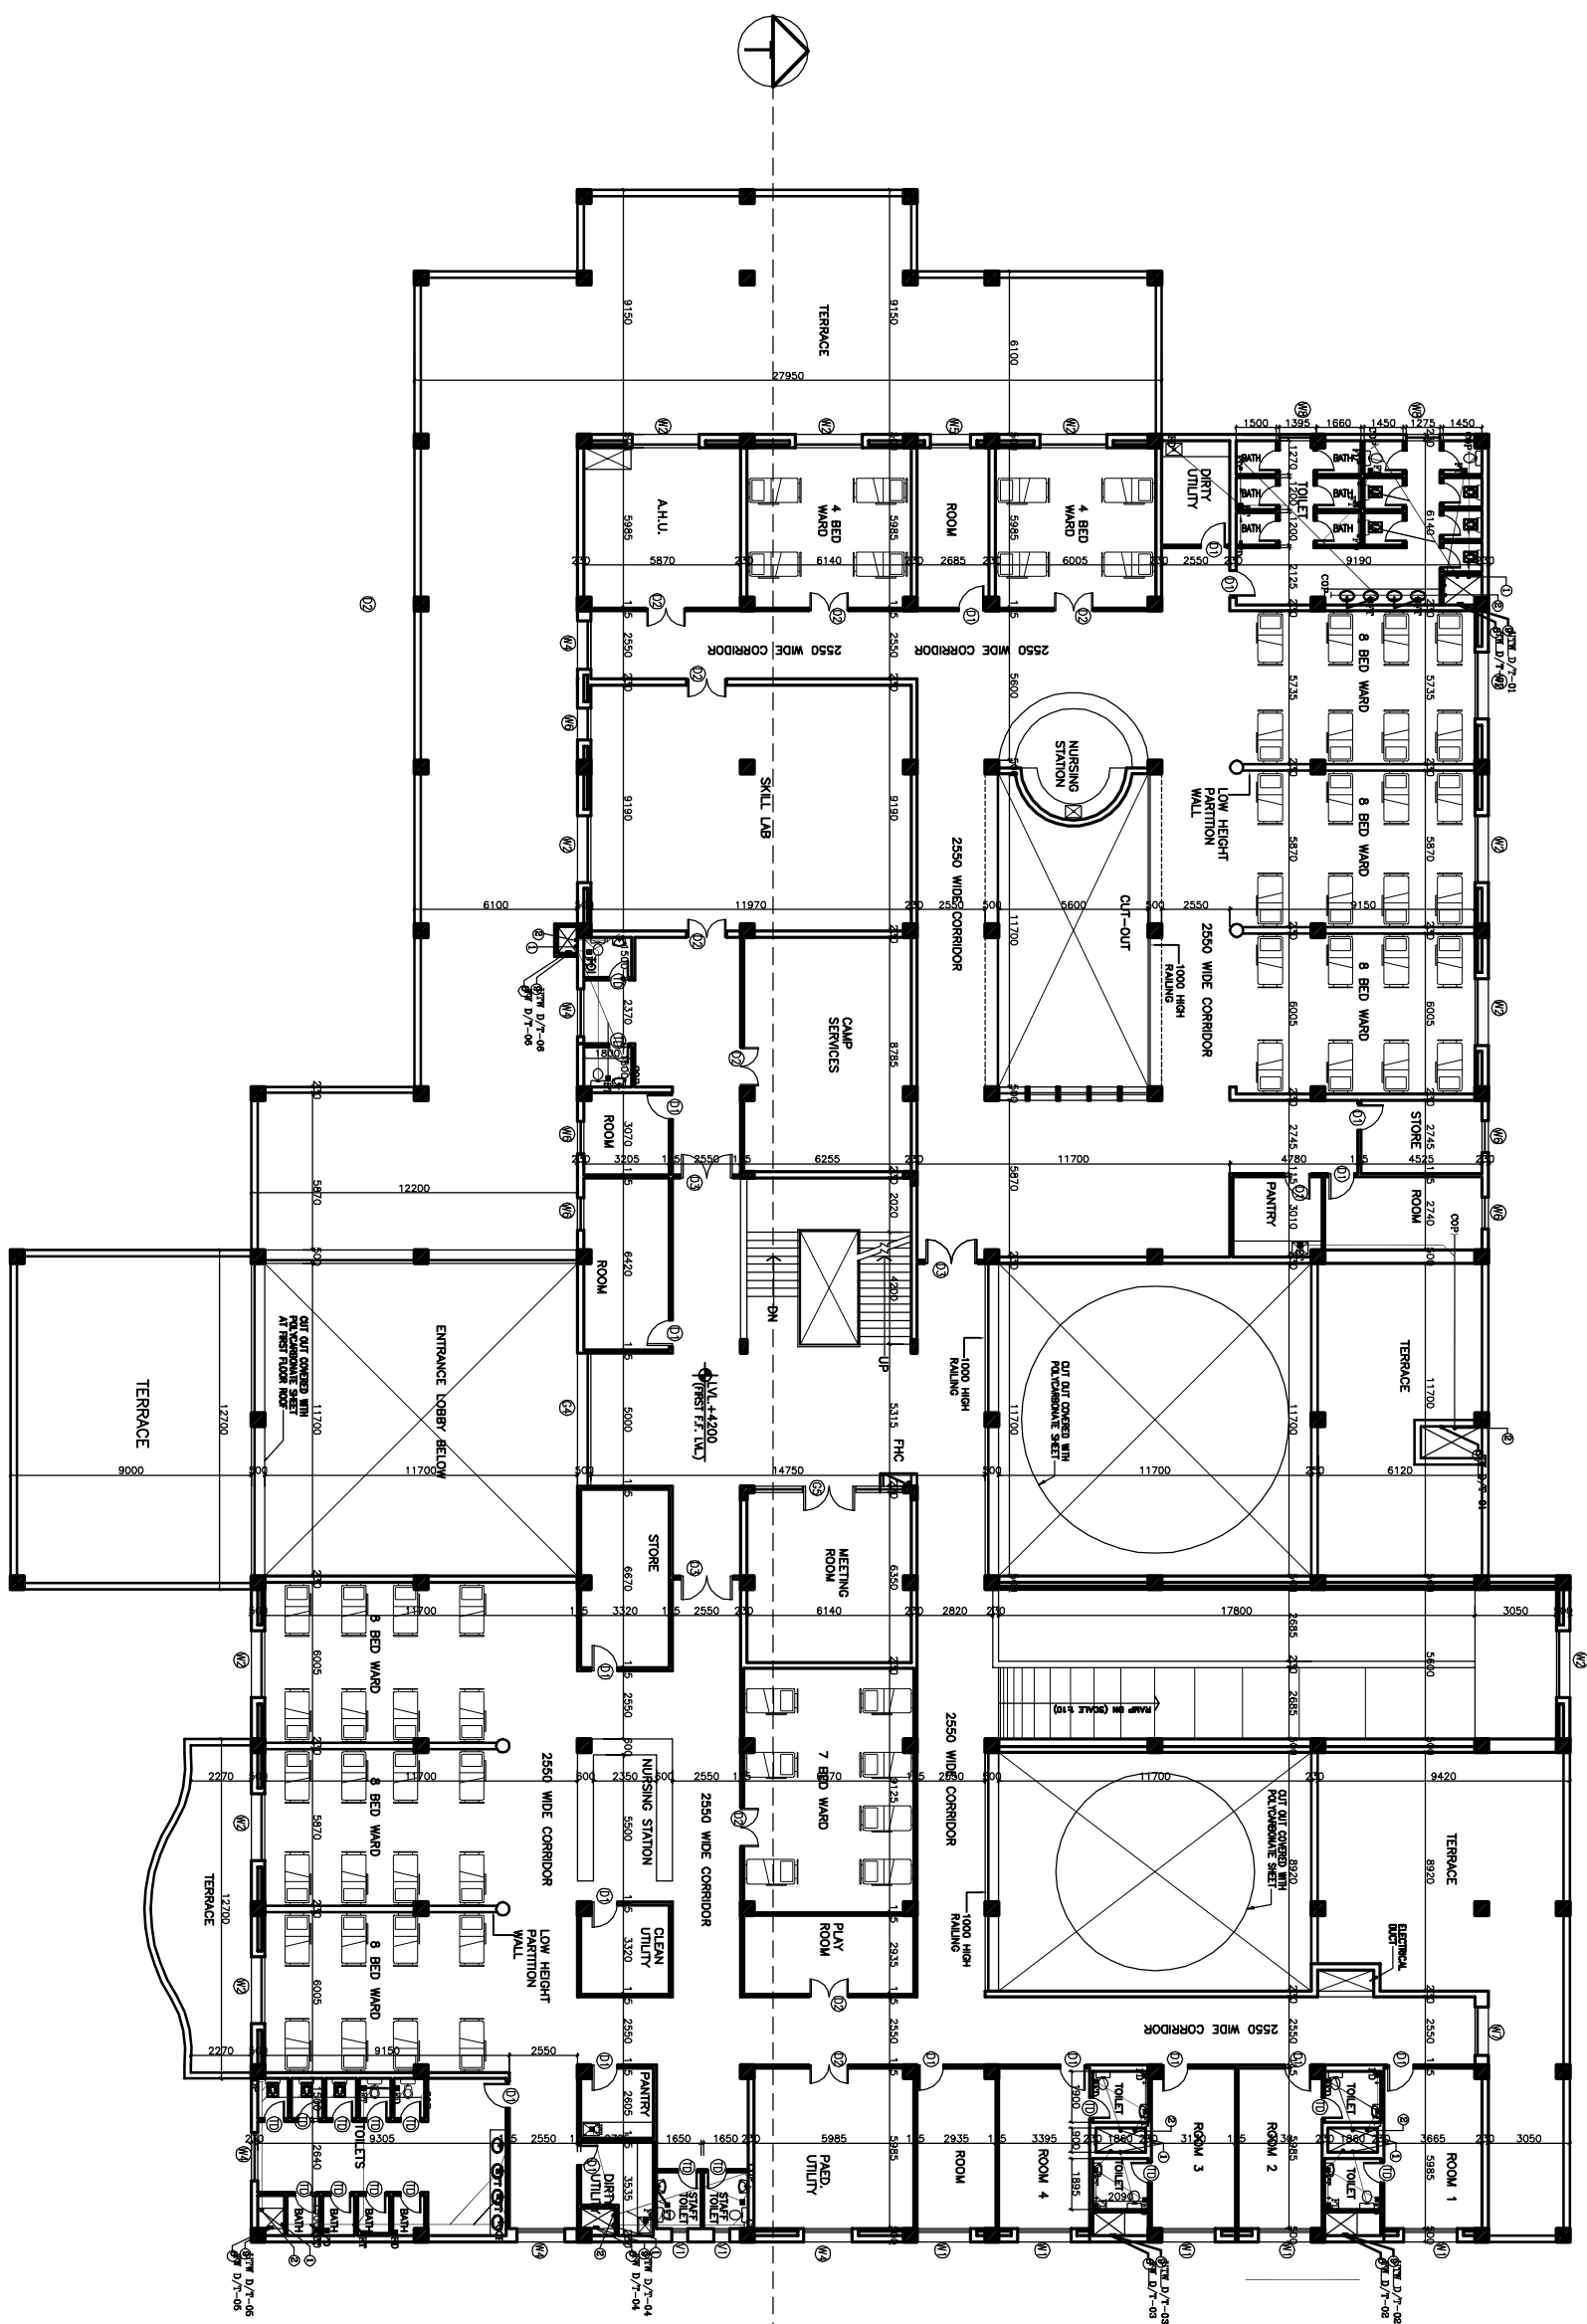

FIRST FLOOR PLAN
COVERED AREA – 2050 SQM



- NOTES**
1. BASED ON THIS DRAWING EXECUTING AGENCY WILL PREPARE SHOP DRAWING AFTER INCORPORATING THE CHANGES AS PER SITE CONDITION FOR THE APPROVAL OF HSCC BEFORE START OF WORK.
 2. THE NUMBER & LOCATION OF FIXTURES & WET POINT TO BE FINALIZED BEFORE EXECUTION WITH CLINT OFFICER'S INCHARGE.

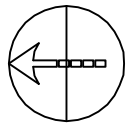

This drawing with all its contents is the sole intellectual property of the Hospital Services Consultancy Corporation (India) Ltd. Copying of this drawing or part thereof, or its use in any form whatsoever without the written permission of HSCC is prohibited.

NOTES

1. DRAWINGS TO BE READ NOT MEASURED
2. PARTITION WALL IN TOILETS UP TO LINTEL HEIGHT

LEGEND:

1	100 Ø CI SOIL & VENT PIPE
2	100Ø CL.WASTE & VENT PIPE
3	100Ø CI. SOIL PIPE
4	100Ø CI. WASTE PIPE
5	50Ø GI/ CPVC SOIL PIPE
6	40Ø GI/ CPVC WASTE PIPE for Urinal, Lab, sink
7	32Ø GI /CPVC WASTE PIPE For W.B.
8	Ø CPVC UTW DN.TAKE
9	Ø CPVC TW DN.TAKE
10	100 Ø S.W. PIPE
11	100 Ø R.W. PIPE
12	100 Ø HDPE.LAB WASTE PIPE
13	50 Ø HDPE.LAB WASTE PIPE
F.T	FLOOR TRAP 100x100
F.D	FLOOR DRAIN 50Ø
FCC	FLOOR CLEAN OUT
COP	CLEAN OUT PLUG
⊗	VALVE
MH	MANHOLE (900x900)mm
GT	GULLY TRAP(300x300)mm

NO.	DESCRIPTION

NO.	REVISION

PROJECT

PROPOSED
100 BEDDED HOSPITAL

**RMNCH PROJECT,
CHATTISGARH**

TITLE PLUMBING

TENDER DRAWING

TERRACE
FLOOR PLAN


HSCC/D&E/ID/RMNCH/PL-03

Drawing No. _____ Rev. _____

Job No. _____ 1:300 Scale _____ 05-04-2013 Date _____

R.TYAGI App by R.SUR Rev. by S.BHATT Prep. by

HSCC (INDIA) LIMITED
(A GOVERNMENT OF INDIA ENTERPRISES)
HSCC
NEW DELHI INDIA

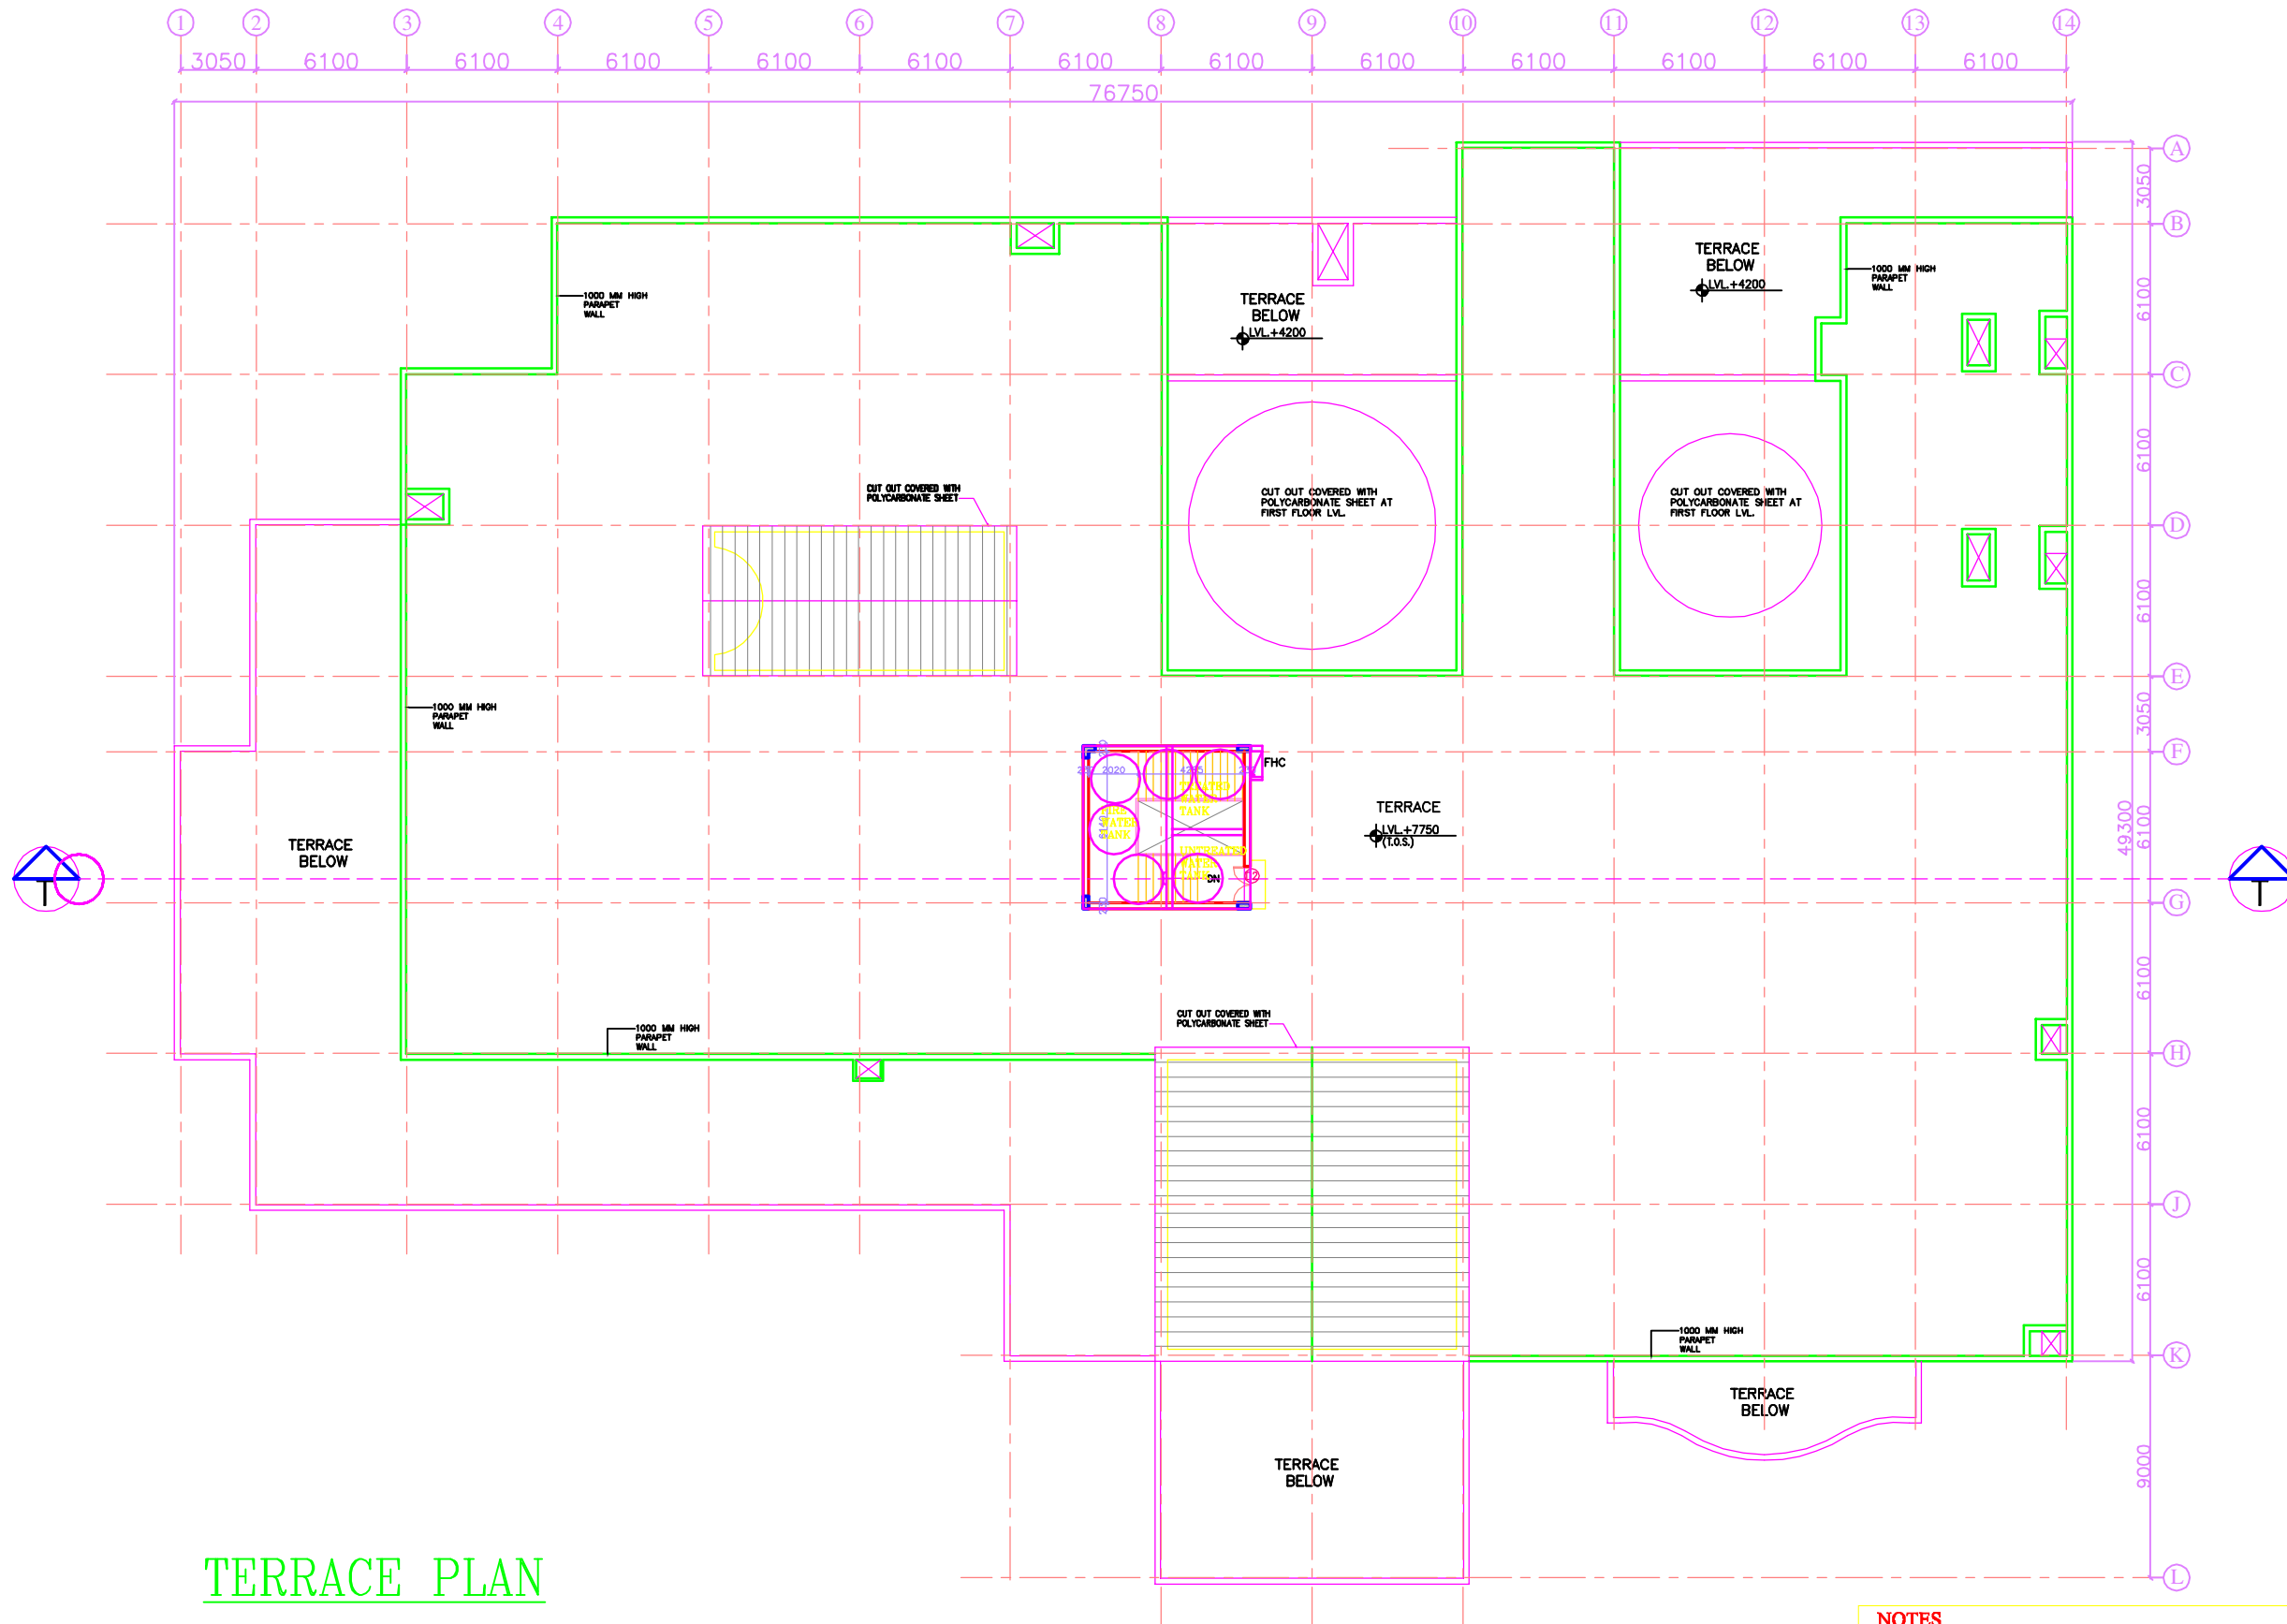

TERRACE PLAN

NOTES


1. BASED ON THIS DRAWING EXECUTING AGENCY WILL PREPARE SHOP DRAWING AFTER INCORPORATING THE CHANGES AS PER SITE CONDITION FOR THE APPROVAL OF HSCC BEFORE START OF WORK.
2. THE NUMBER & LOCATION OF FIXTURES & WET POINT TO BE FINALIZED BEFORE EXECUTION WITH CLINT OFFICER,S INCHARGE..

ELECTRICAL

DRAWINGS

This drawing with all its contents is the sole intellectual property of the Hospital Services Consultancy Corporation (India) Ltd. Copying of this drawing or part thereof or its use in any form whatsoever without the written permission of HSCC is prohibited.

NOTES

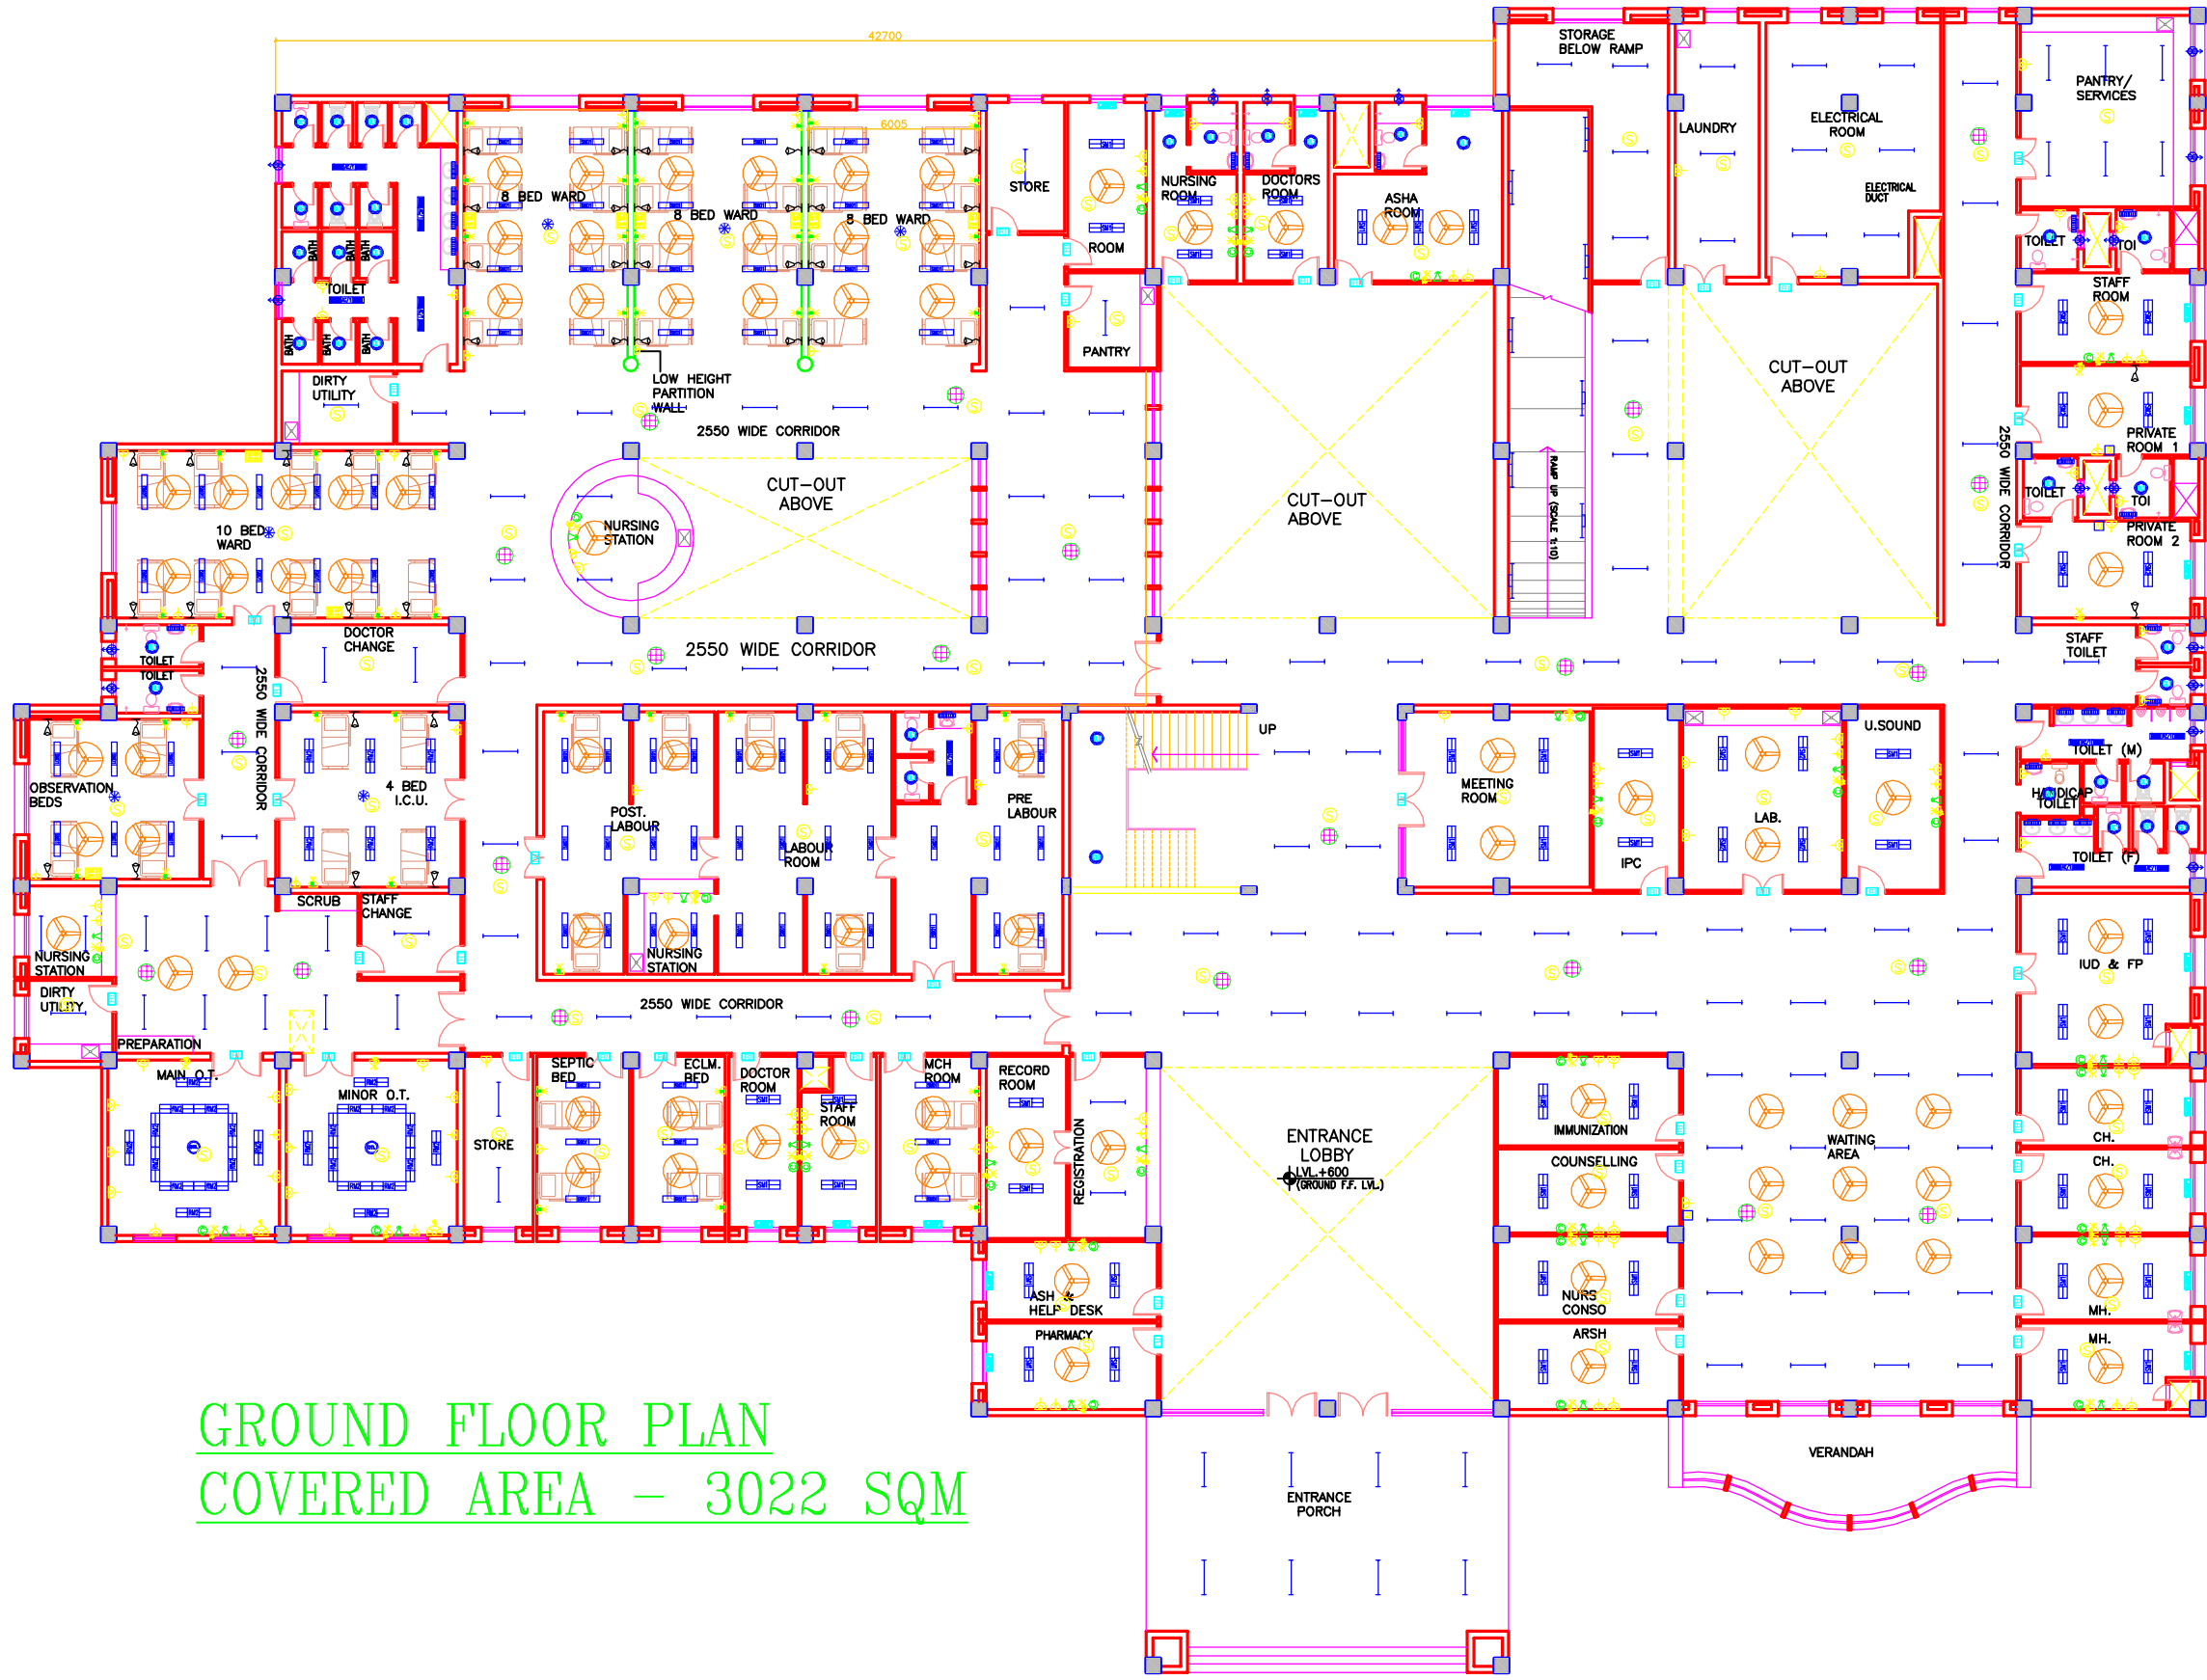

GROUND FLOOR PLAN
COVERED AREA - 3022 SQM

REV	DATE	DESCRIPTION

PROJECT
 RMNCH PROJECT
 Proposed
 100 Bedded Hospital
 AT
 CHATTISGARH

TITLE
 MODEL PLANS
 GROUND
 FLOOR PLAN
 ELECTRICAL LAYOUT
 (COVERED AREA=3022 SQ. MT.)


HSCC/D&E/TD/EL-101 R-0
 Drawing No. Rev.

HSCC/- NTS Date
 Job No. Scale

App by Rev. by Prep. by

This drawing with all its contents is the sole intellectual property of the HSCC (INDIA) LIMITED (a Government of India Enterprise) and shall remain the property of HSCC (INDIA) LIMITED. Any use or part thereof in any form without the written permission of HSCC is prohibited.

NOTES

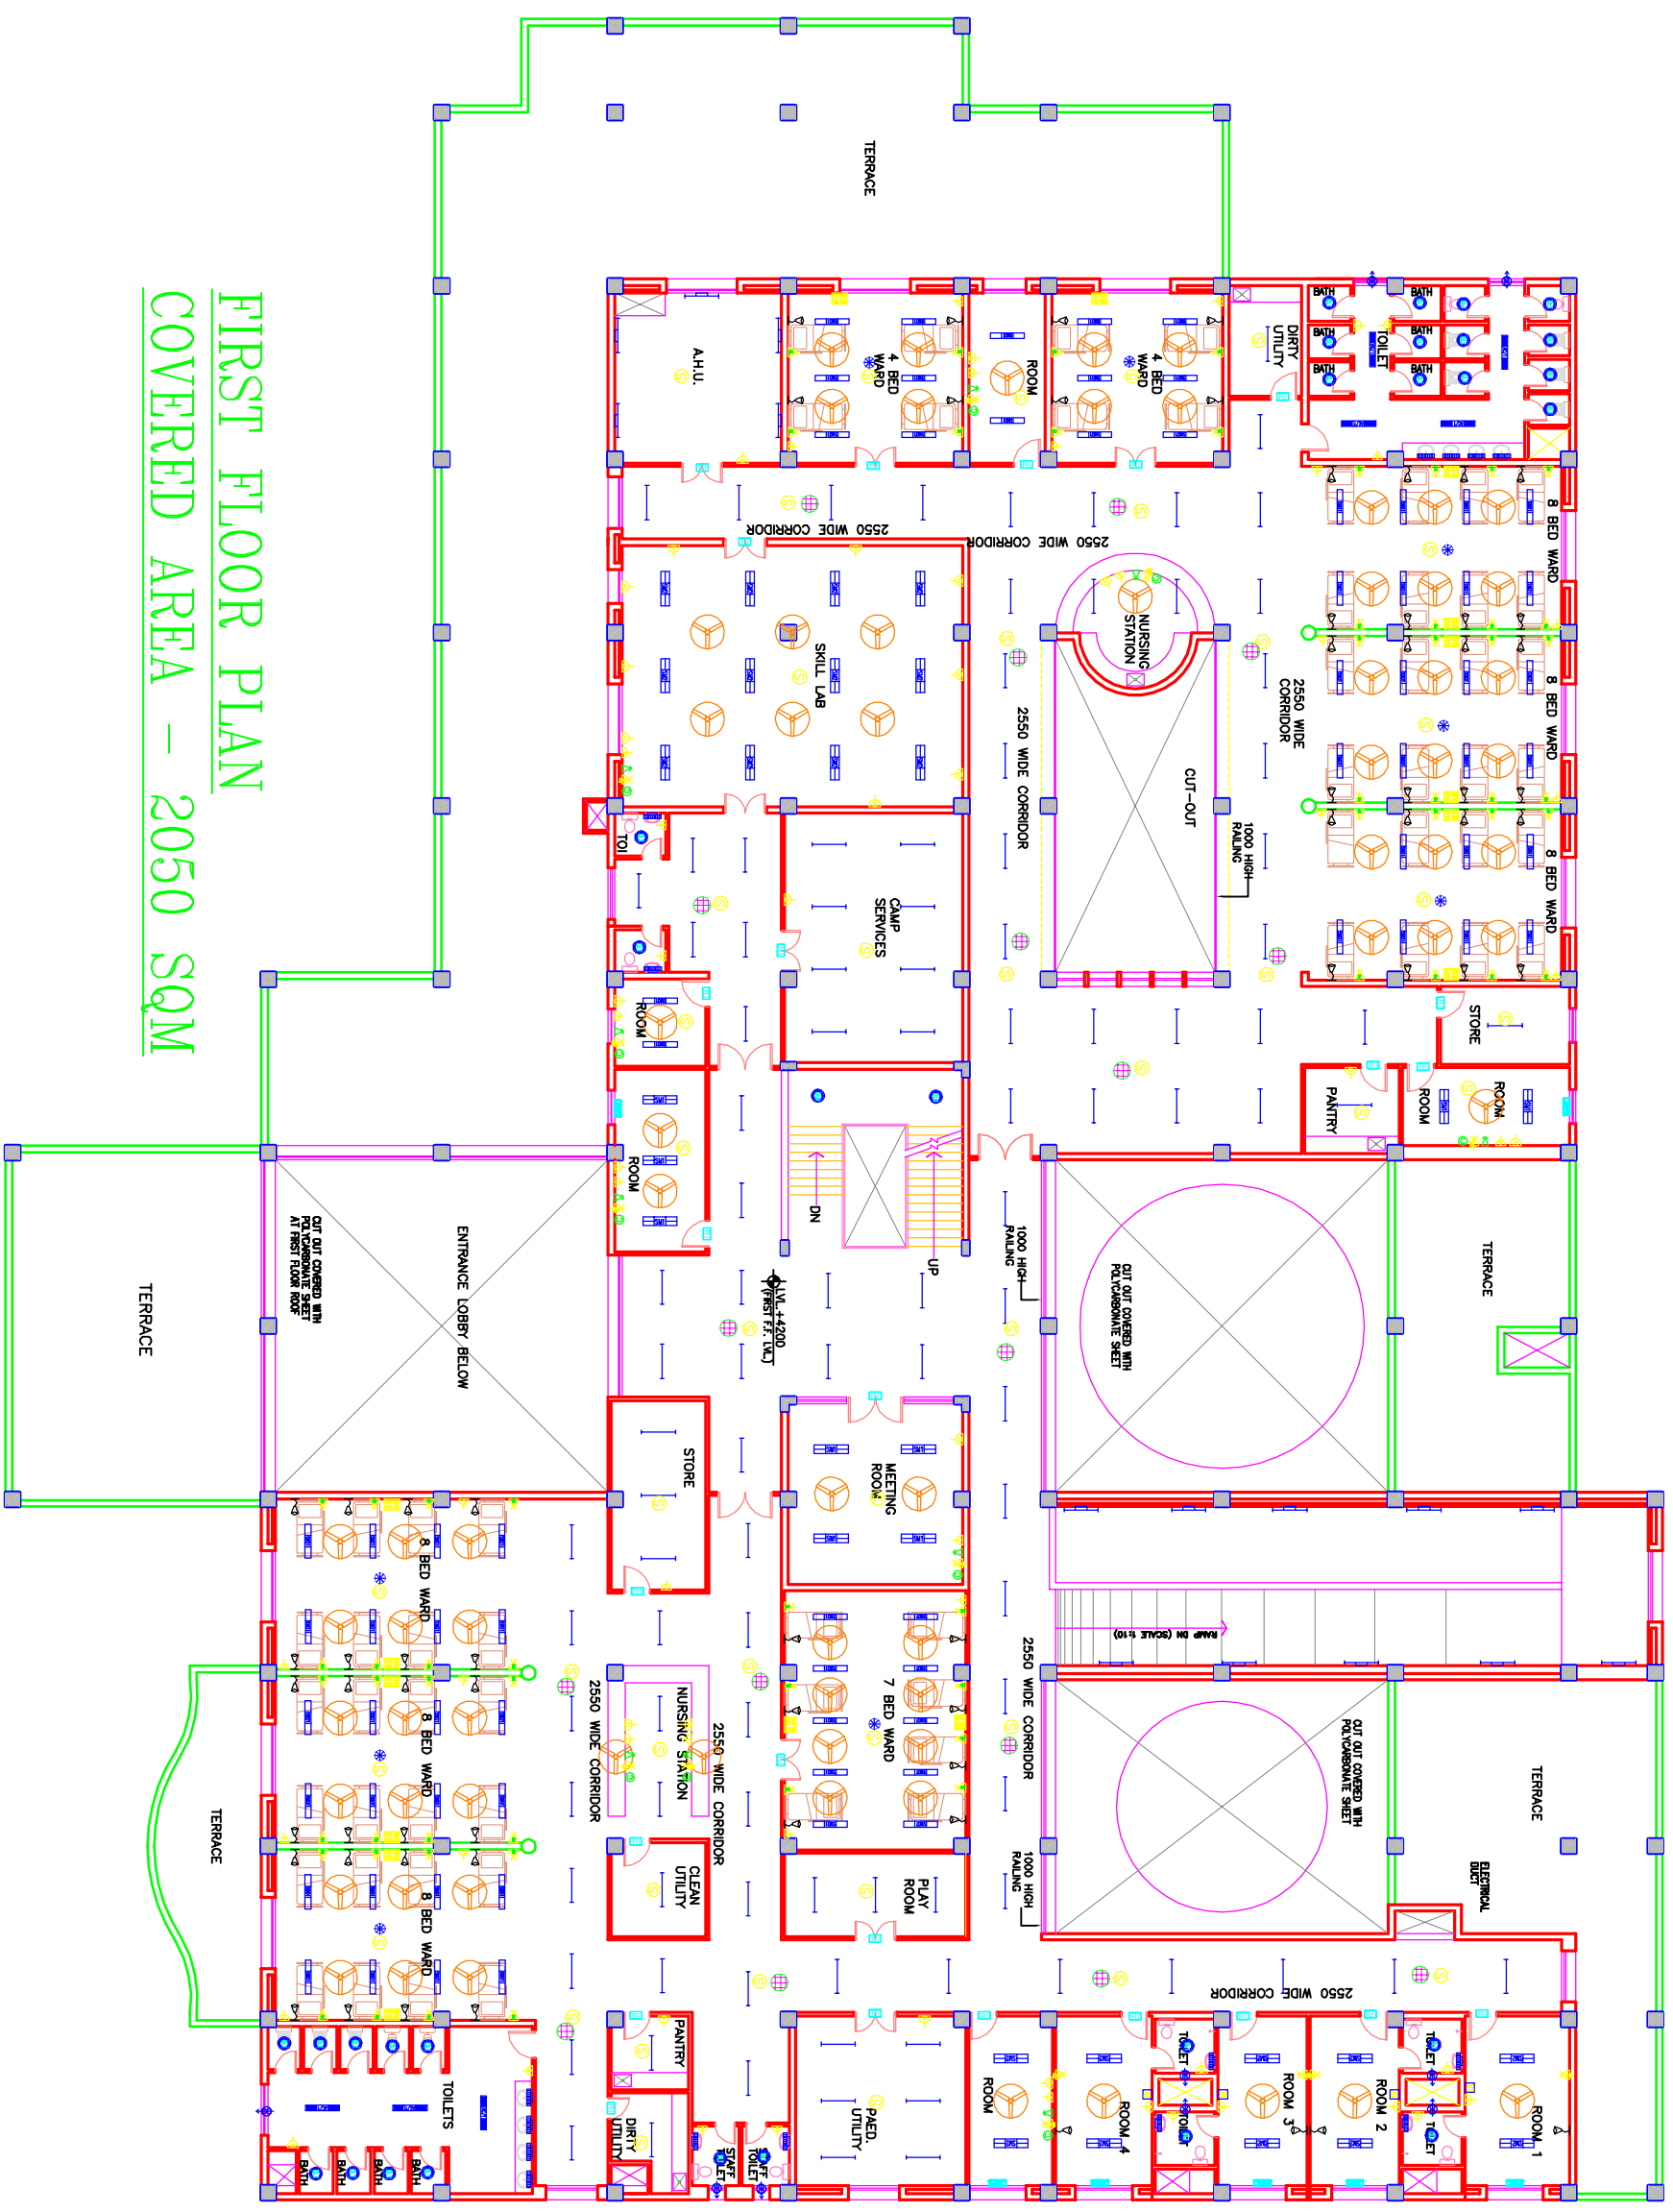

FIRST FLOOR PLAN
COVERED AREA – 2050 SQM

REV.	DATE	DESCRIPTION

PROJECT
RMNCH PROJECT
Proposed
100 Bedded Hospital
AT
CHATTISGARH

TITLE
MODEL PLANS
FIRST
FLOOR PLAN
ELECTRICAL LAYOUT
(COVERED AREA=2050 SQ. MT.)

HSCC/DA&E/TD/DEL-102 R-0
Drawing No. Rev.


App by: _____ NTS _____ Date _____
Job No. _____ Scale _____

App by: _____ Rev. by: _____ Prep. by: _____

This drawing with all its contents is the sole Intellectual Property of the HSCC (INDIA) LIMITED (a Government of India Enterprise) and its use for any purpose other than that of the project for which it was prepared without the written permission of HSCC is prohibited.

NOTES

<p>PROJECT RMNCH PROJECT Proposed 100 Bedded Hospital AT CHATTISGARH</p>		<p>TITLE MODEL PLANS TERRACE PLAN ELECTRICAL LAYOUT</p>	
<p>REV. DATE DESCRIPTION</p>	<p>REVISION</p>	<p>HSCC/D&E/ID/DEL-103</p>	<p>R-0</p>
<p>App by</p>	<p>Rev. by</p>	<p>Job No.</p>	<p>Date</p>
<p>Prep. by</p>	<p>Scale</p>	<p>NTS</p>	<p>Rev.</p>

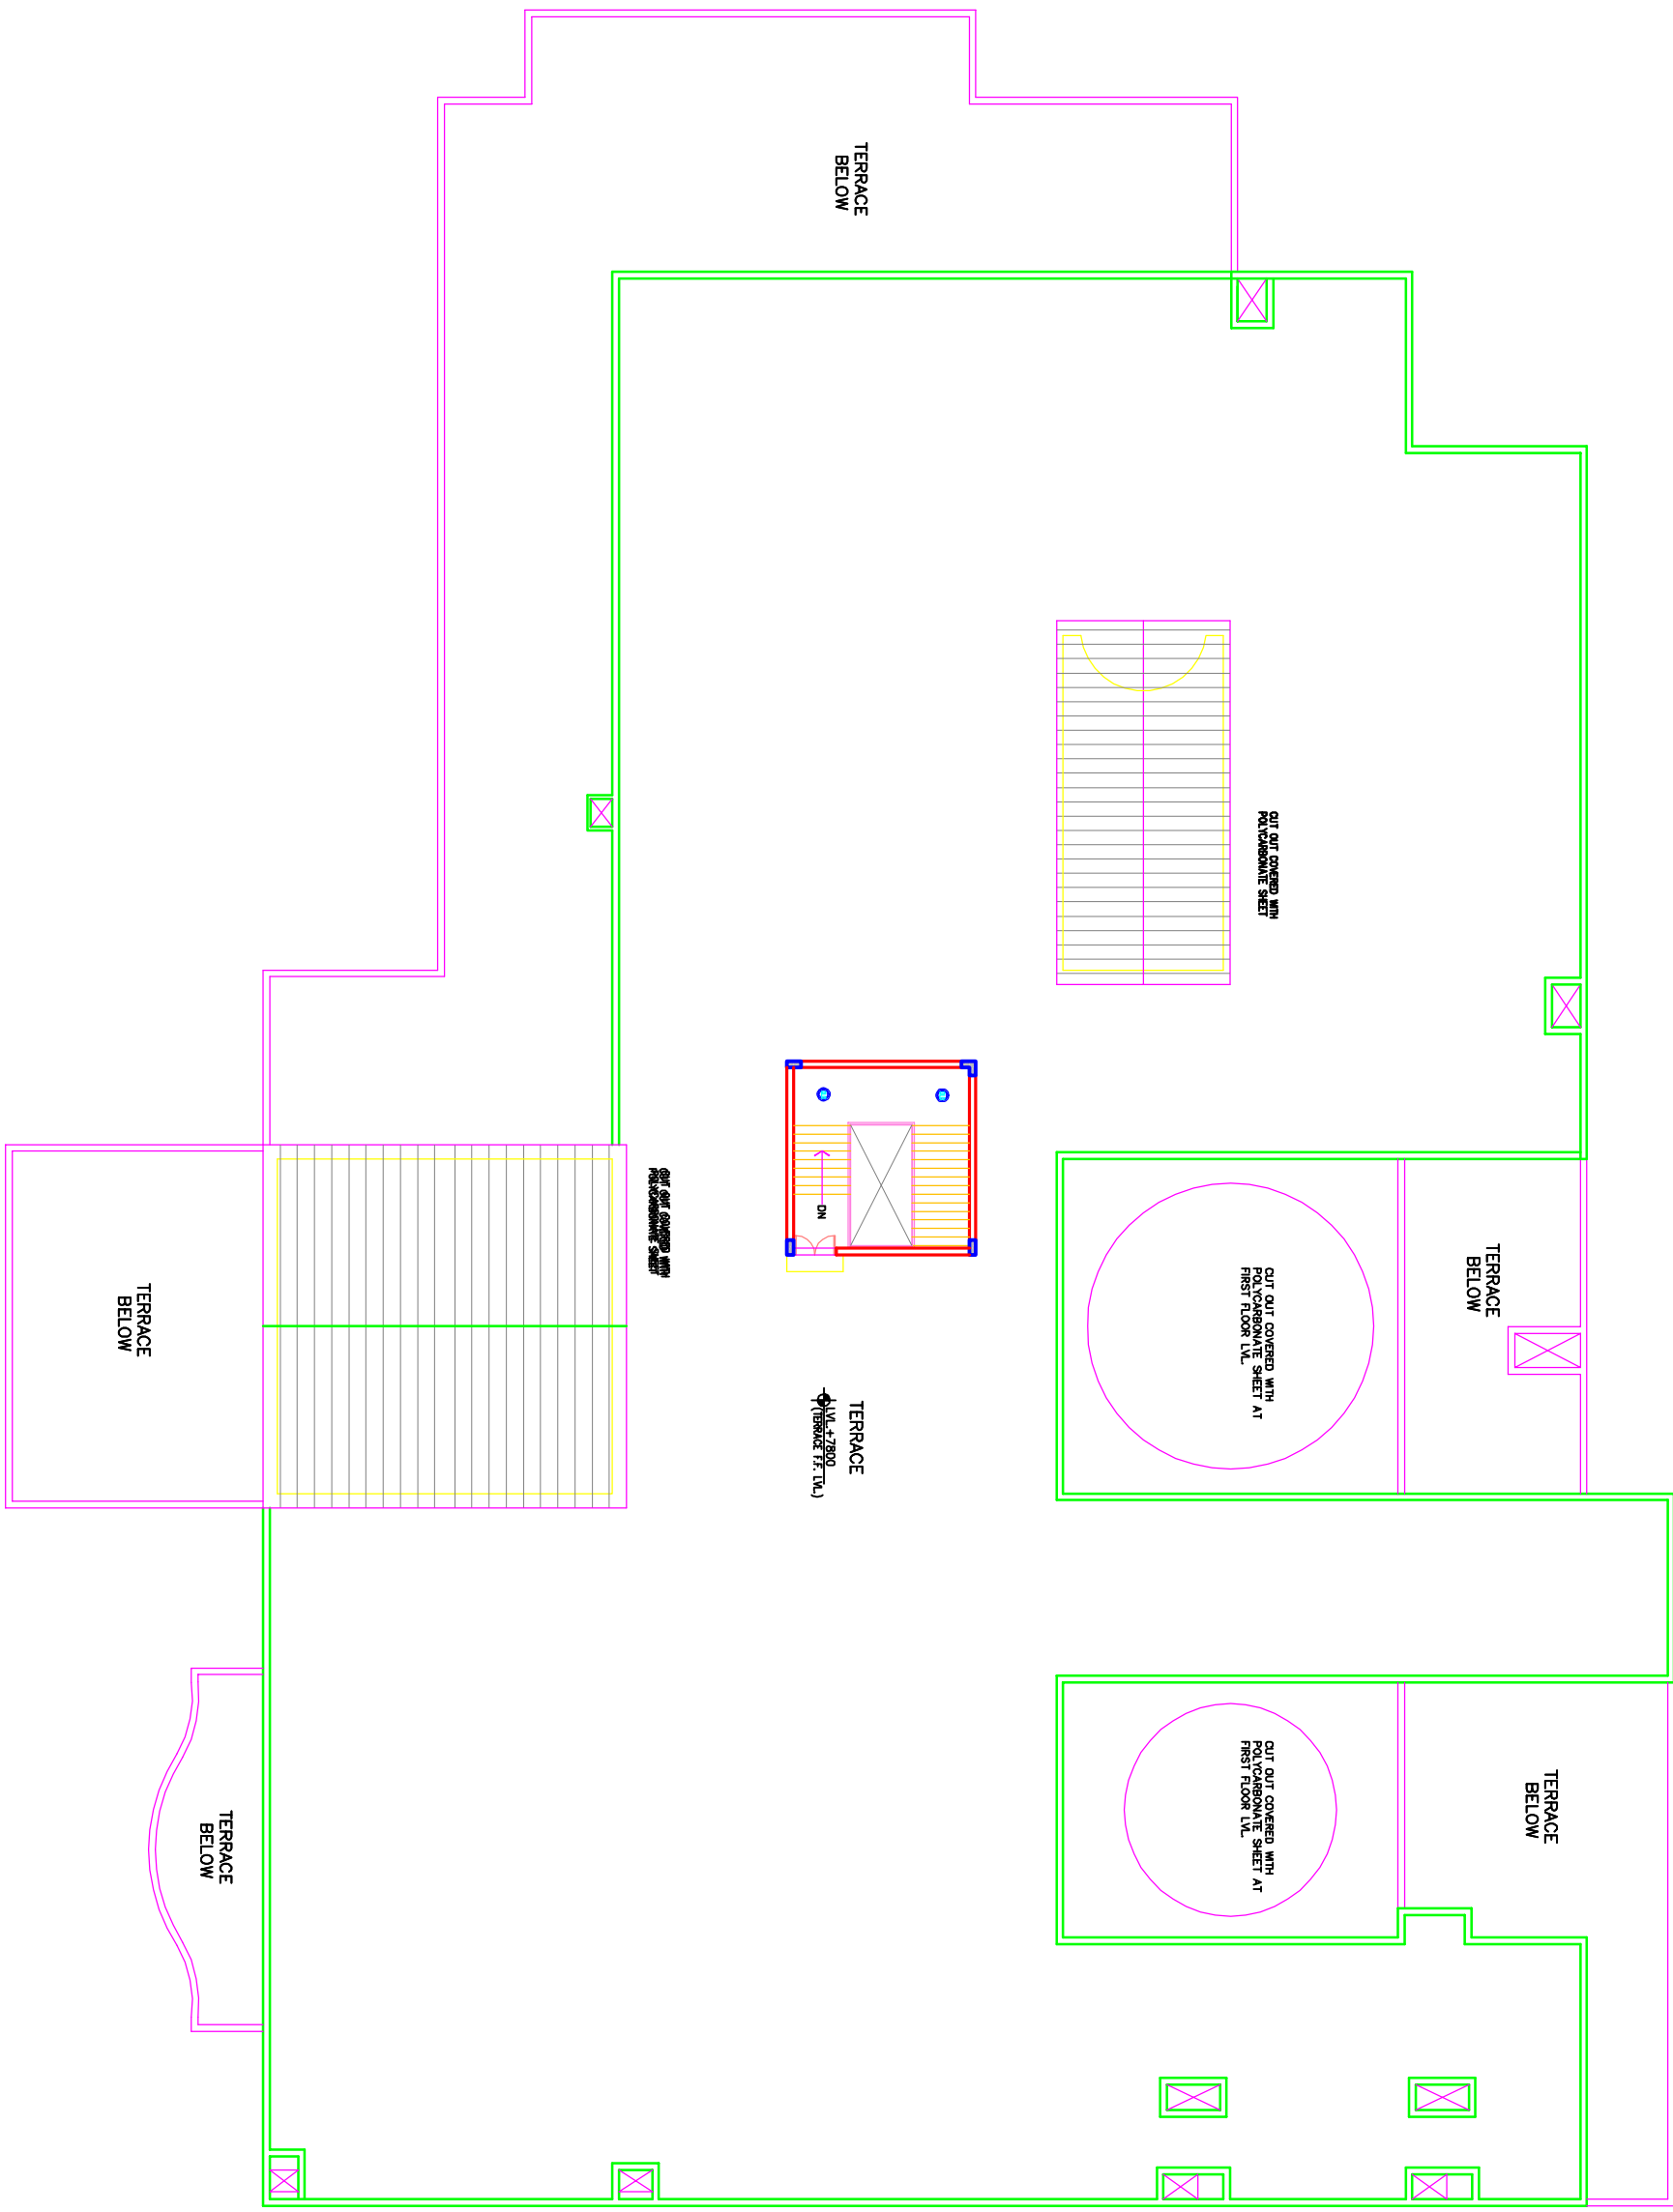

HVAC

DRAWINGS

This drawing with its contents is the sole intellectual property of the Hospital Services Consultancy Corporation (India) Ltd. Copying of this drawing or part thereof for its use in any form whatsoever without the written permission of HSCC is prohibited.

NOTES

REV	DATE	DESCRIPTION

REVISION

PROJECT

Proposed
100 Bedded Hospital
At CHHATTISGARH

TITLE

TENDER DRAWING
GROUND FLOOR PLAN
HVAC LAYOUT

(COVERED AREA=3022 SQ. MT.)

HSCC/D&E/HVAC/NRHM-CG/AC-01 R-0
Drawing No. Rev.

HSCC/- 1:125 25-03-2013
Job No. Scale Date

App by Rev. by Prep. by

HSCC (INDIA) LIMITED
(A GOVERNMENT OF INDIA ENTERPRISES)
HSCC
NEW DELHI INDIA



This drawing with its contents is the sole intellectual property of the Hospital Services Consultancy Corporation (India) Ltd. Copying of this drawing or part thereof or its use in any form whatsoever without the written permission of HSCC is prohibited.

NOTES

REV	DATE	DESCRIPTION

PROJECT

Proposed
100 Bedded Hospital
At CHHATTISGARH

TITLE

TENDER DRAWING
FIRST FLOOR PLAN
HVAC LAYOUT
(COVERED AREA=2050 SQ. MT.)

HSCC/D&E/HVAC/NRHM-CGAC-02 R-0
Drawing No. Rev.

HSCC/- 1:125 19-03-2013
Job No. Scale Date

App by Rev. by Prep. by

HSCC (INDIA) LIMITED
(A GOVERNMENT OF INDIA ENTERPRISES)
HSCC
NEW DELHI INDIA

